 


CAPE PEMBROKE LIGHTHOUSE



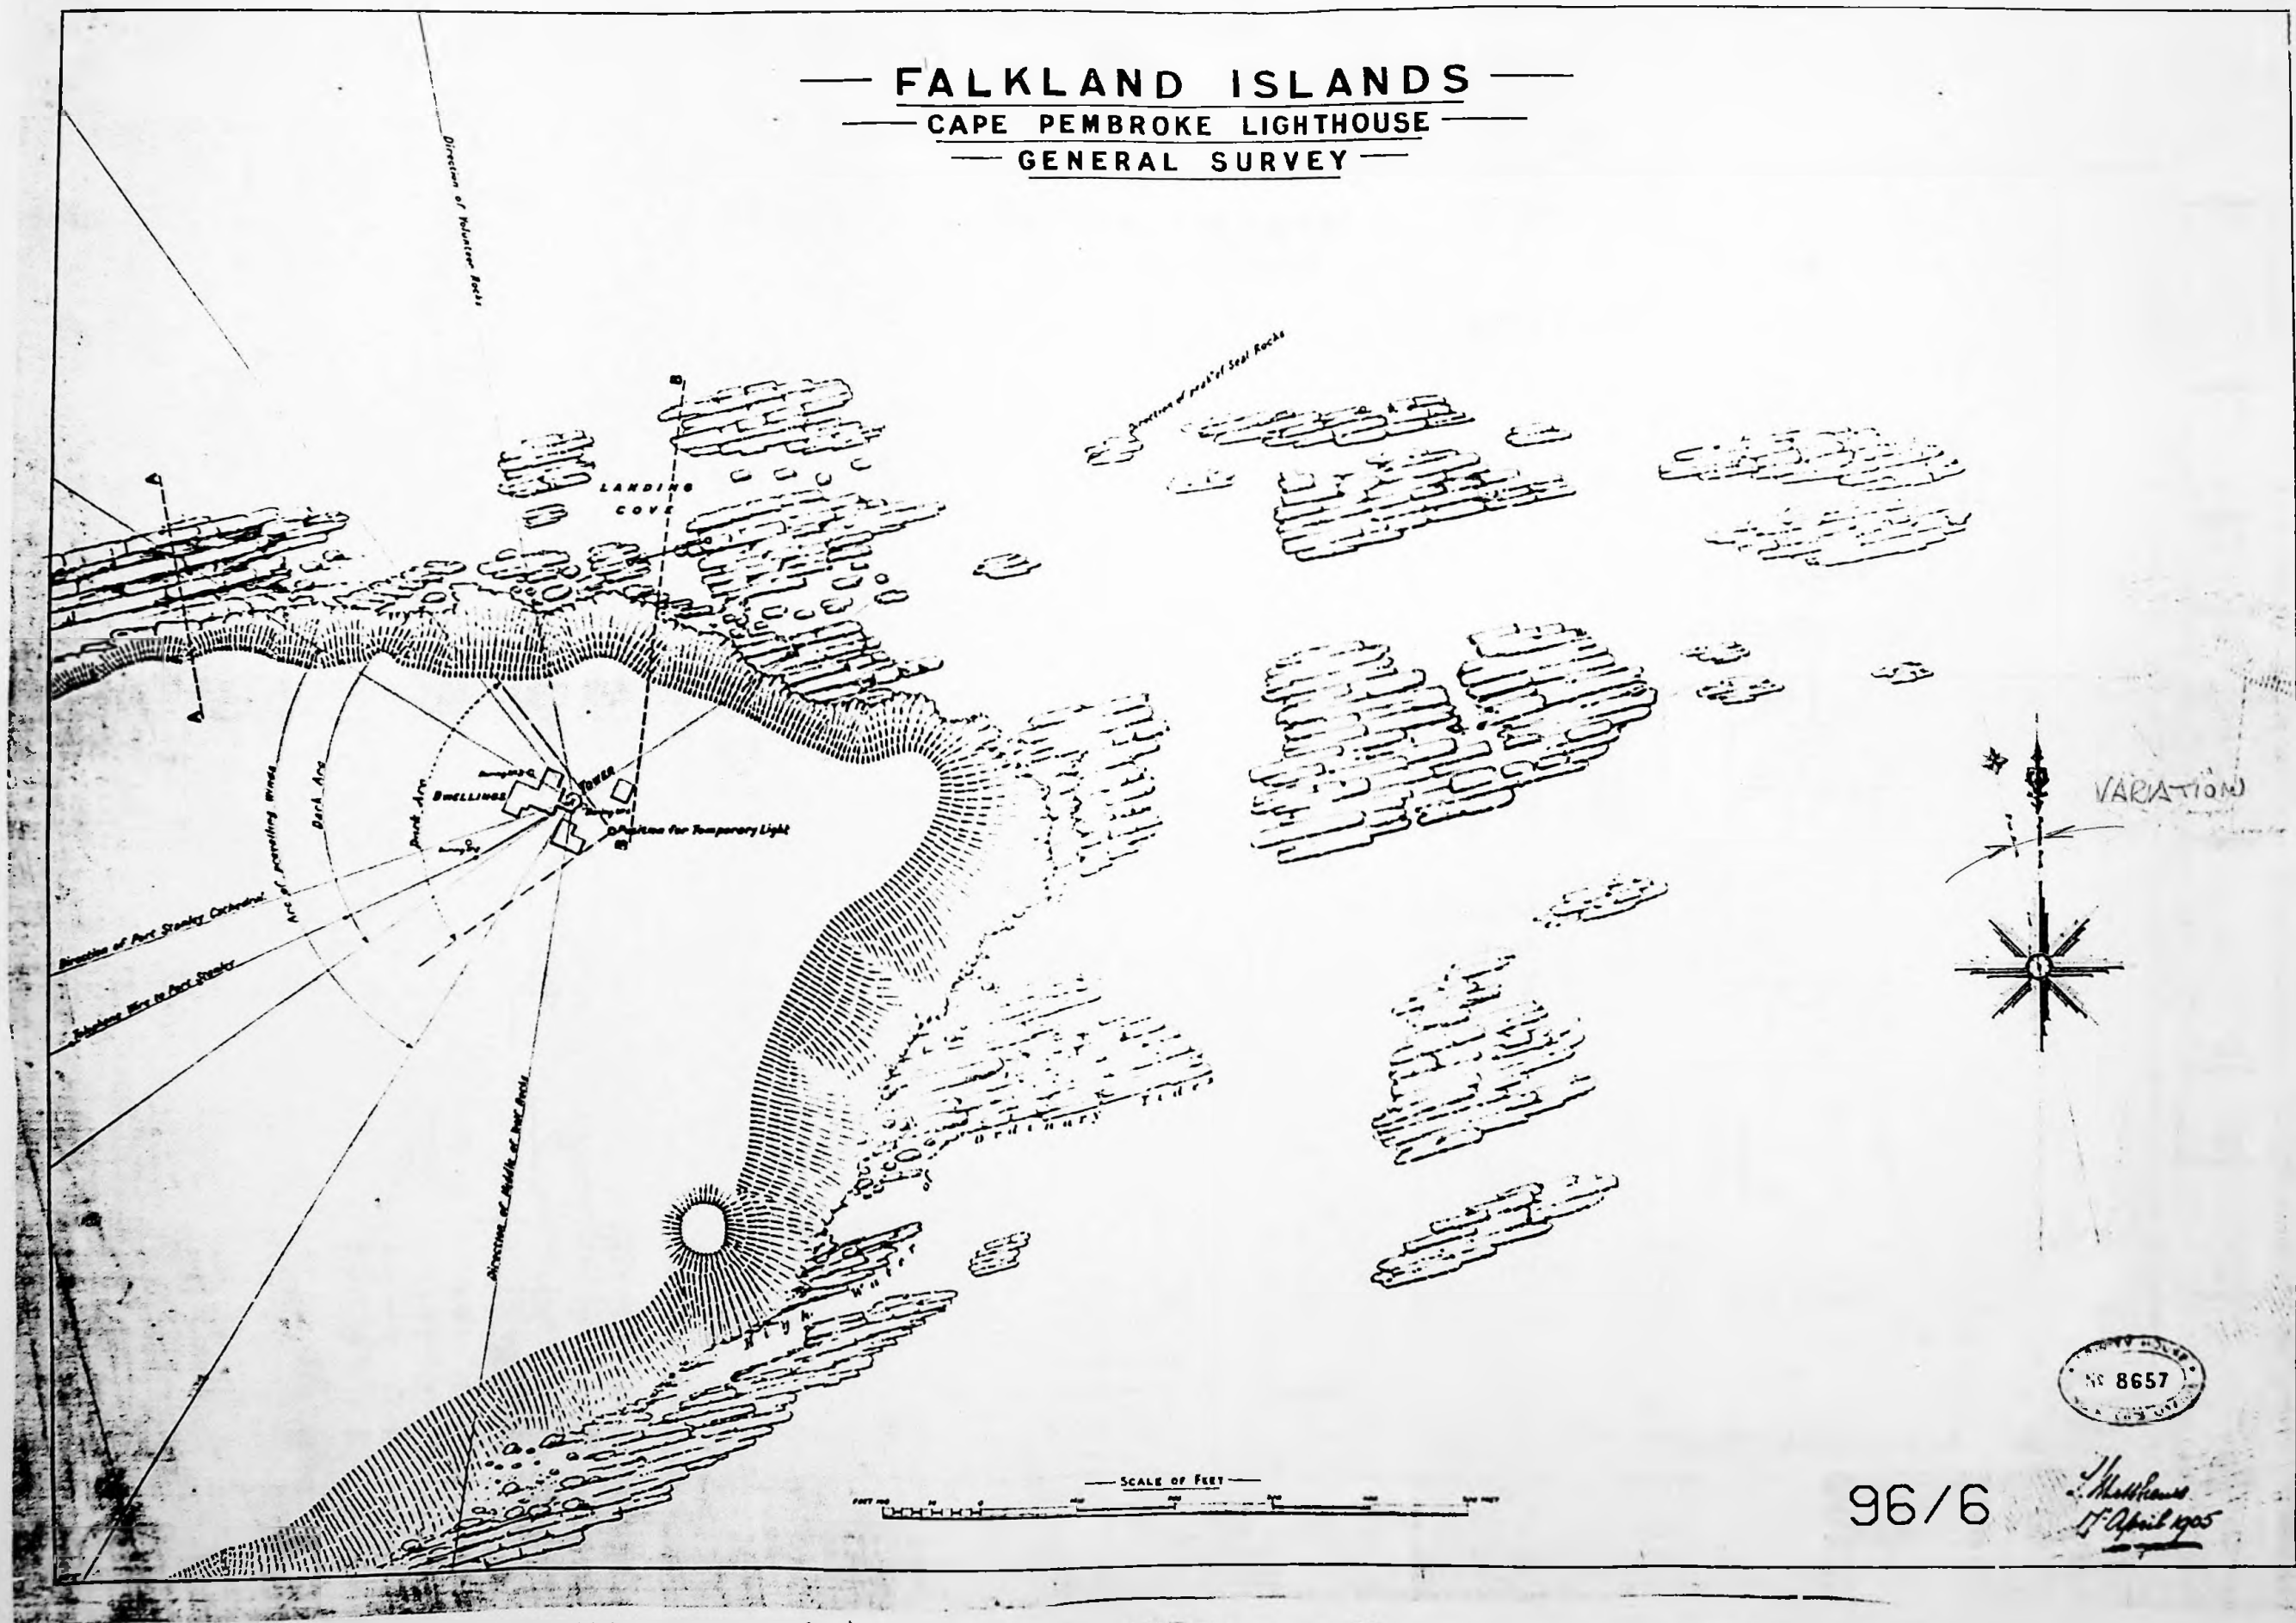
(1118)

1. NAME
 2. ADDRESS
 3. CITY
 4. STATE
 5. ZIP
 6. DATE
 7. TIME
 8. PLACE
 9. REMARKS
 10. SIGNATURE
 11. DATE
 12. TIME
 13. PLACE
 14. REMARKS
 15. SIGNATURE
 16. DATE
 17. TIME
 18. PLACE
 19. REMARKS
 20. SIGNATURE
 21. DATE
 22. TIME
 23. PLACE
 24. REMARKS
 25. SIGNATURE
 26. DATE
 27. TIME
 28. PLACE
 29. REMARKS
 30. SIGNATURE
 31. DATE
 32. TIME
 33. PLACE
 34. REMARKS
 35. SIGNATURE
 36. DATE
 37. TIME
 38. PLACE
 39. REMARKS
 40. SIGNATURE
 41. DATE
 42. TIME
 43. PLACE
 44. REMARKS
 45. SIGNATURE
 46. DATE
 47. TIME
 48. PLACE
 49. REMARKS
 50. SIGNATURE
 51. DATE
 52. TIME
 53. PLACE
 54. REMARKS
 55. SIGNATURE
 56. DATE
 57. TIME
 58. PLACE
 59. REMARKS
 60. SIGNATURE
 61. DATE
 62. TIME
 63. PLACE
 64. REMARKS
 65. SIGNATURE
 66. DATE
 67. TIME
 68. PLACE
 69. REMARKS
 70. SIGNATURE
 71. DATE
 72. TIME
 73. PLACE
 74. REMARKS
 75. SIGNATURE
 76. DATE
 77. TIME
 78. PLACE
 79. REMARKS
 80. SIGNATURE
 81. DATE
 82. TIME
 83. PLACE
 84. REMARKS
 85. SIGNATURE
 86. DATE
 87. TIME
 88. PLACE
 89. REMARKS
 90. SIGNATURE
 91. DATE
 92. TIME
 93. PLACE
 94. REMARKS
 95. SIGNATURE
 96. DATE
 97. TIME
 98. PLACE
 99. REMARKS
 100. SIGNATURE
 101. DATE
 102. TIME
 103. PLACE
 104. REMARKS
 105. SIGNATURE
 106. DATE
 107. TIME
 108. PLACE
 109. REMARKS
 110. SIGNATURE
 111. DATE
 112. TIME
 113. PLACE
 114. REMARKS
 115. SIGNATURE
 116. DATE
 117. TIME
 118. PLACE
 119. REMARKS
 120. SIGNATURE
 121. DATE
 122. TIME
 123. PLACE
 124. REMARKS
 125. SIGNATURE
 126. DATE
 127. TIME
 128. PLACE
 129. REMARKS
 130. SIGNATURE
 131. DATE
 132. TIME
 133. PLACE
 134. REMARKS
 135. SIGNATURE
 136. DATE
 137. TIME
 138. PLACE
 139. REMARKS
 140. SIGNATURE
 141. DATE
 142. TIME
 143. PLACE
 144. REMARKS
 145. SIGNATURE
 146. DATE
 147. TIME
 148. PLACE
 149. REMARKS
 150. SIGNATURE
 151. DATE
 152. TIME
 153. PLACE
 154. REMARKS
 155. SIGNATURE
 156. DATE
 157. TIME
 158. PLACE
 159. REMARKS
 160. SIGNATURE
 161. DATE
 162. TIME
 163. PLACE
 164. REMARKS
 165. SIGNATURE
 166. DATE
 167. TIME
 168. PLACE
 169. REMARKS
 170. SIGNATURE
 171. DATE
 172. TIME
 173. PLACE
 174. REMARKS
 175. SIGNATURE
 176. DATE
 177. TIME
 178. PLACE
 179. REMARKS
 180. SIGNATURE
 181. DATE
 182. TIME
 183. PLACE
 184. REMARKS
 185. SIGNATURE
 186. DATE
 187. TIME
 188. PLACE
 189. REMARKS
 190. SIGNATURE
 191. DATE
 192. TIME
 193. PLACE
 194. REMARKS
 195. SIGNATURE
 196. DATE
 197. TIME
 198. PLACE
 199. REMARKS
 200. SIGNATURE
 201. DATE
 202. TIME
 203. PLACE
 204. REMARKS
 205. SIGNATURE
 206. DATE
 207. TIME
 208. PLACE
 209. REMARKS
 210. SIGNATURE
 211. DATE
 212. TIME
 213. PLACE
 214. REMARKS
 215. SIGNATURE
 216. DATE
 217. TIME
 218. PLACE
 219. REMARKS
 220. SIGNATURE
 221. DATE
 222. TIME
 223. PLACE
 224. REMARKS
 225. SIGNATURE
 226. DATE
 227. TIME
 228. PLACE
 229. REMARKS
 230. SIGNATURE
 231. DATE
 232. TIME
 233. PLACE
 234. REMARKS
 235. SIGNATURE
 236. DATE
 237. TIME
 238. PLACE
 239. REMARKS
 240. SIGNATURE
 241. DATE
 242. TIME
 243. PLACE
 244. REMARKS
 245. SIGNATURE
 246. DATE
 247. TIME
 248. PLACE
 249. REMARKS
 250. SIGNATURE
 251. DATE
 252. TIME
 253. PLACE
 254.



96/2

— FALKLAND ISLANDS —
 — CAPE PEMBROKE LIGHTHOUSE —
 — GENERAL SURVEY —









ALIGNMENT $72^{\circ}5'$ WEST OF NORTH $\rightarrow$ STANLEY CATHEDRAL

FALKLAND ISLANDS
CAPE PEMBROKE LIGHTHOUSE

Nº 1

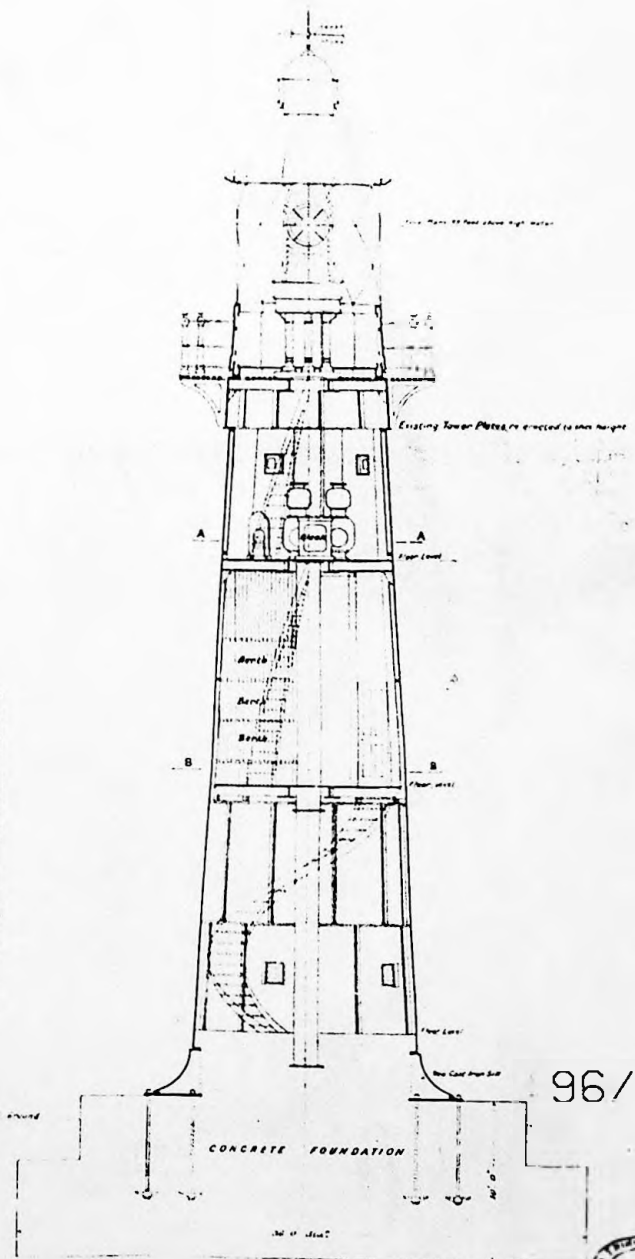 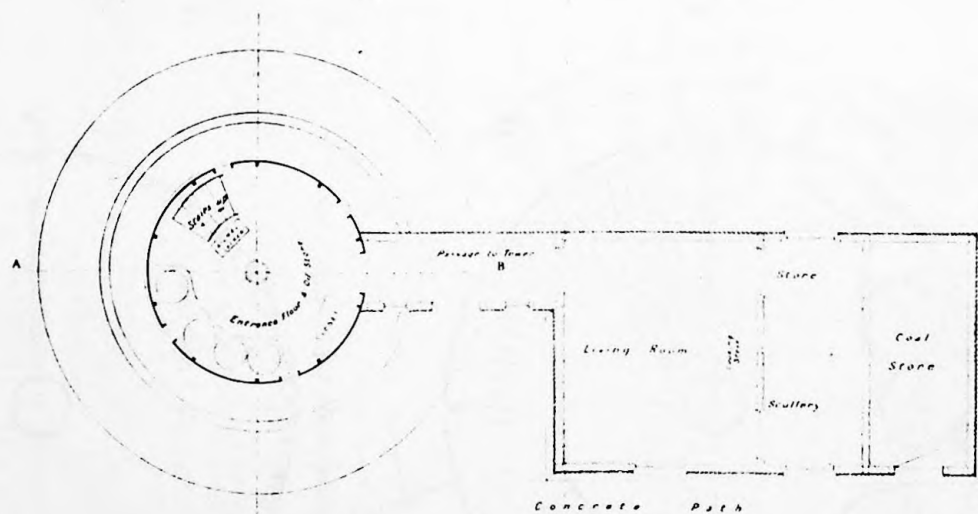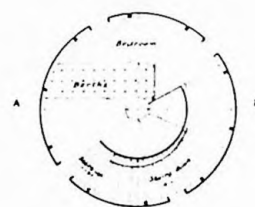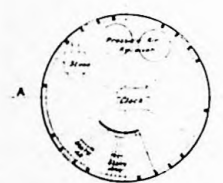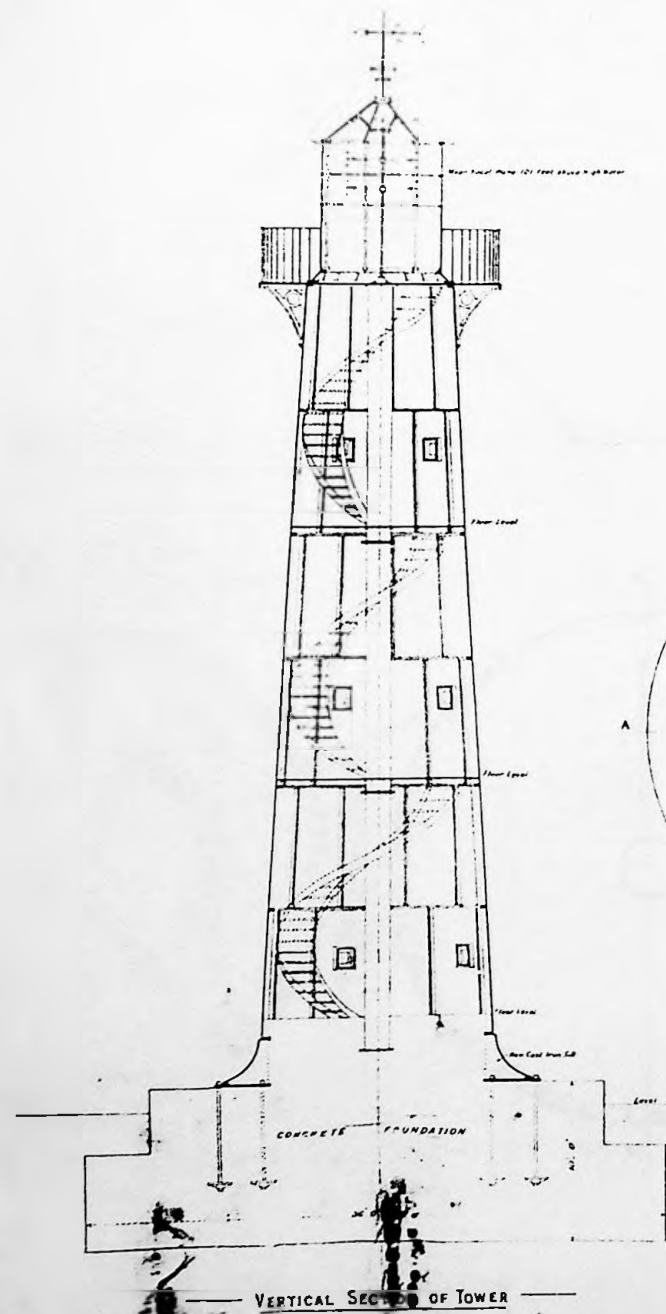Nº 2




96/7




FALKLAND ISLANDS

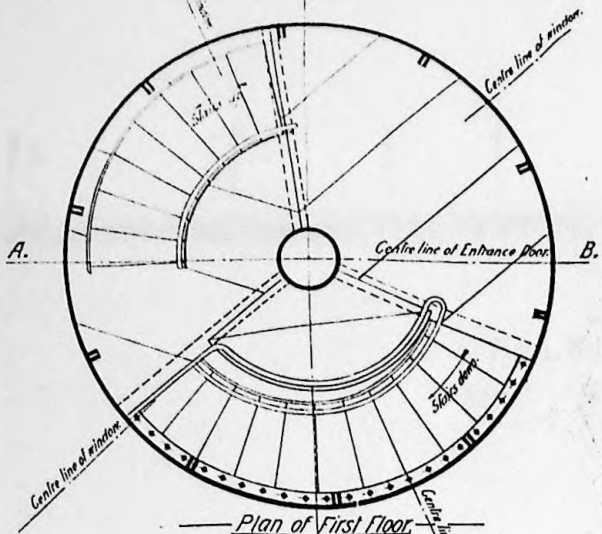
CAPE PEMBROKE LIGHTHOUSE



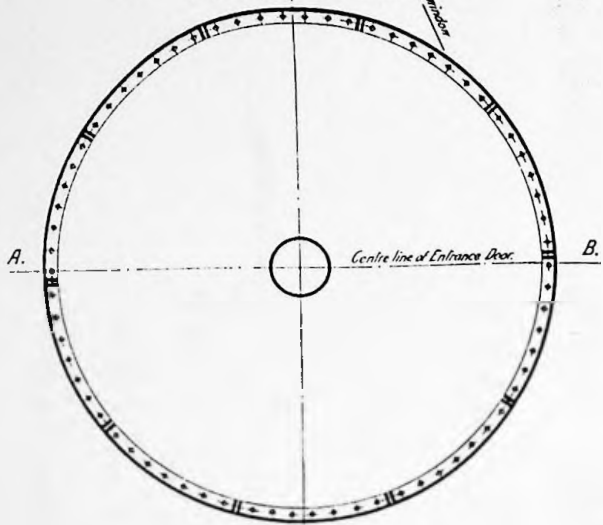
Plan of First Floor and Third Tier of Plates.




Plan of Second Tier of Plates.

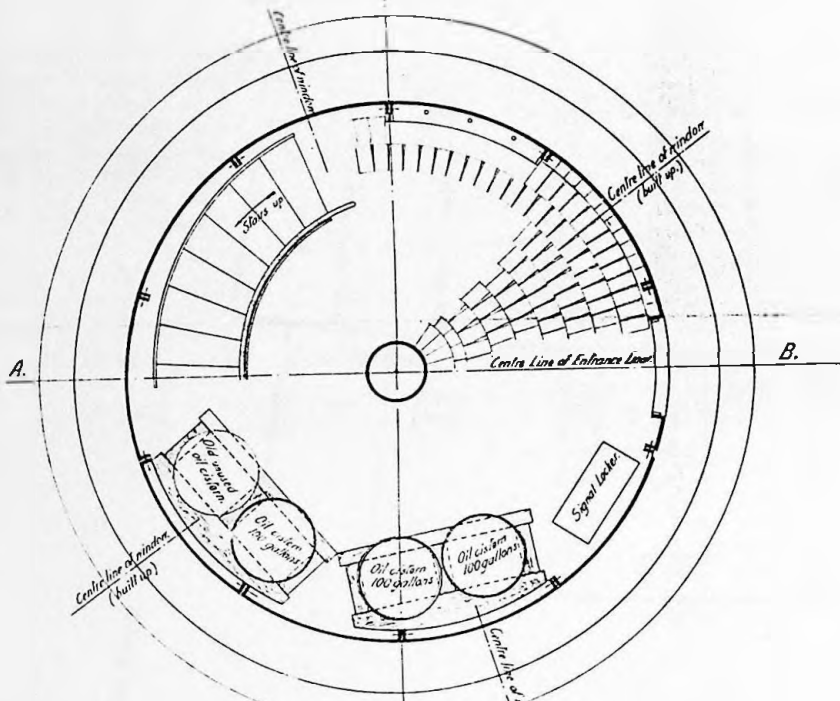

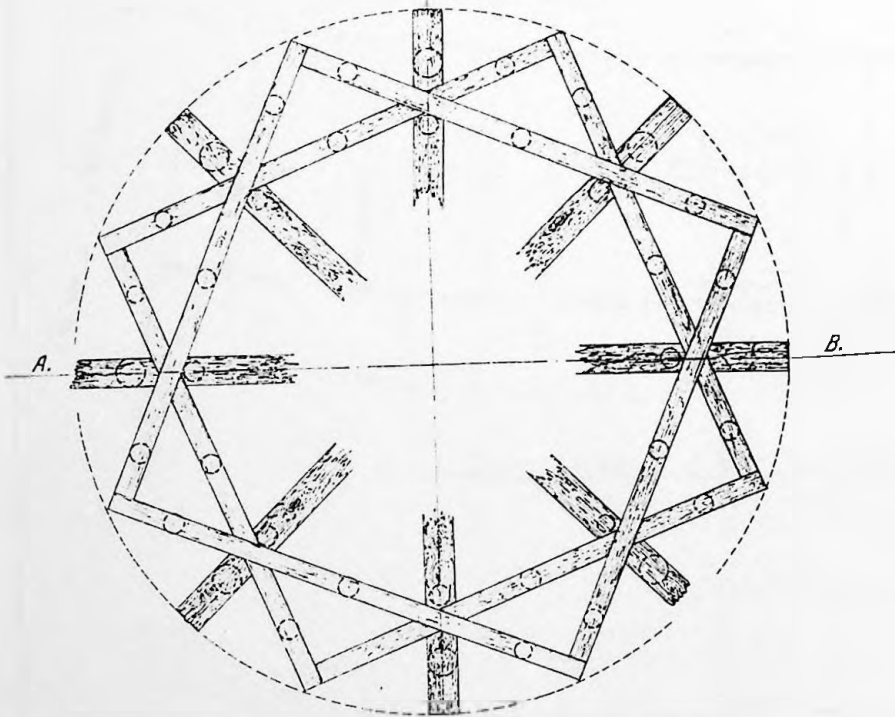
Plan of Entrance Floor and First Tier of Plates.



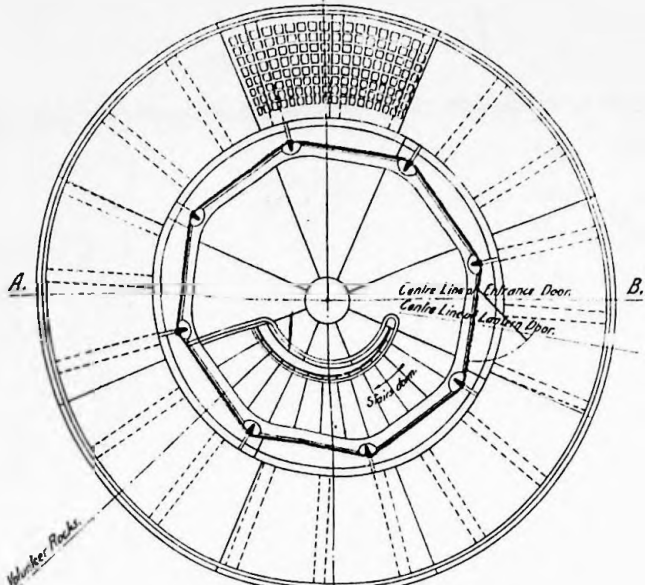
Part Plan of Piling and Timber Foundation.




Plan of Lantern Floor and Gallery.

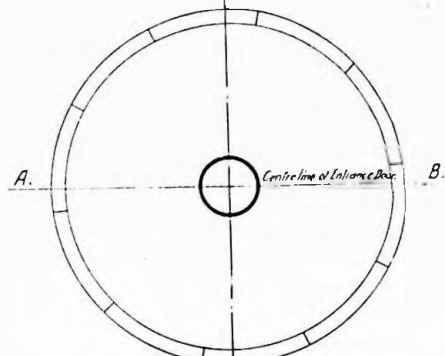


Plan on Top of Sixth Tier of Plates.

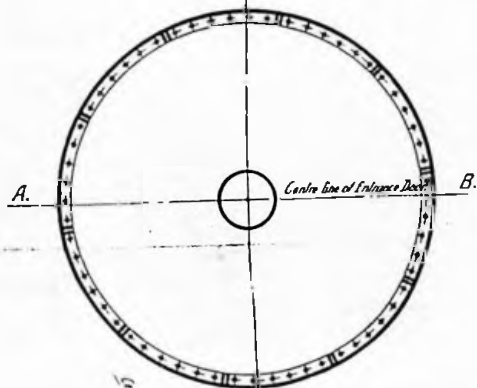

Plan of Sixth Tier of Plates.

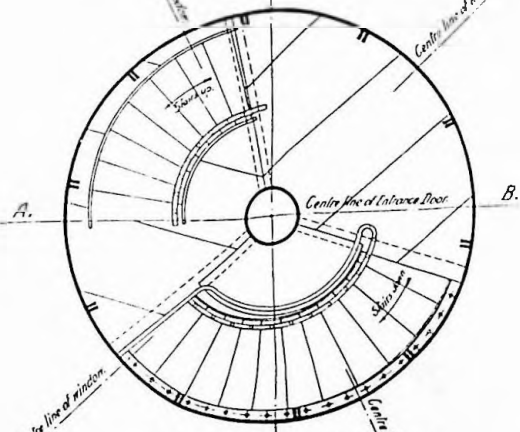

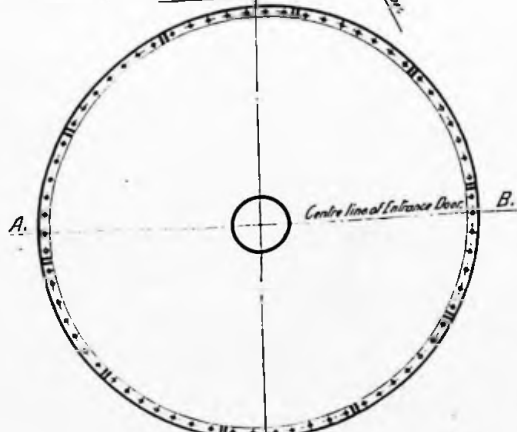Plan of Second Floor and Fifth Tier of Plates.



Plan of Fourth Tier of Plates.

96/8

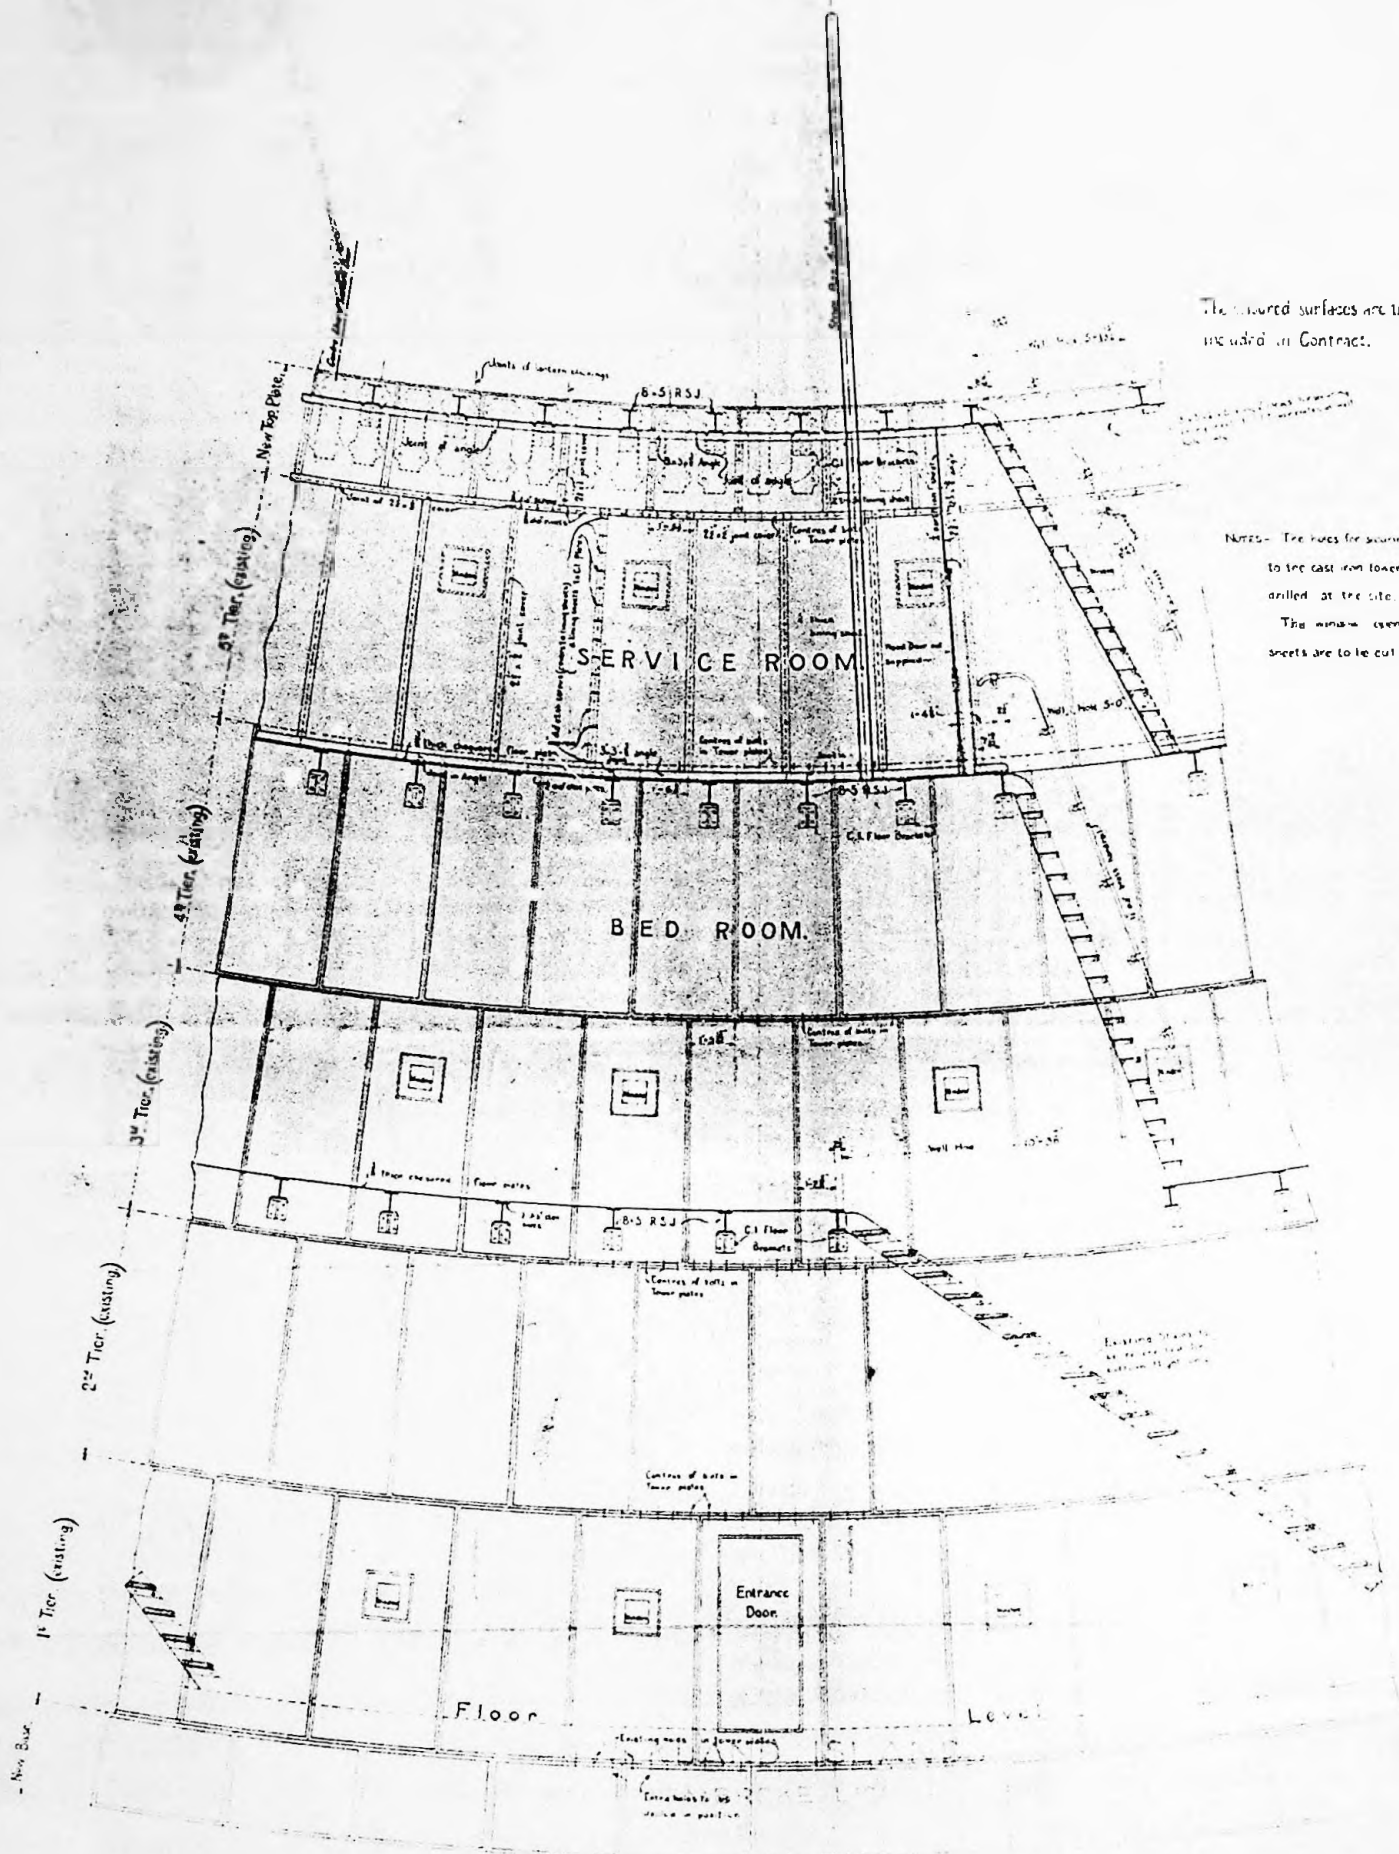


Handwritten signature and date: 14 April 1905

Printer

FALKLAND ISLANDS CAPE PEMBROKE LIGHTHOUSE.

Scale 1/4 inch to a foot



The shaded surfaces are those parts included in Contract.

Notes— The rules for securing the lining sheets to the cast iron lower plates are to be drilled at the site.
The minimum openings in the lining sheets are to be cut out at the site.

Inside development of tower on outside radius of 10 feet.

96/10


Drawn by C2-757

FALKLAND ISLANDS


CAPE PEMBROKE LIGHTHOUSE



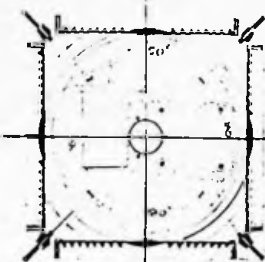Diagram of Flasher



Sectional Plan through Focal Plane

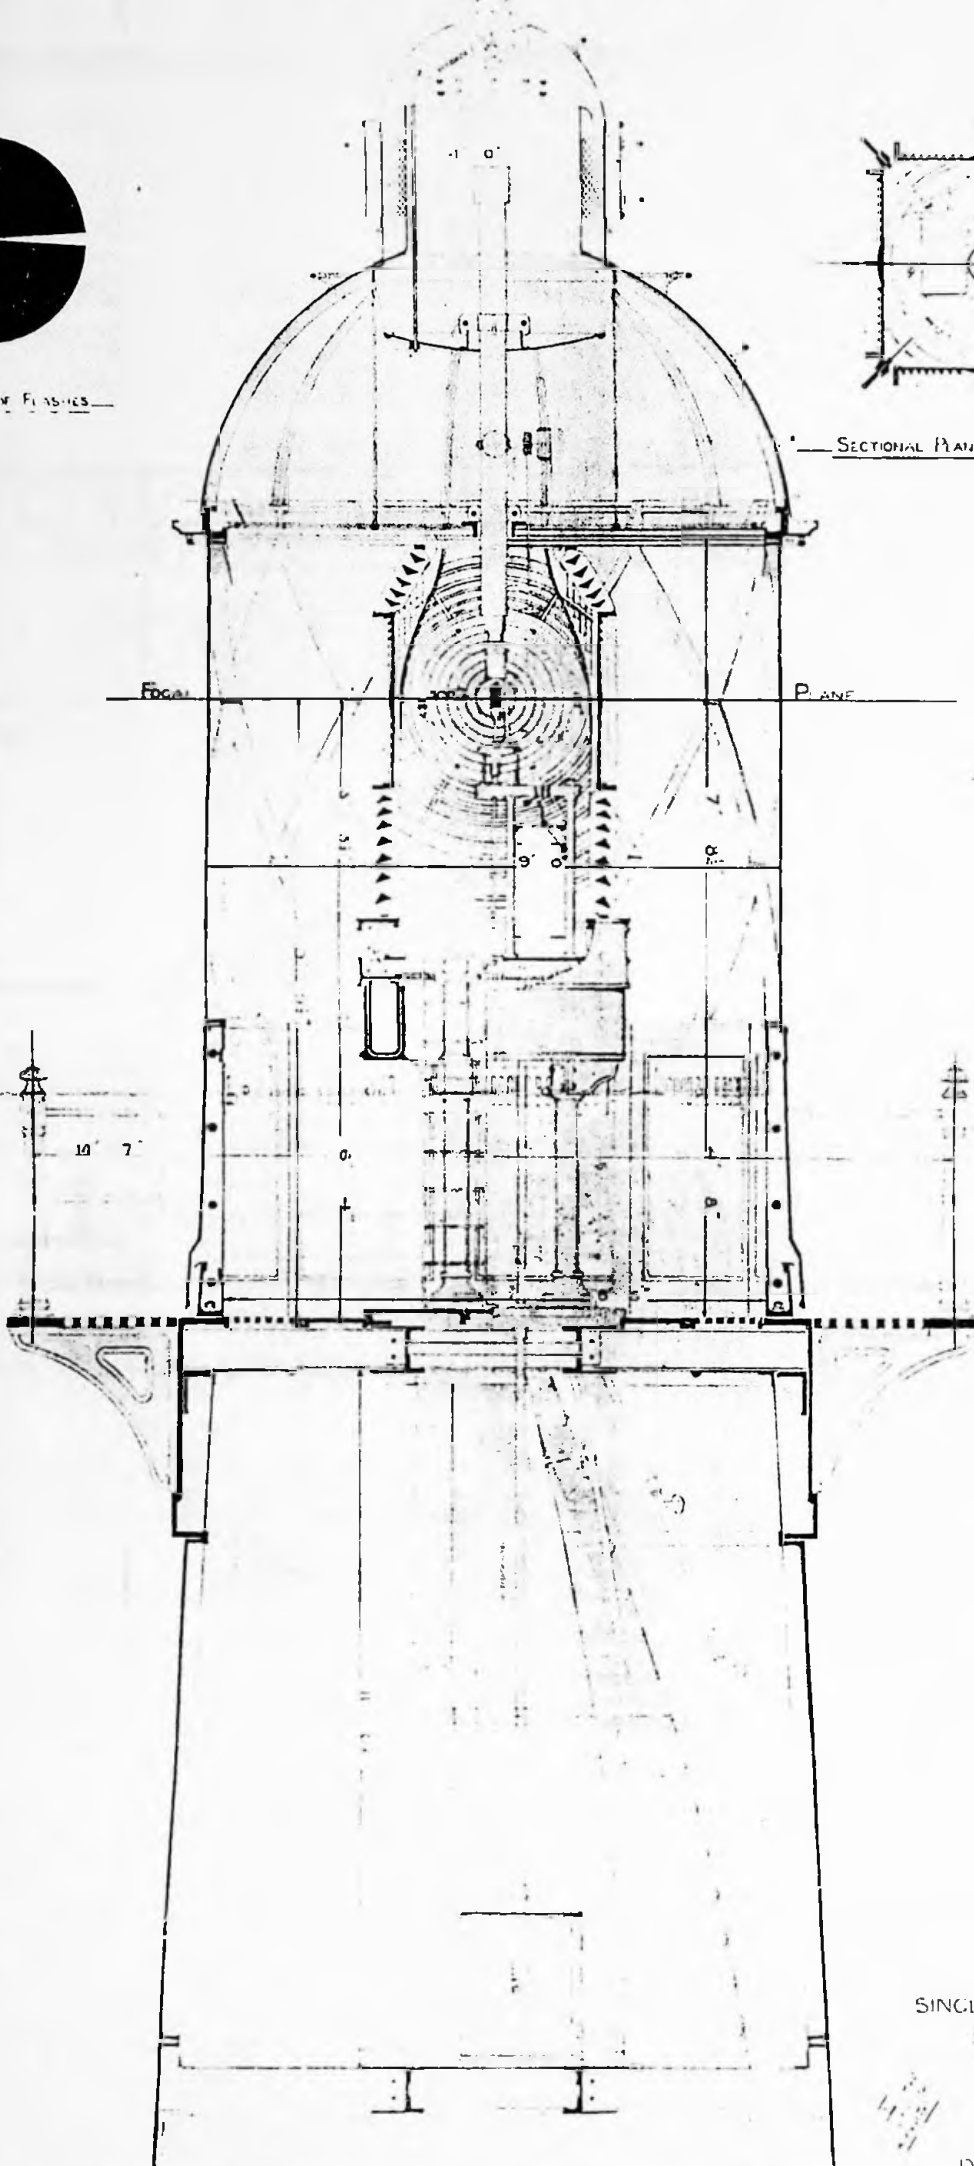

96/11

SINGLE FLASHING APPARATUS

Scale 1/4" = 1' 0"

DESIGNED BY J. H. B. & CO. LTD.
LONDON

DRAWING N 1522

A0

A1

A2

A3

A4

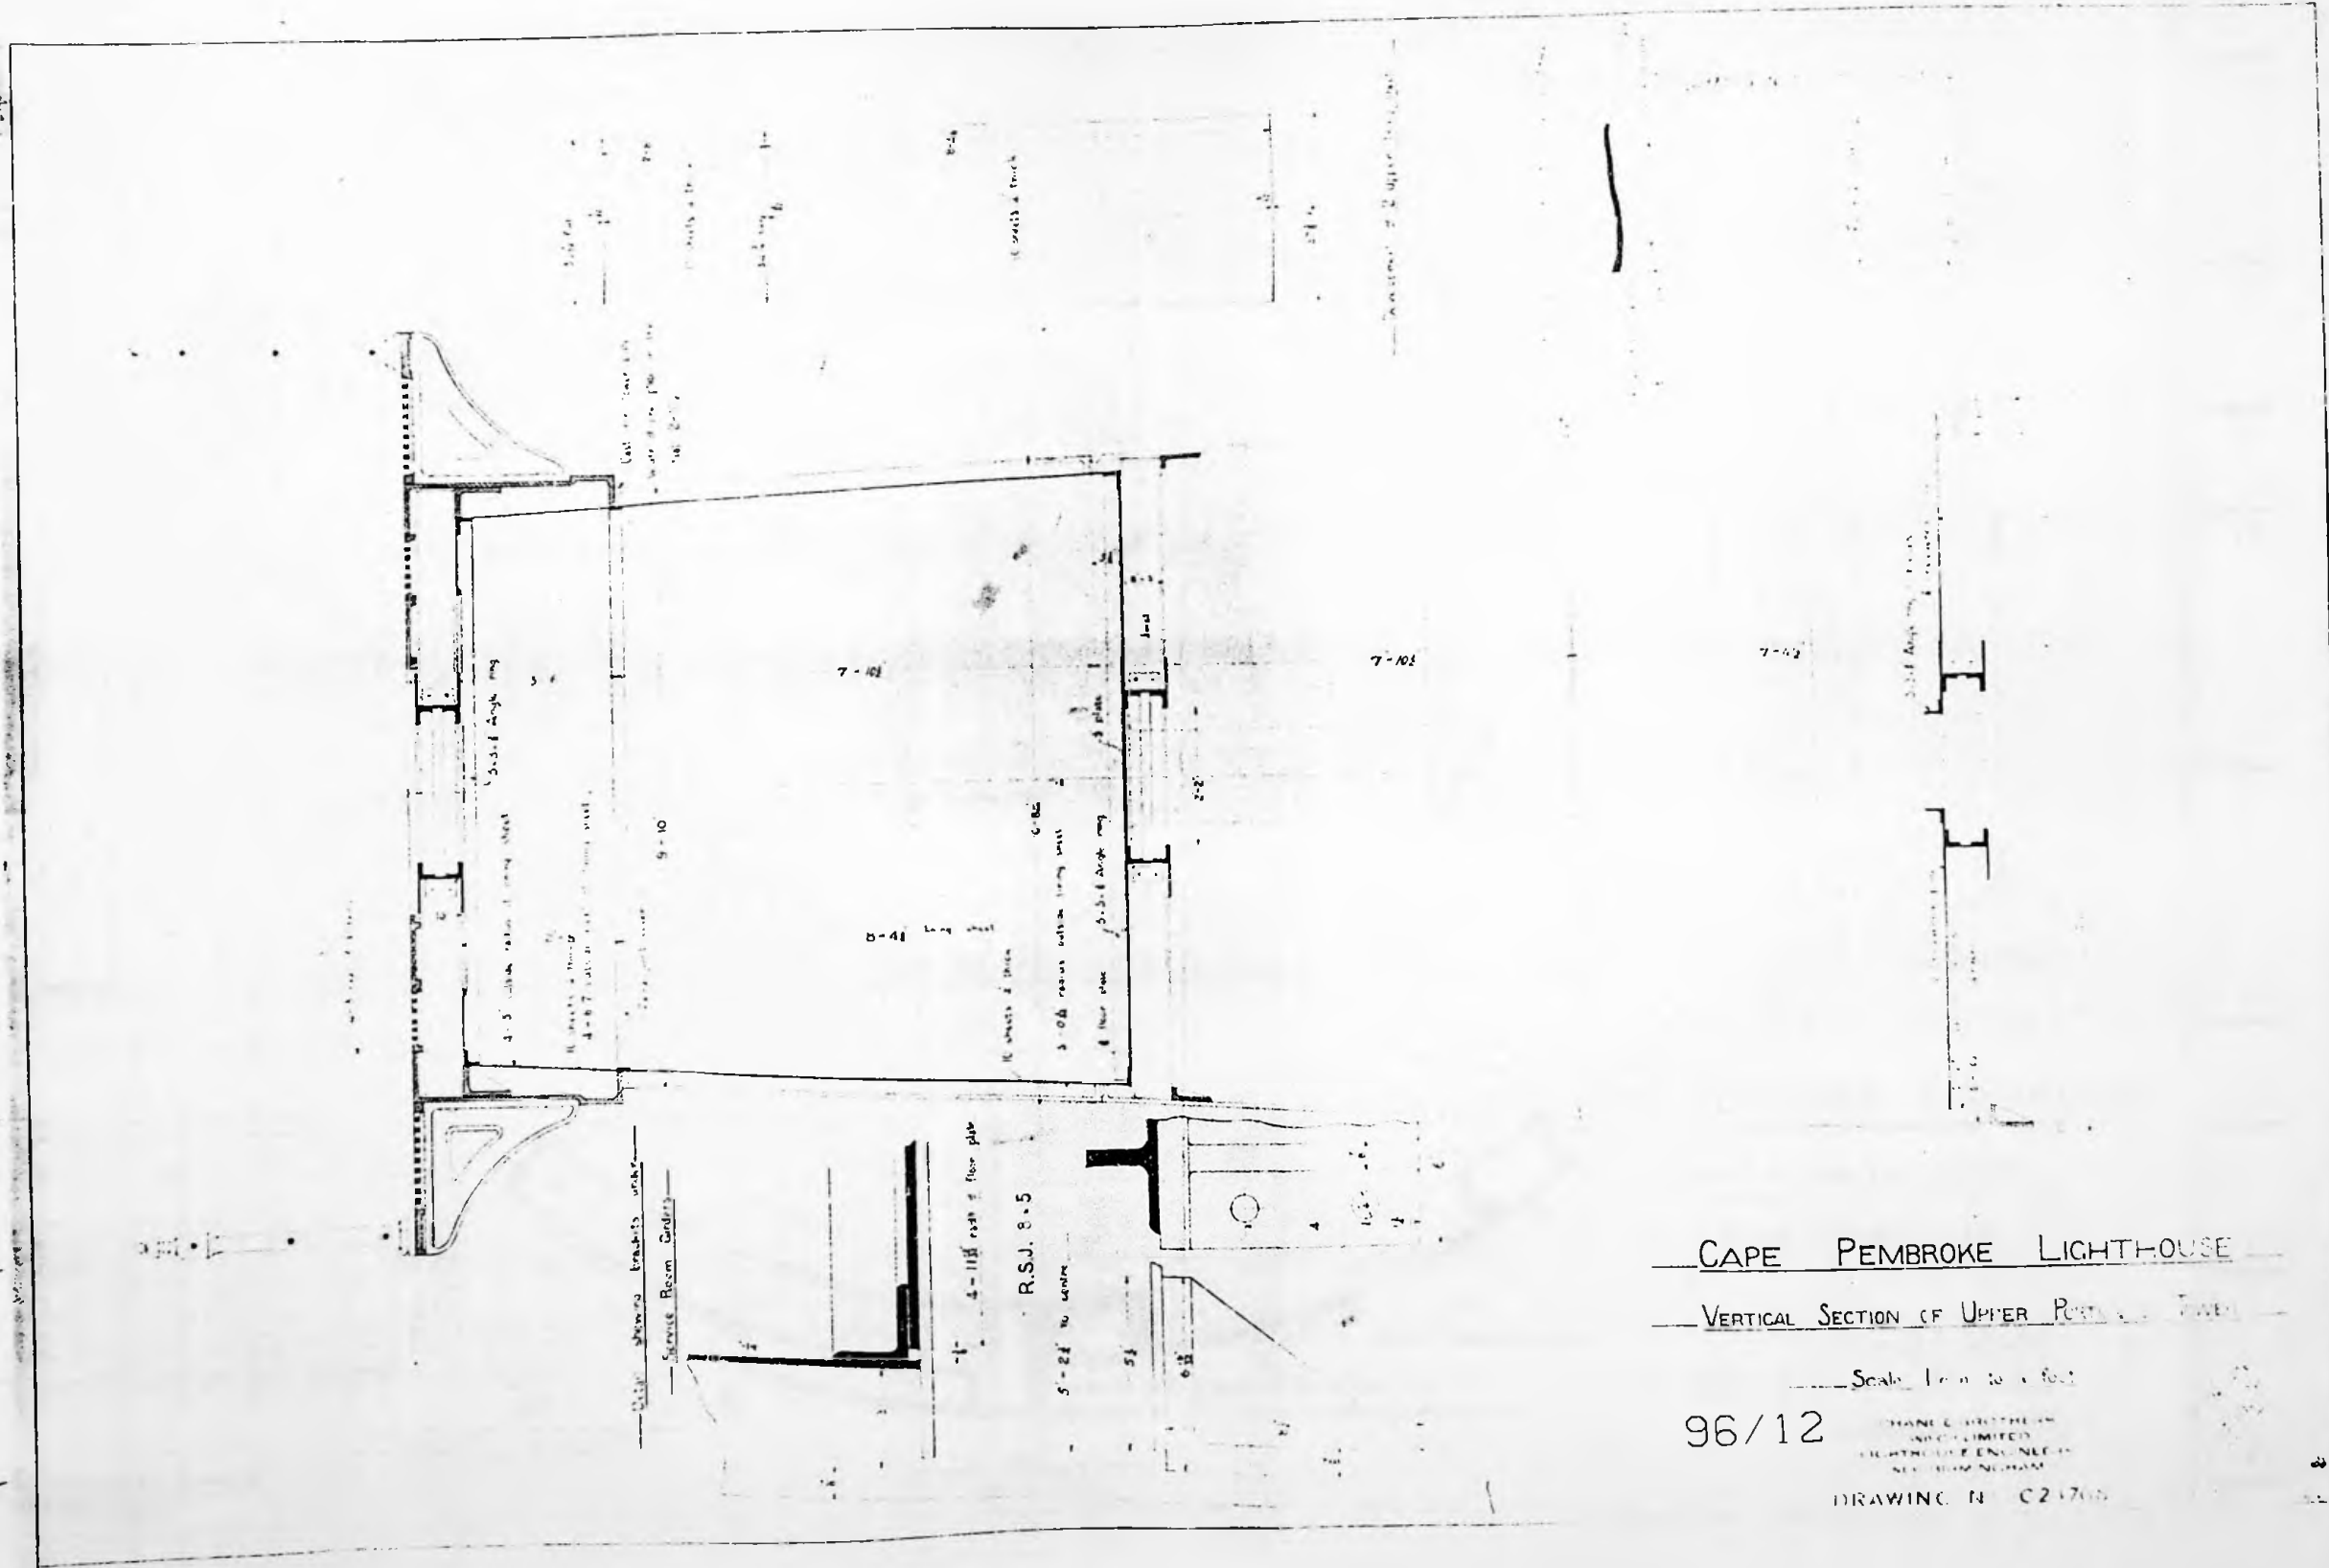
A5

A6

A7

A8

A9



CAPE PEMBROKE LIGHTHOUSE

VERTICAL SECTION OF UPPER PART

Scale 1 in = 10 feet

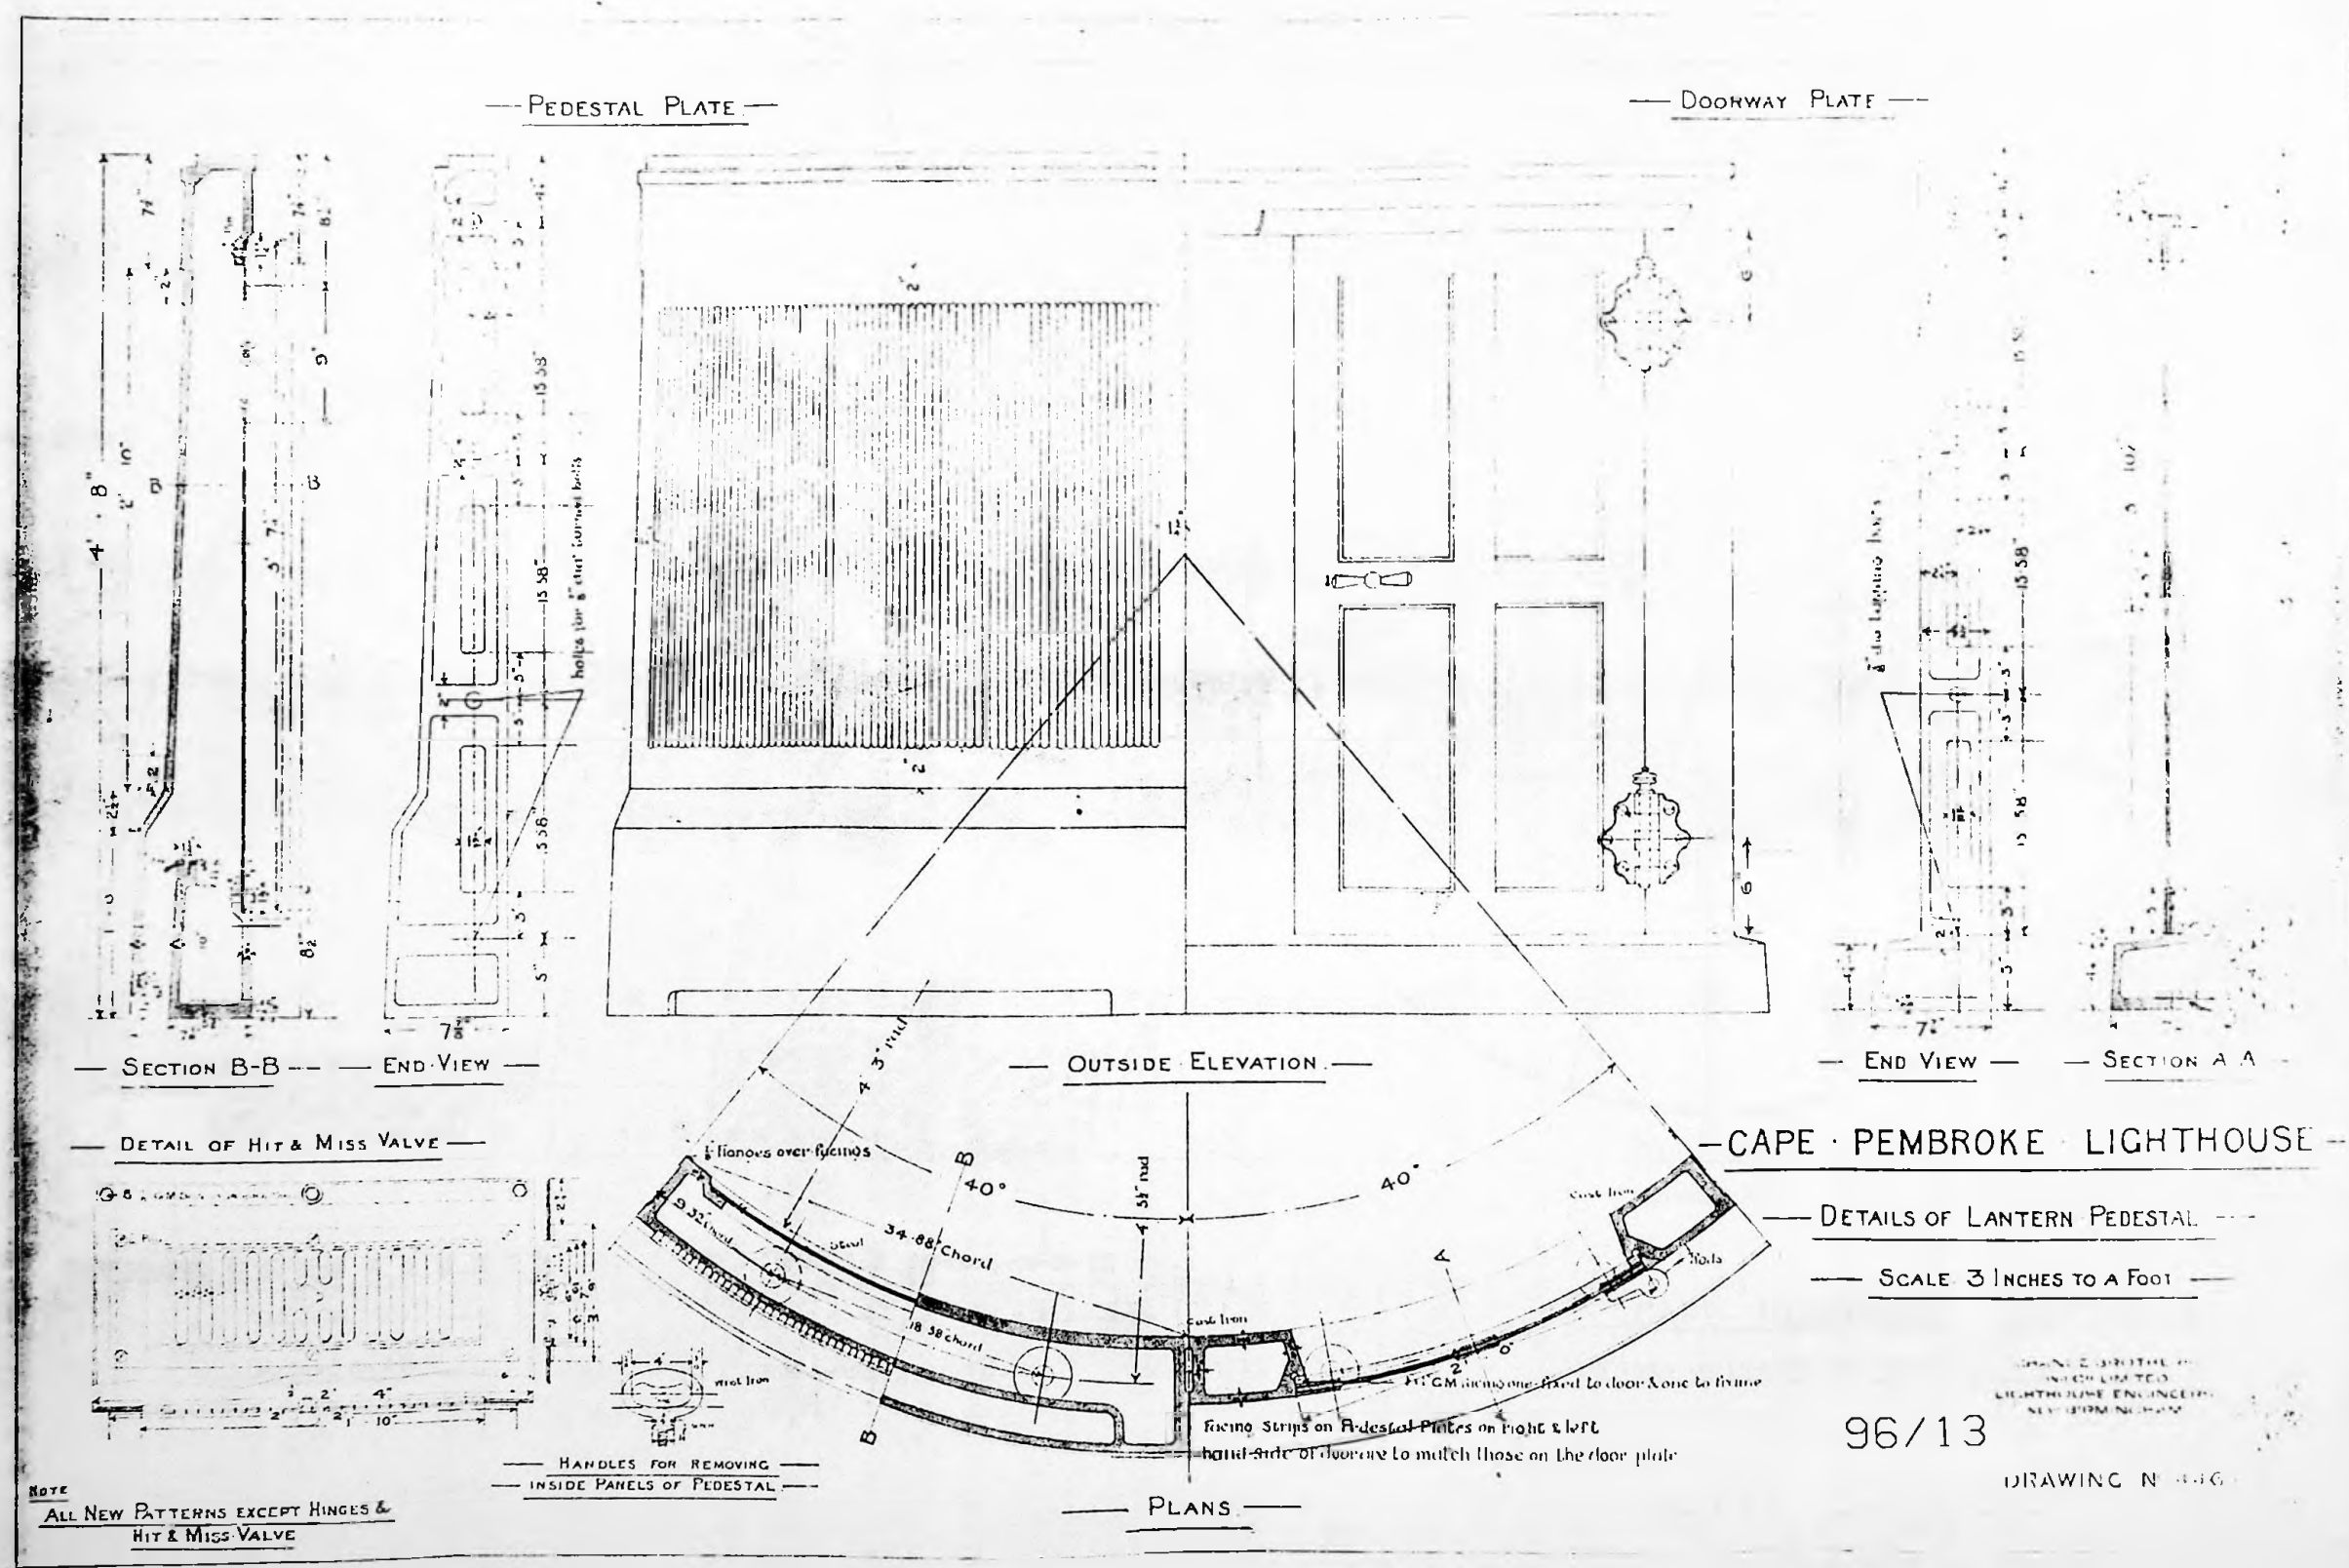
96/12

THOMAS & BROTHERS
LIMITED
LIGHTHOUSE ENGINEERS
NEW BRIGHTON

DRAWING NO. C21710

A11

0A
1A
2A
100A



1A
2A
3A
100A

0A

A

A

A

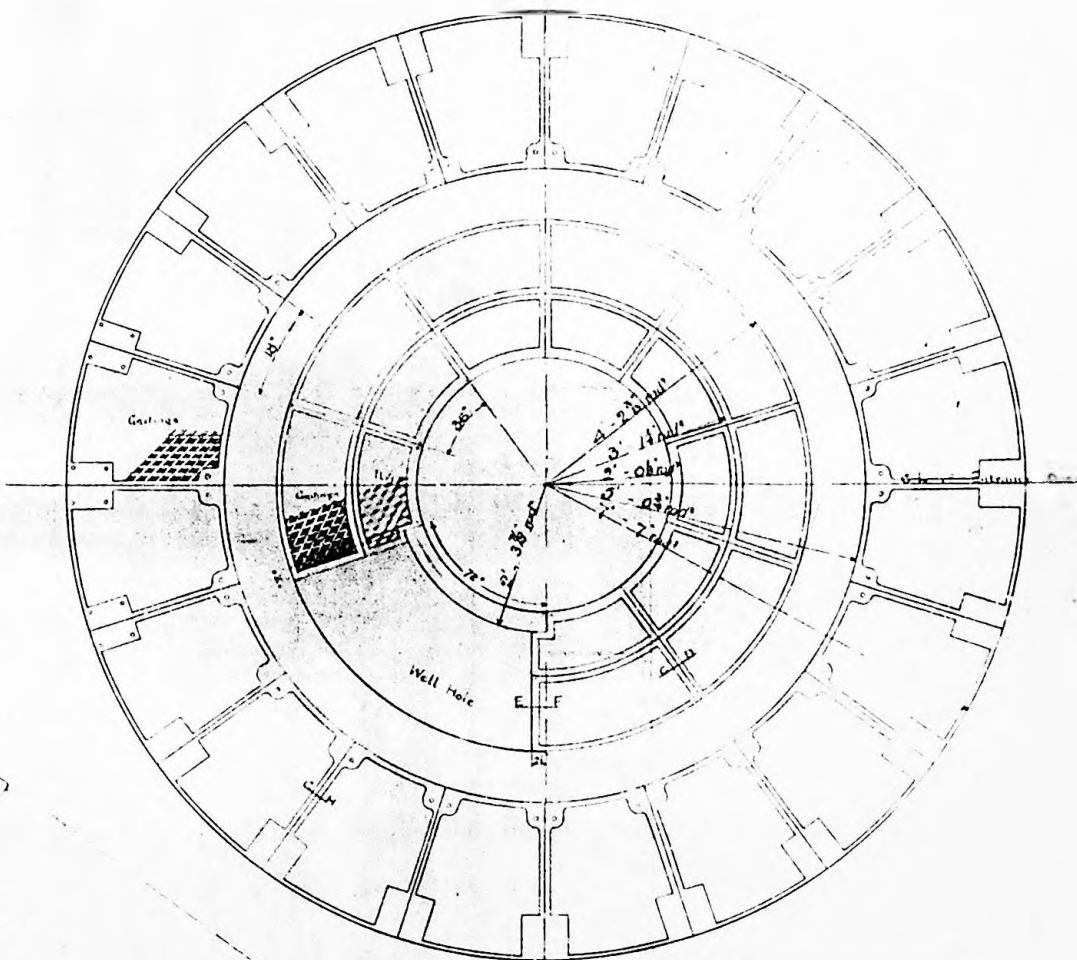
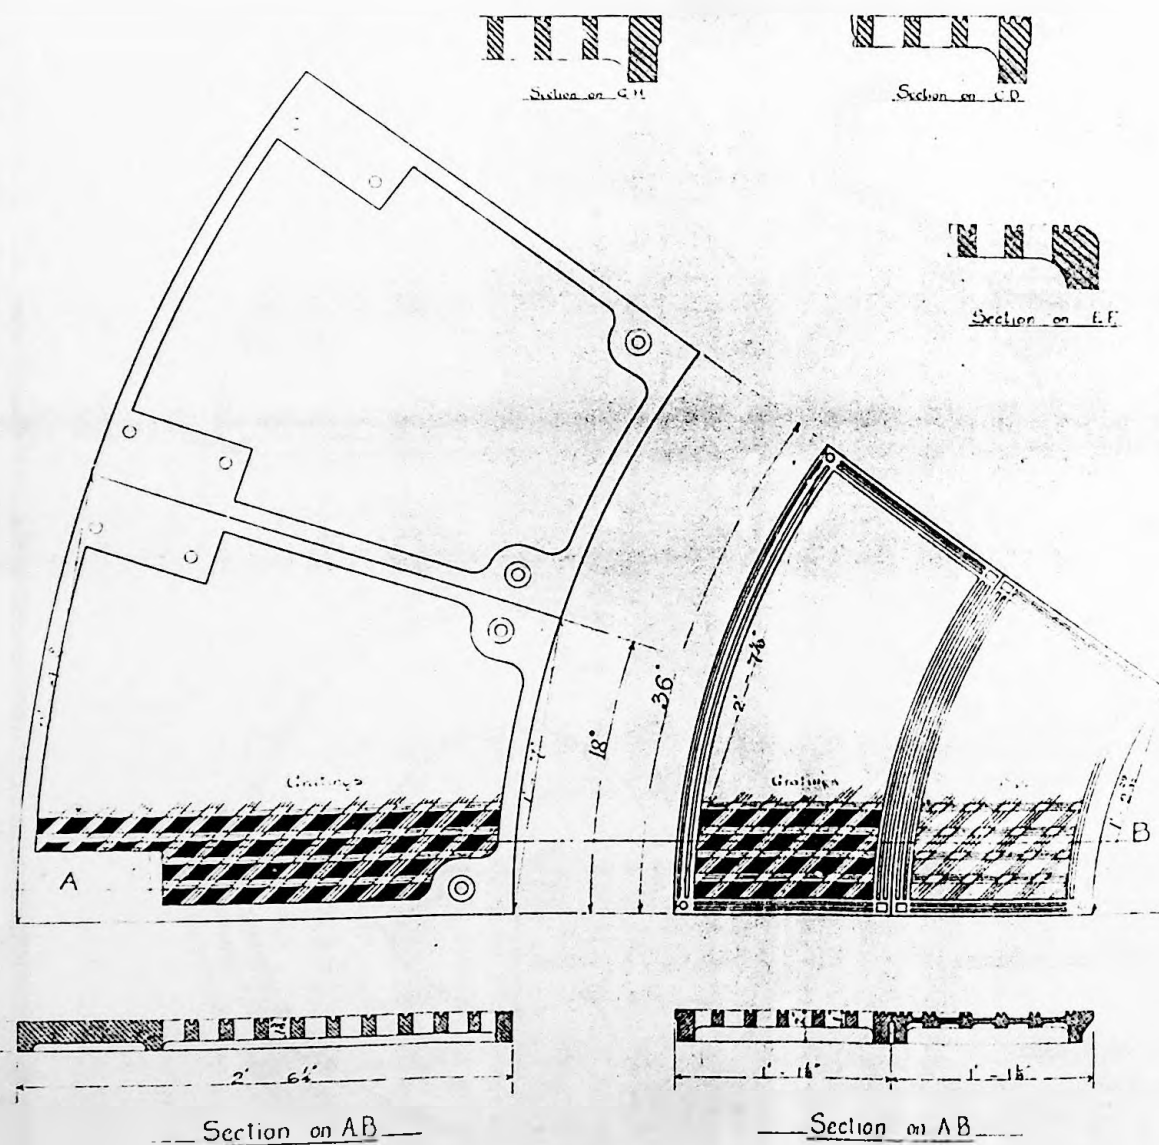
A

A

A

A

A



Plan of plates

Scale 1/4" = 1'

CAPE PEMBROKE LIGHTHOUSE.

DETAILS OF OUTSIDE GALLERY PLATES AND WELL HOLE

Scale 3/4" = 1'

96/14

DRAWING NO. 4255

A1

08

A1

A2

A3

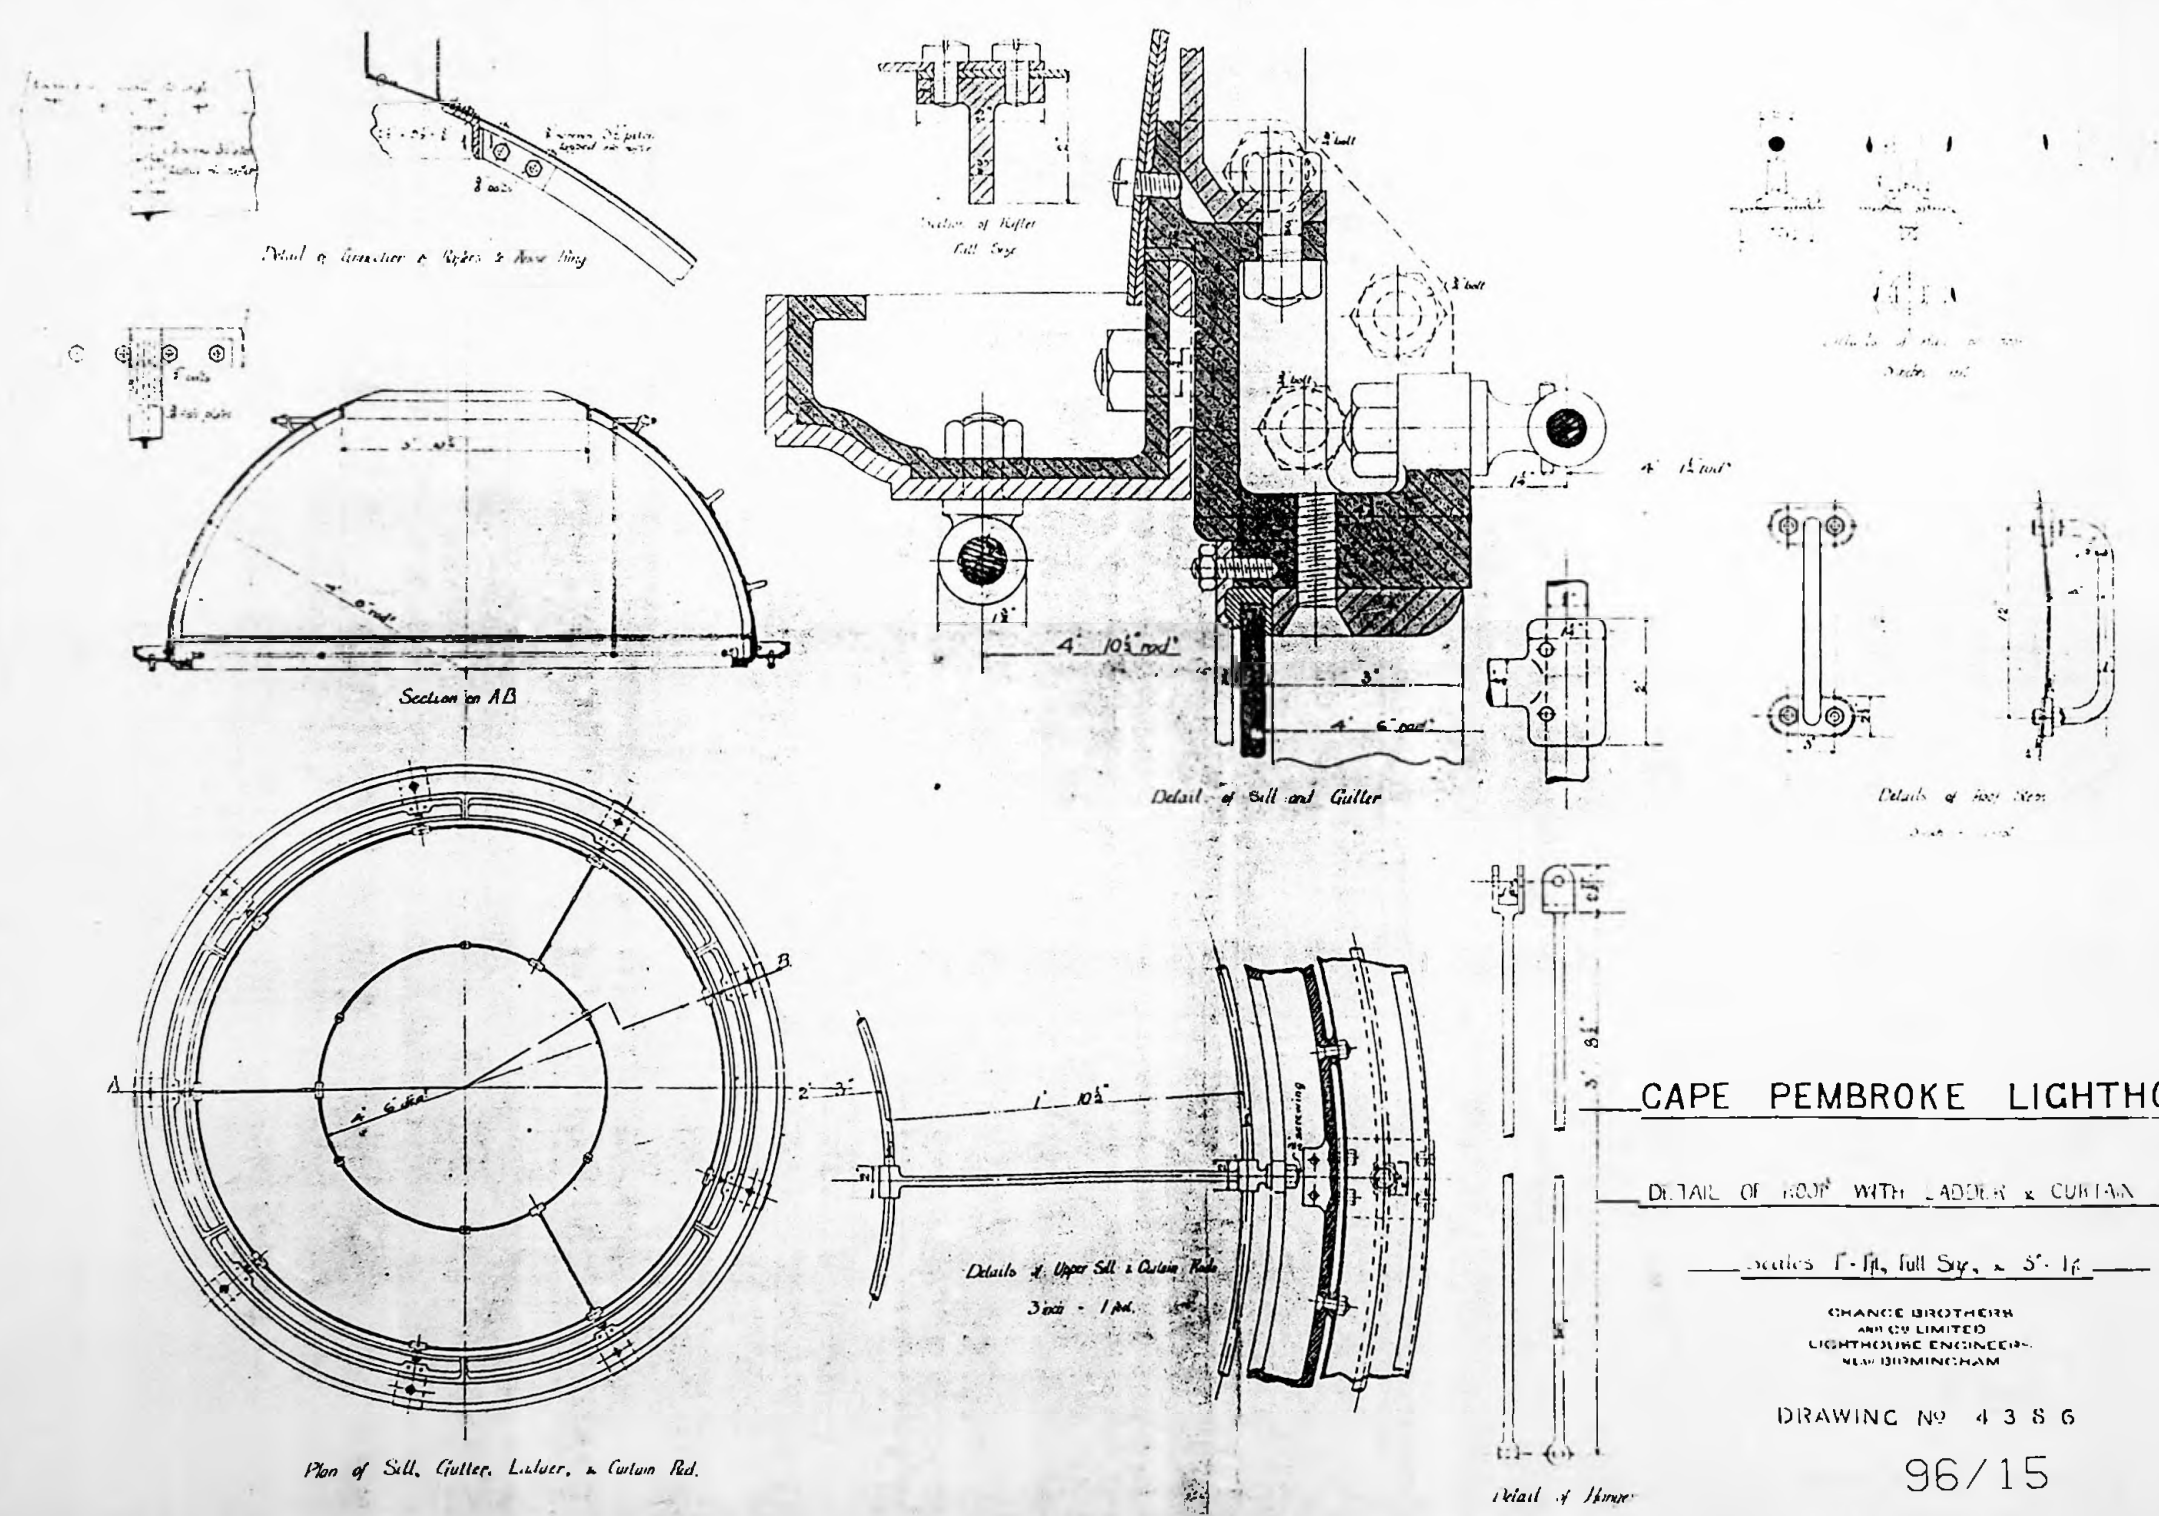
A4

A4

A3

A2

A1



A1

A2

A3

 
A4

A4

A3

A2

A1



NEW TOWER PLATES CALLERY BRACKETS, STANDARDS & FLOORS

Scale 3 inch - 1 foot

96 / 16

CHANCE BROTHERS
AND CO LIMITED
LIGHTHOUSE ENGINEERS
NEAR BIRMINGHAM

DRAWING NO 4 2 S 4

16 Aug 1958
O.G. Johnson

DRAWING NO 4 2 8 6

A0

A1

A2

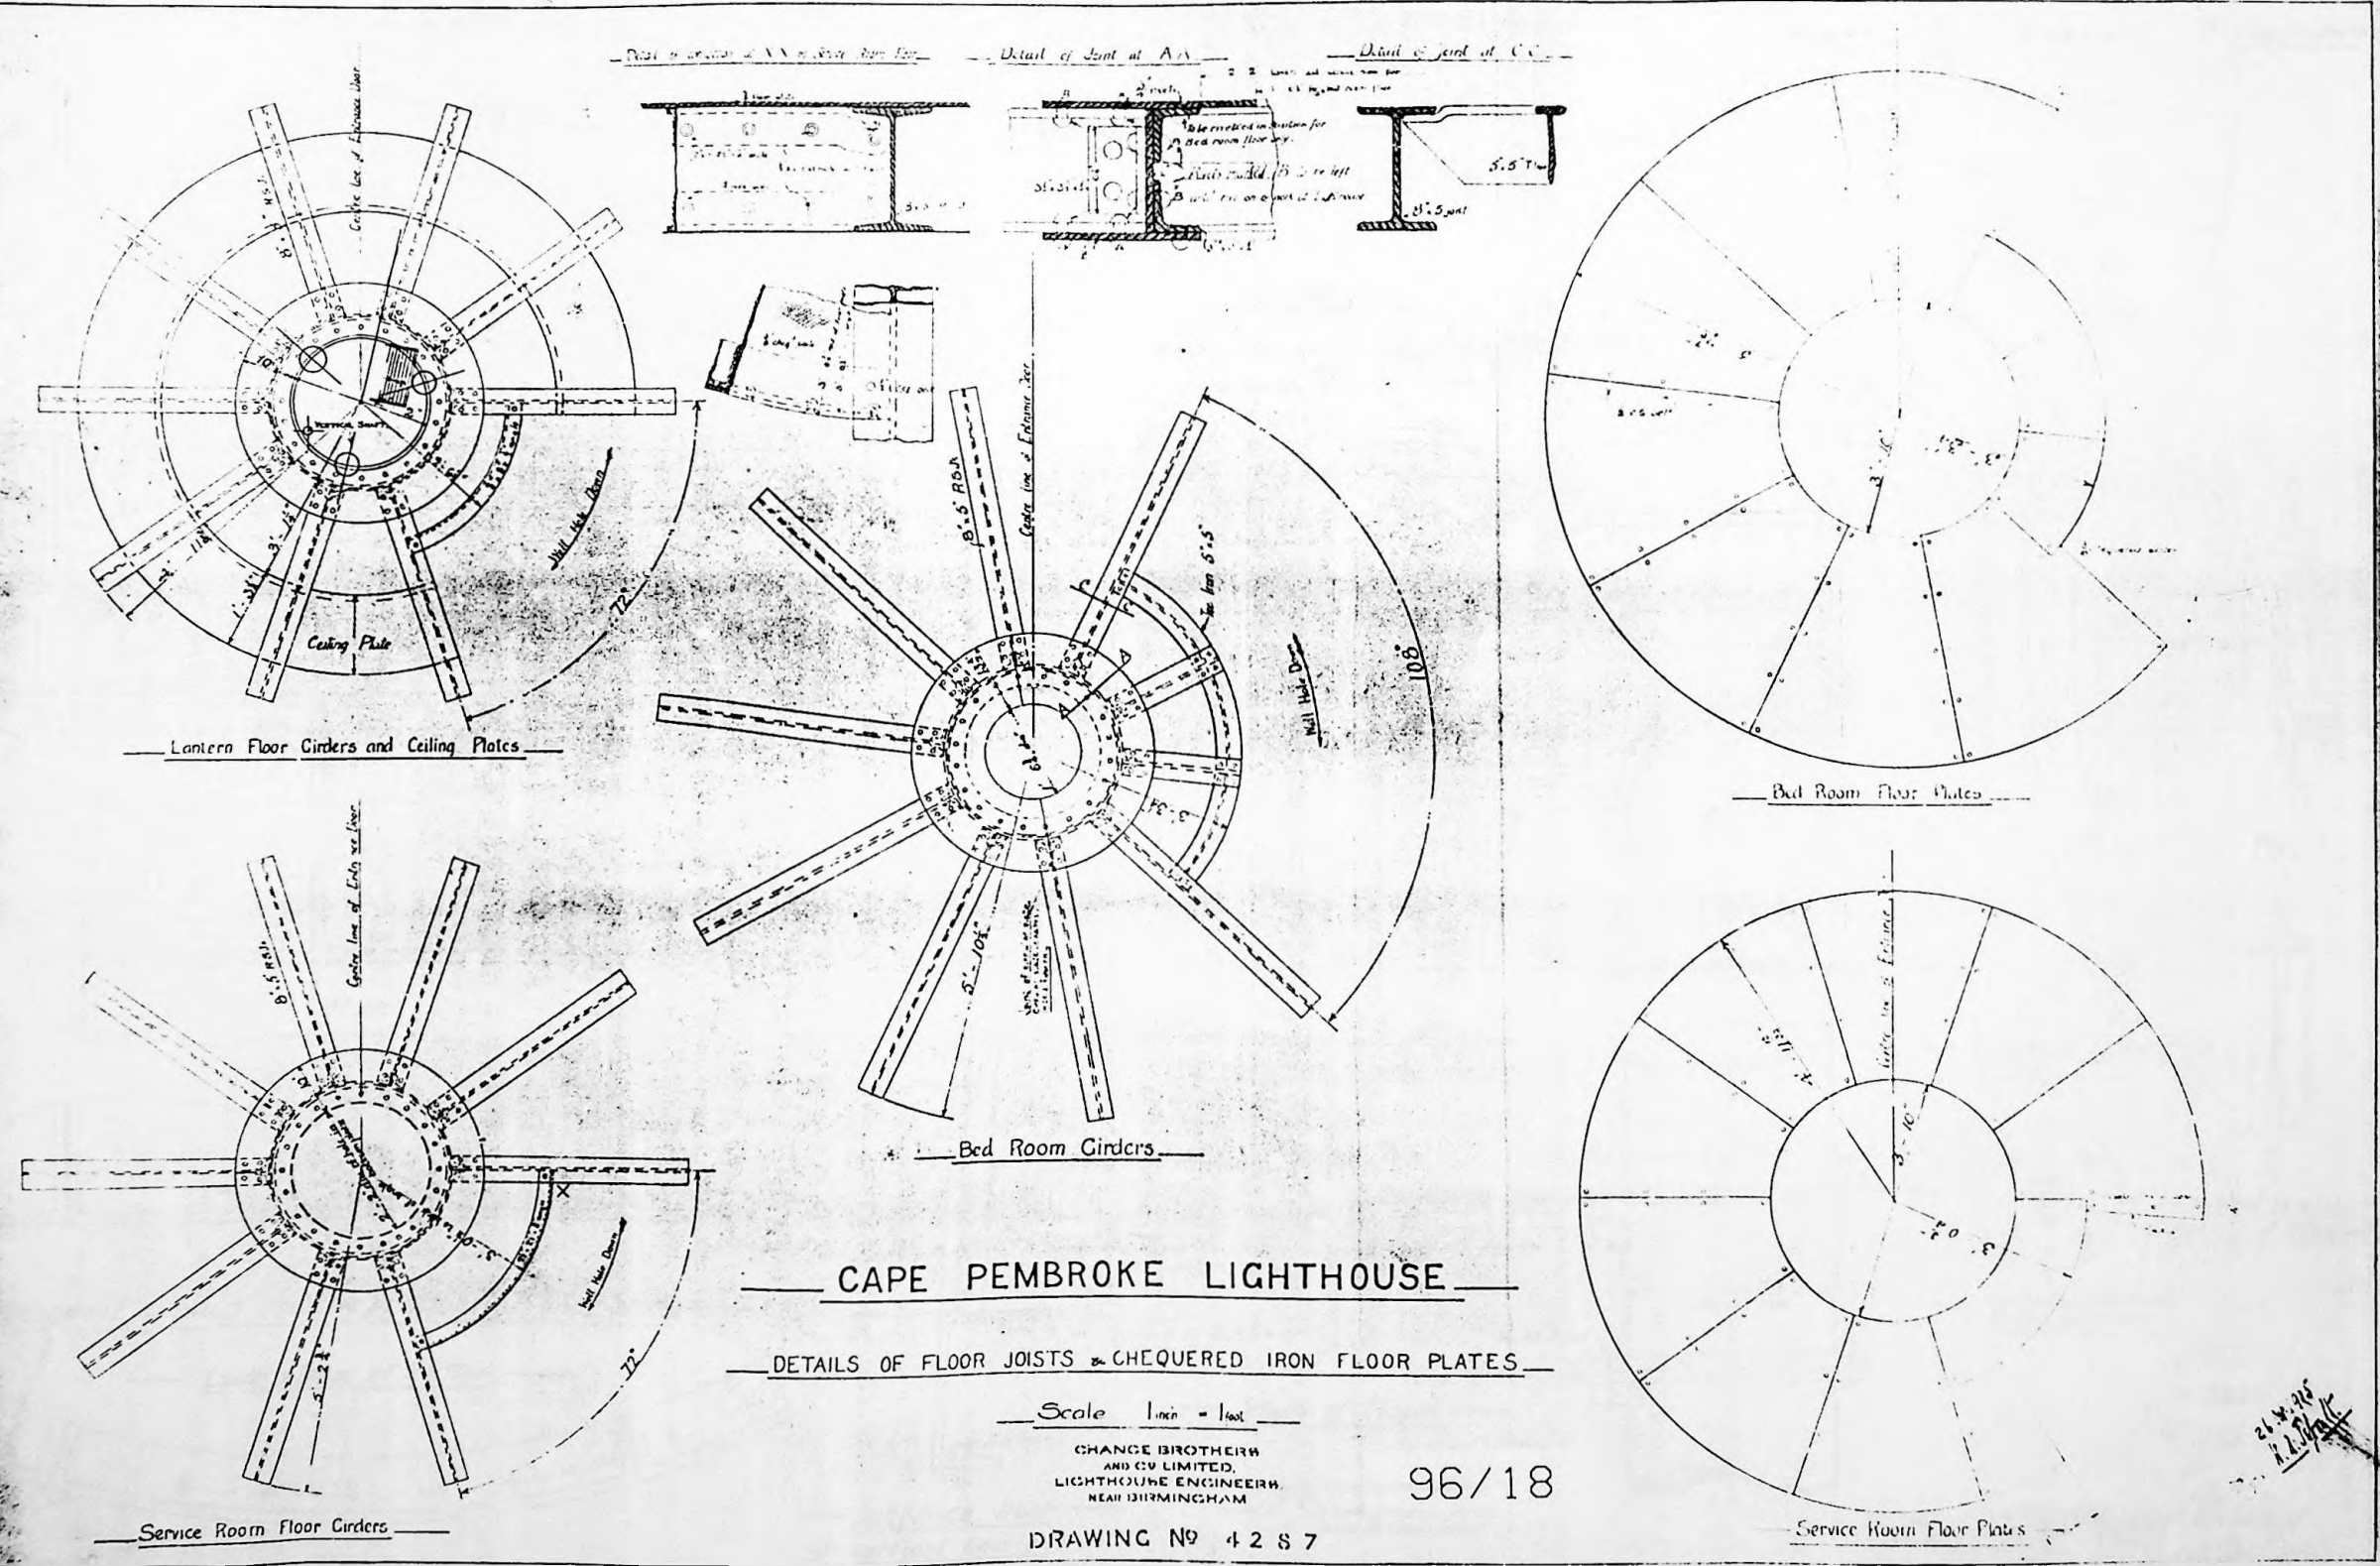
A3

A4

A3

A2

A1



A1

A2

A3

A4

A4

A3

A2

A1

A1

A2

A3

A4

A4

A3

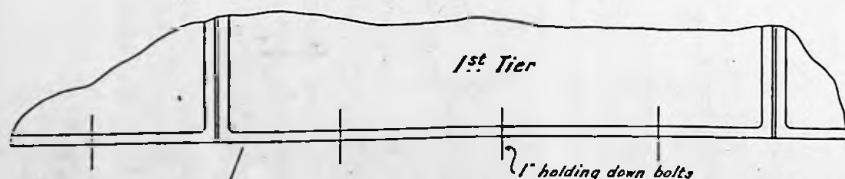
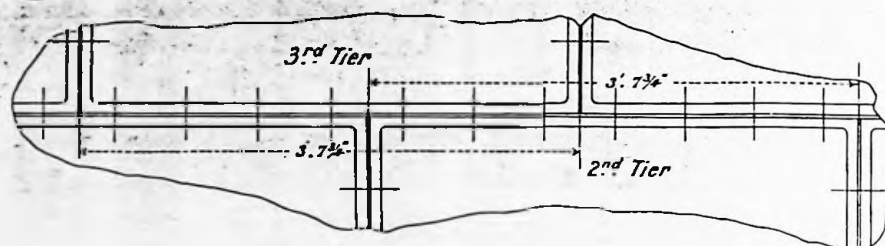
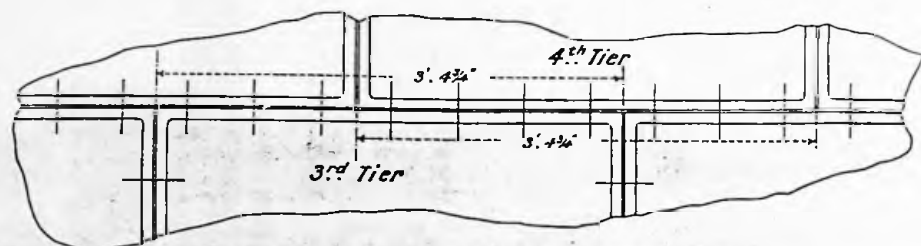
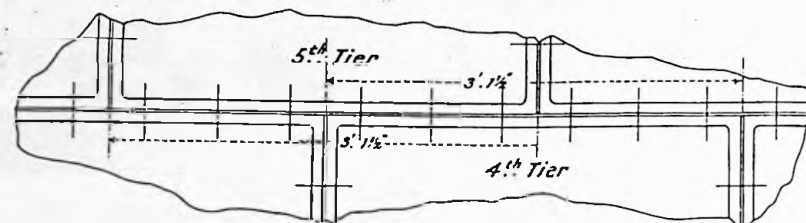
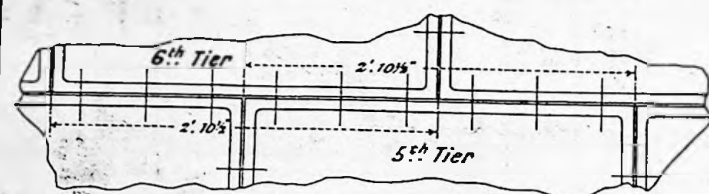
A2

FALKLAND ISLANDS

CAPE PEMBROKE LIGHTHOUSE


CONSTRUCTIONAL DETAILS OF TOWER

SCALE 1 1/2 INCHES TO A FOOT




Development showing relative positions of Tower plates

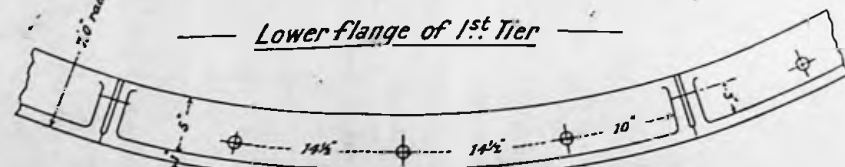
Lower flange of 1st Tier



Plan.

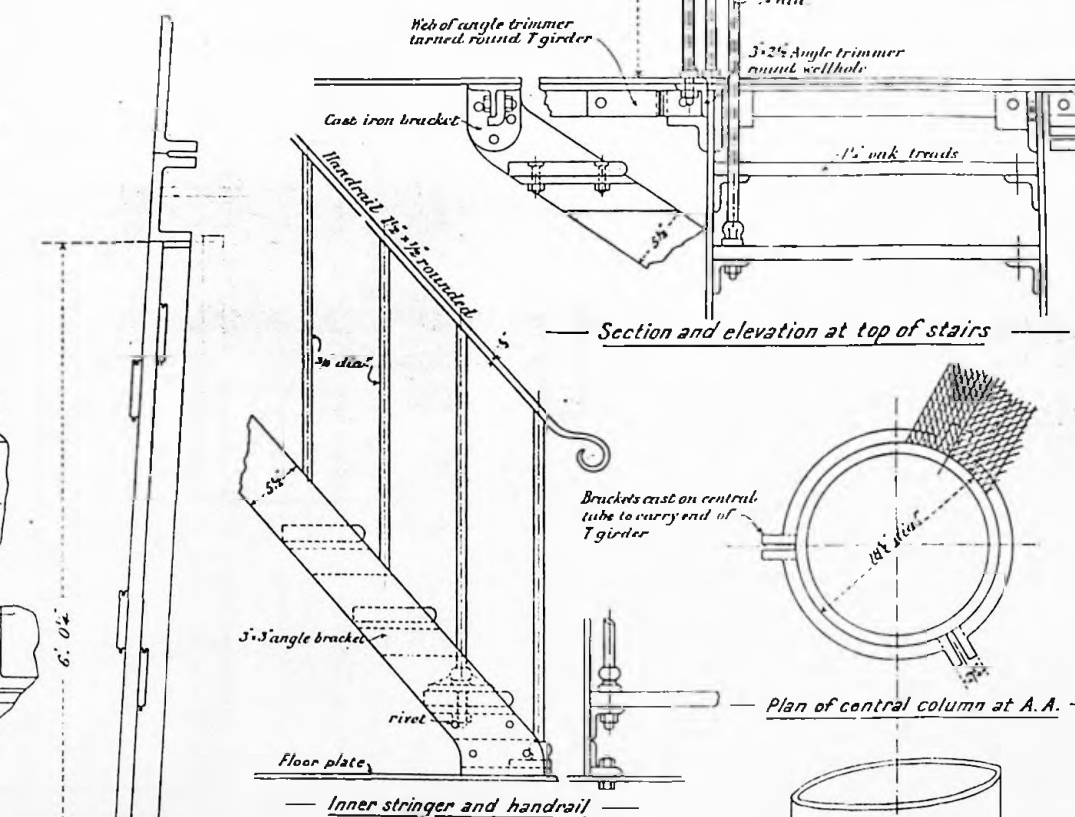

Section and elevation at top of stairs

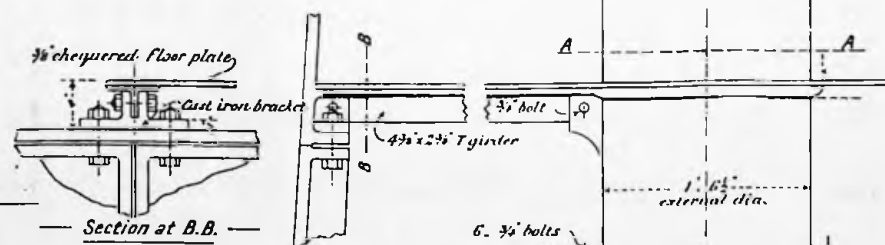


Section at B.B.

Details of Floors




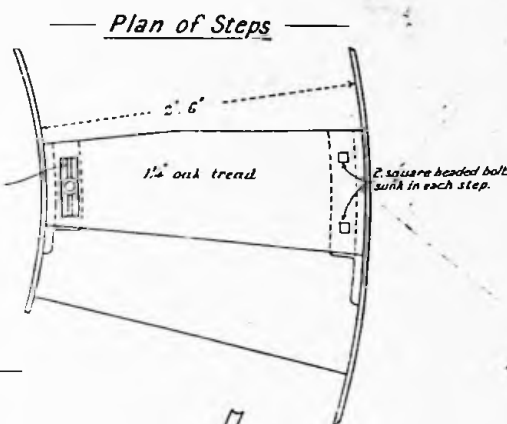Entrance Door
Vertical Section.




Plan of Steps

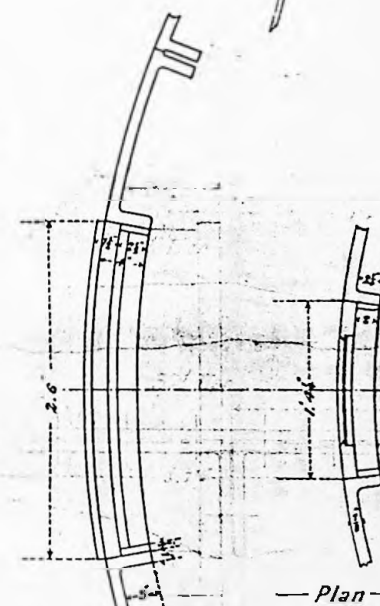Details of Stairs



Plan of central column at A.A.

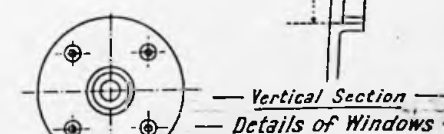Entrance Door
Plan



Vertical Section
Details of Windows

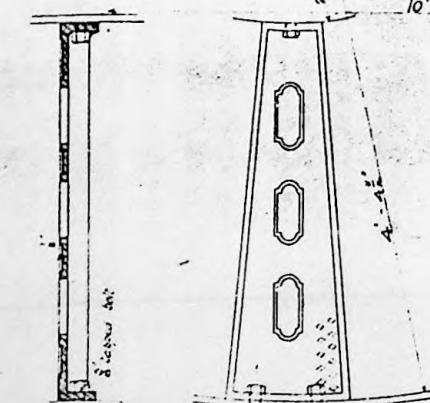
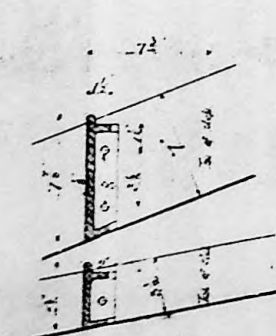
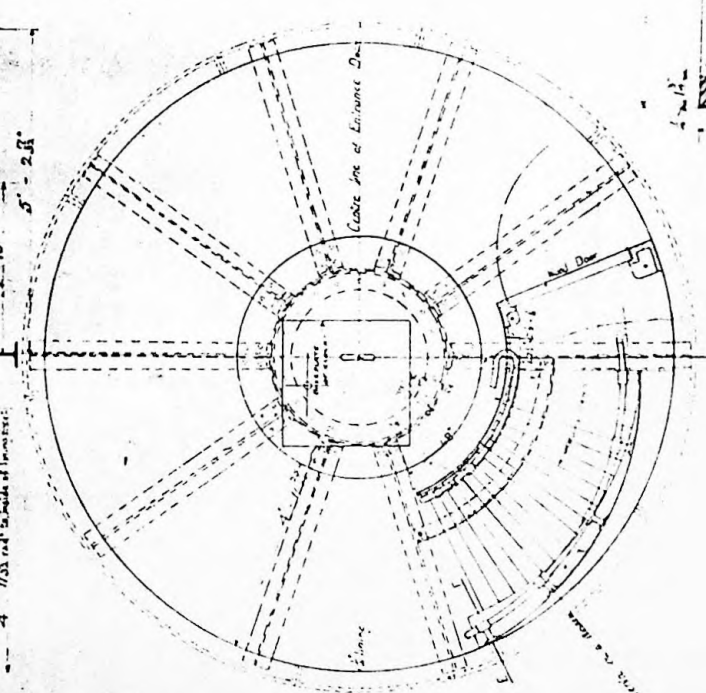
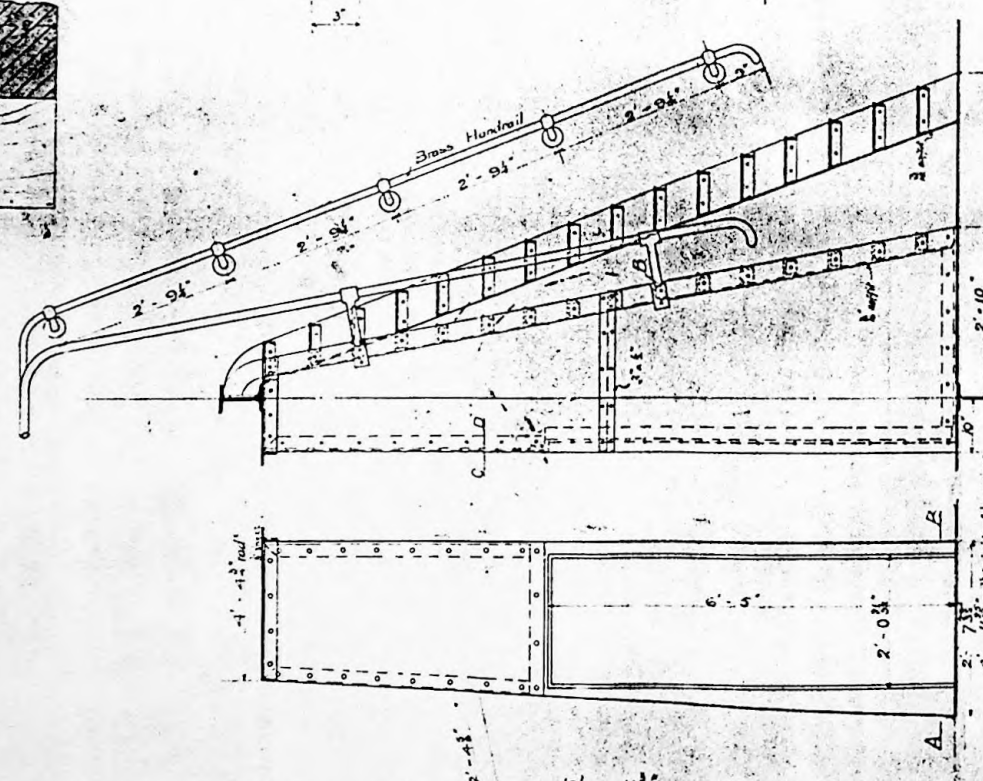
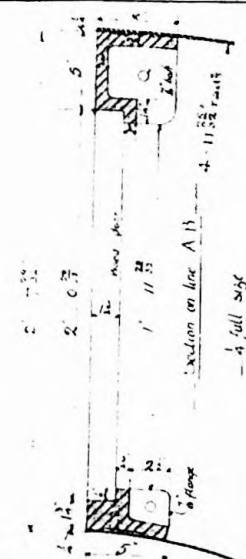
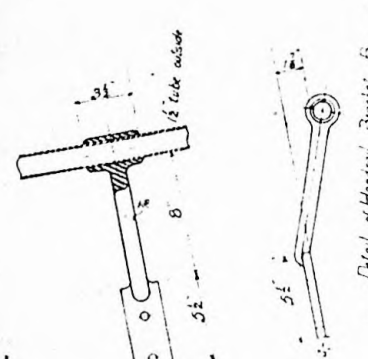
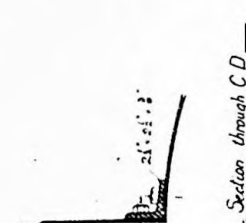
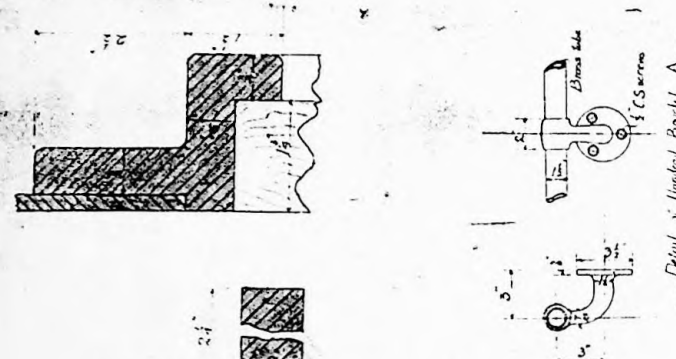
Plan of Socket for
Vertical Shaft.



8661

96/19

J. Wallhead
17 April 1905



CAPE PEMBROKE LIGHTHOUSE.

DETAILS OF PARTITIONS & STAIRS IN SERVICE ROOM.

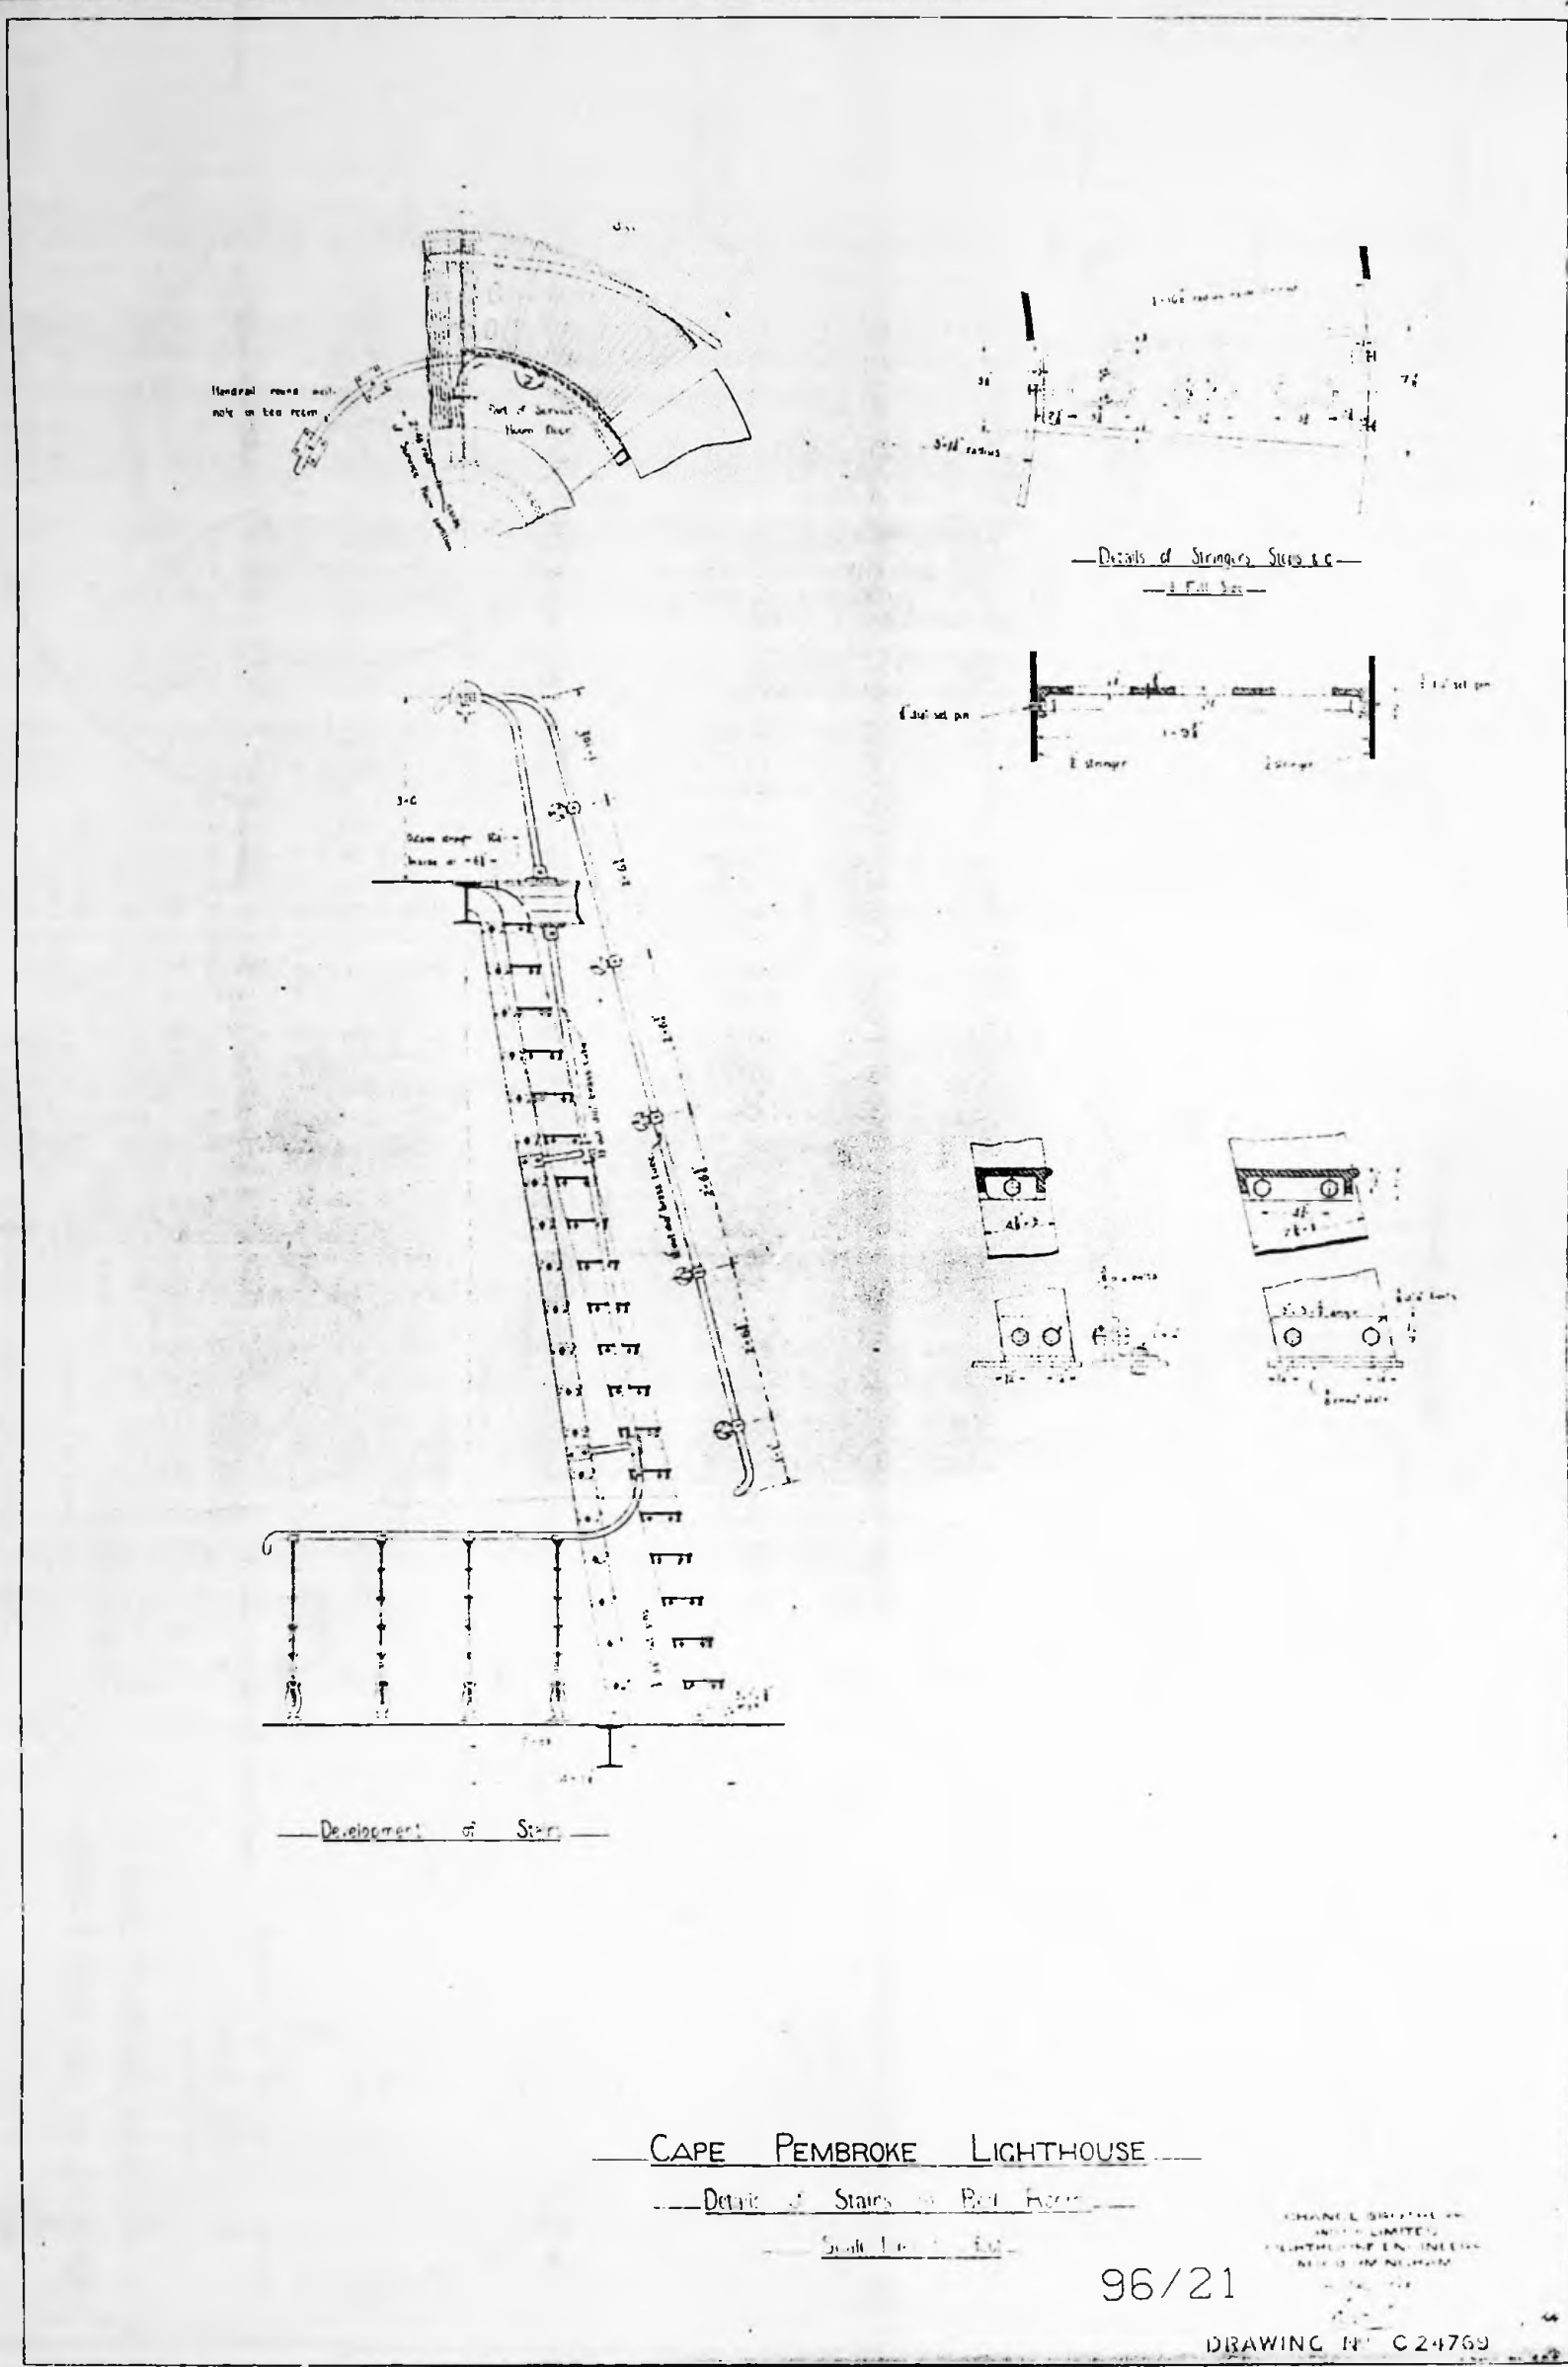
Scale 1" = 1ft & 3" = 1ft

96/20

CHANCE BROTHERS
AND CO LIMITED
LIGHTHOUSE ENGINEERS
NEW BIRMINGHAM

DRAWING NO 4289

24.11.1935
R. D. White



CAPE PEMBROKE LIGHTHOUSE

Detail of Stairs to 3rd Floor

Scale 1/4" = 1'-0"

96/21

DRAWING NO. C 24769

CHARLES BRIDGES & SONS LIMITED
 ARCHITECTS & ENGINEERS
 11, COLLEGE STREET, LONDON, W.C.1

A0

A1

A2

A3

A4

A5

A6

A7

A8

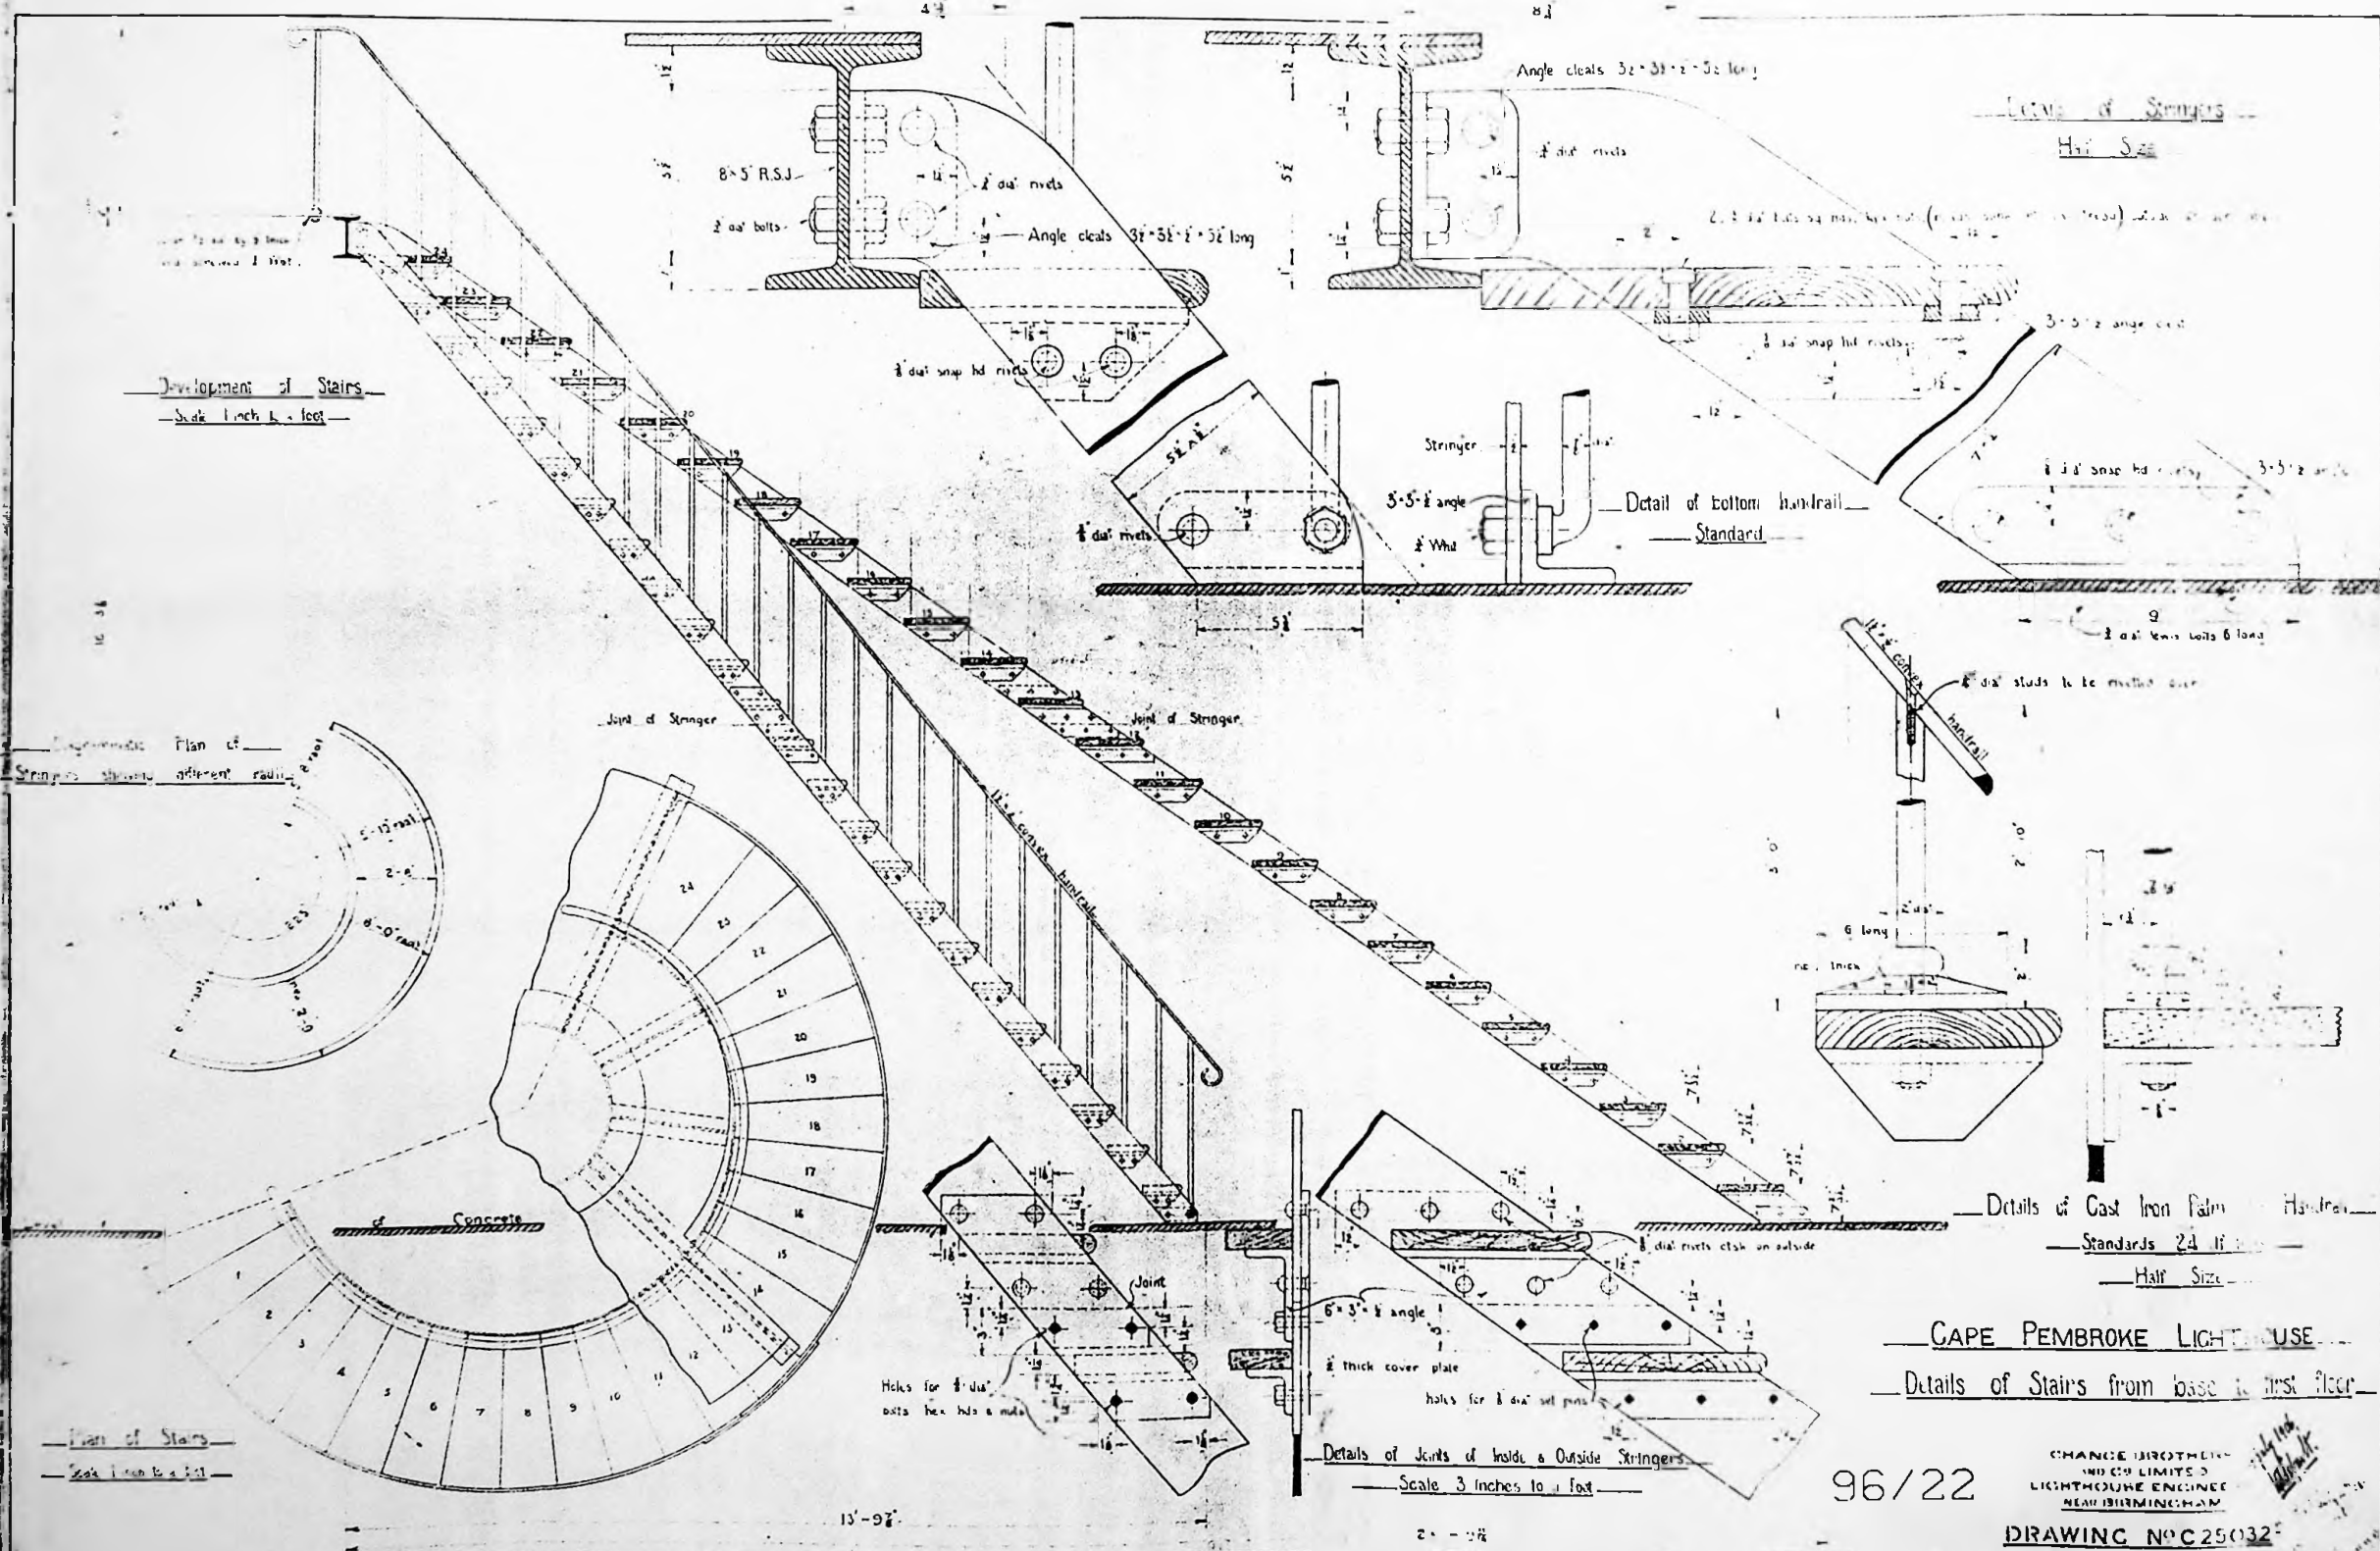
A9

A10

A11

A12

A13





96/22

CHANCE BROTHERS
LIMITED
LIGHTHOUSE ENGINEERS
NEAR BIRMINGHAM
DRAWING NO C25032

Cape Pembroke Lighthouse.
New Store Closet for Entrance Room.

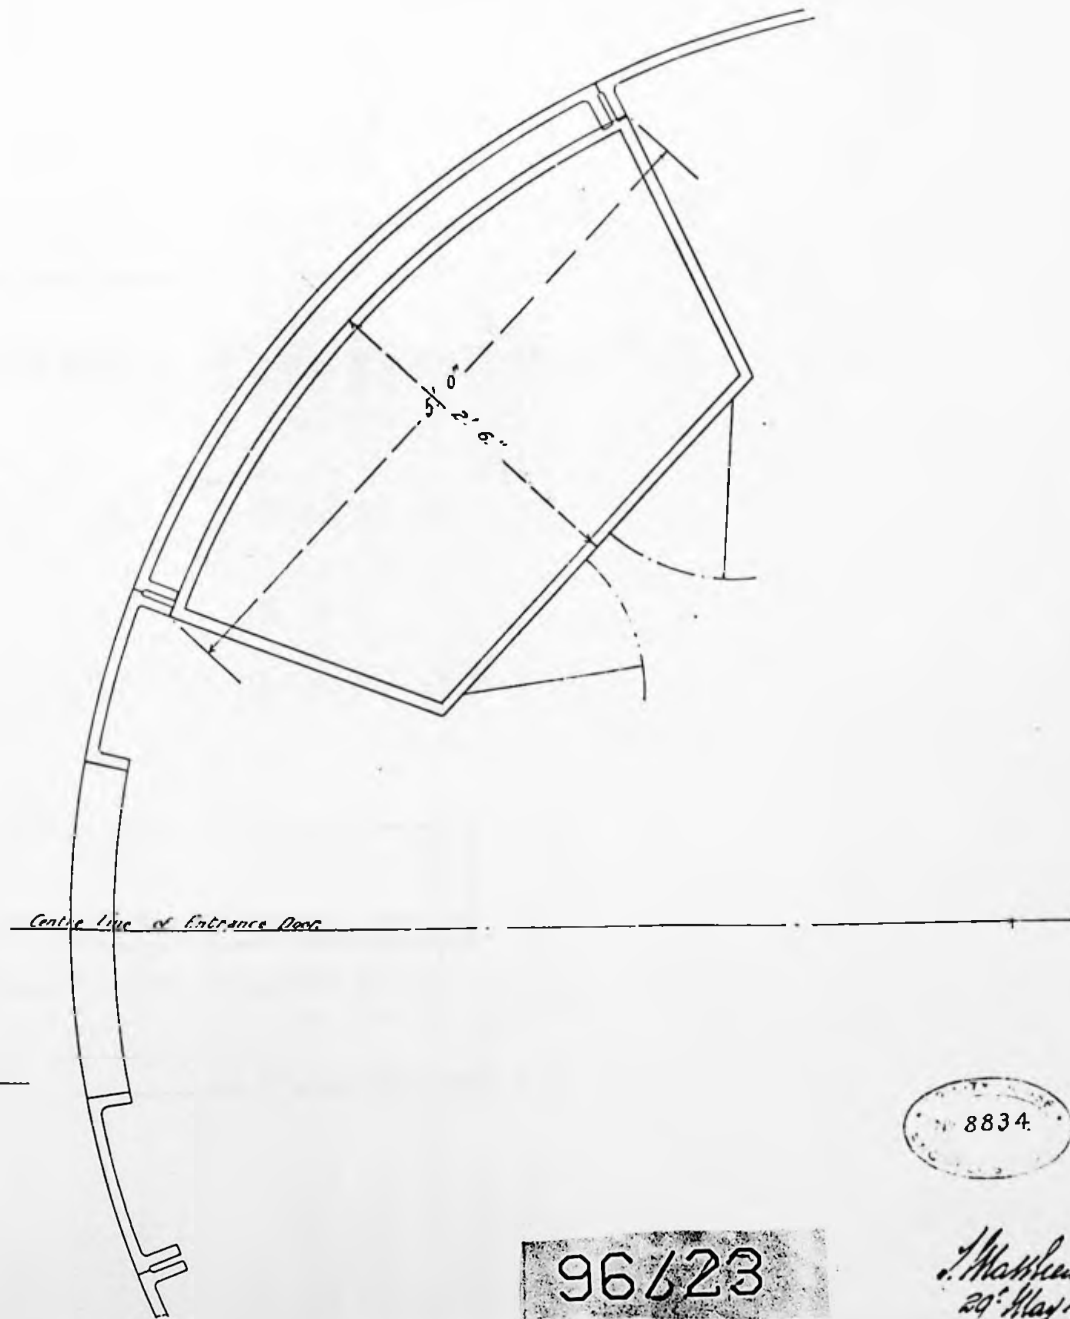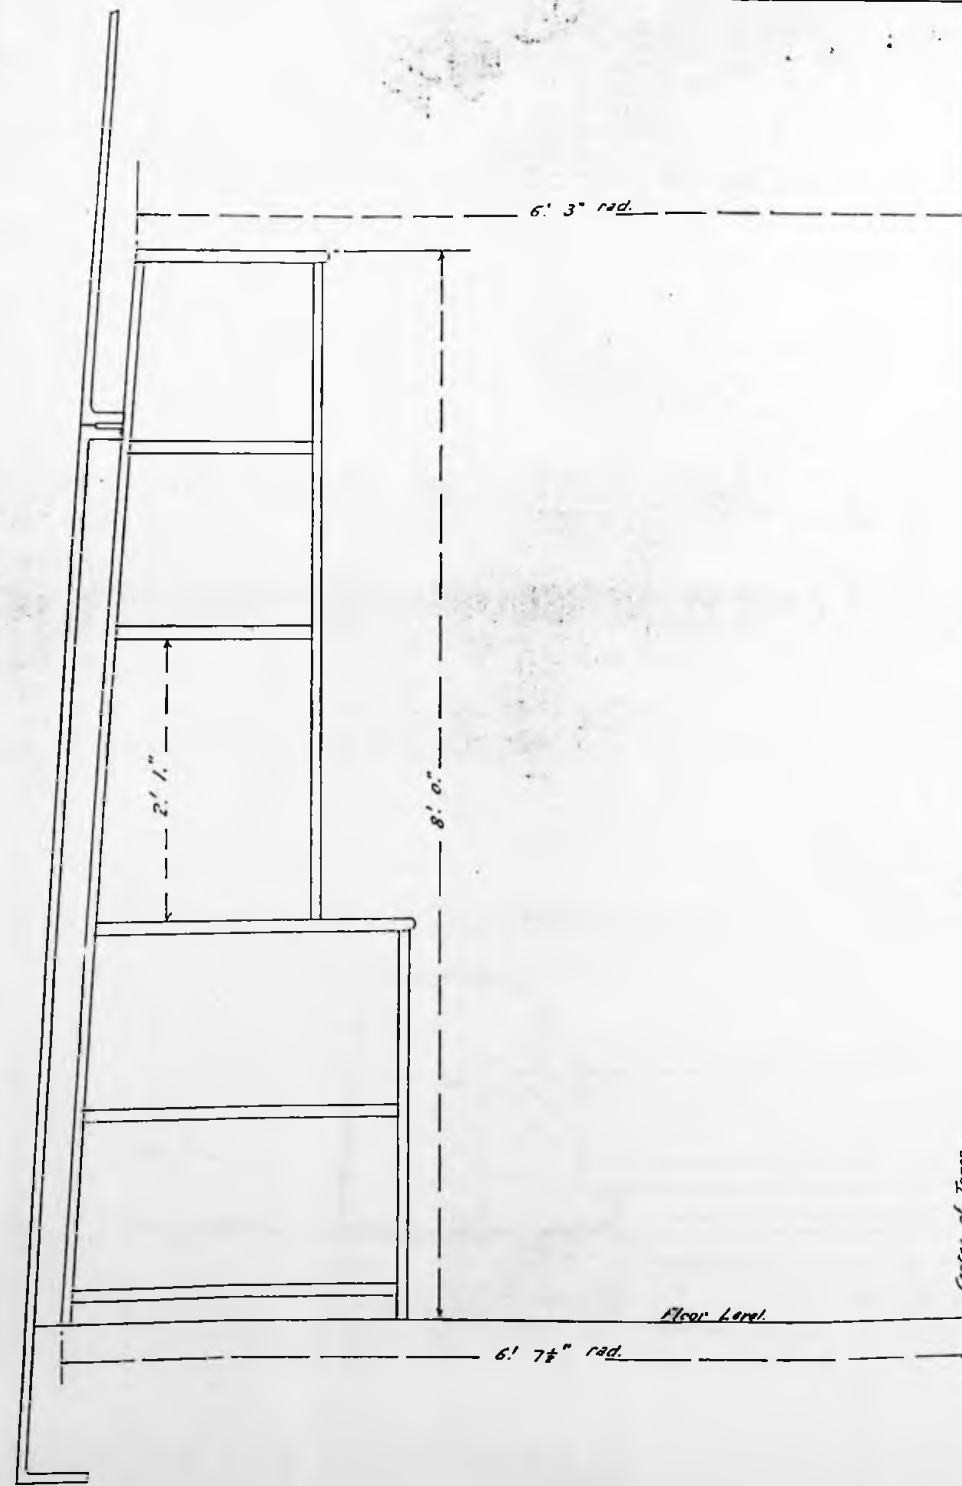— Scale 1/2 inch to 1 foot. —



8834.

96623

J. Matthews
 29 May 1906.

A2

A3

A4

A4

A3

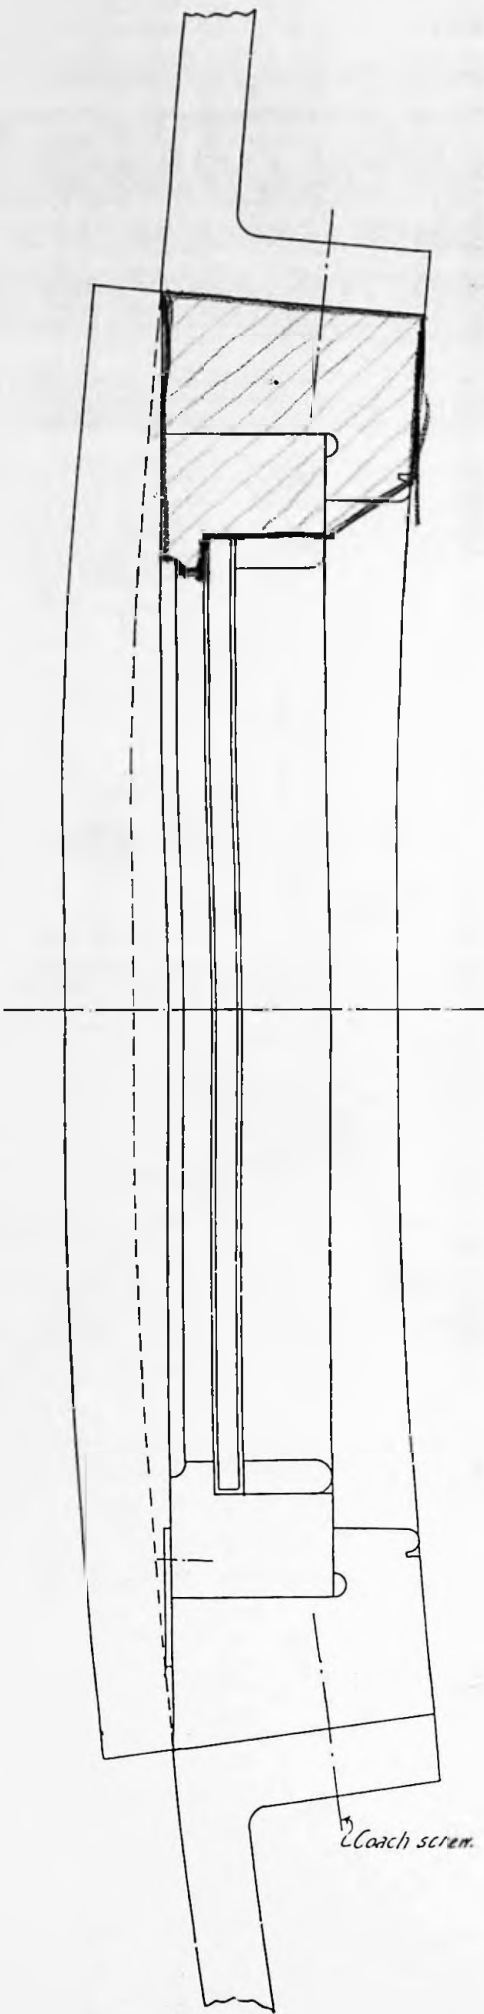
A2

A1


CAPE PEMBROKE LIGHTHOUSE

New Windows for Tower.

Full Size.



Plan.

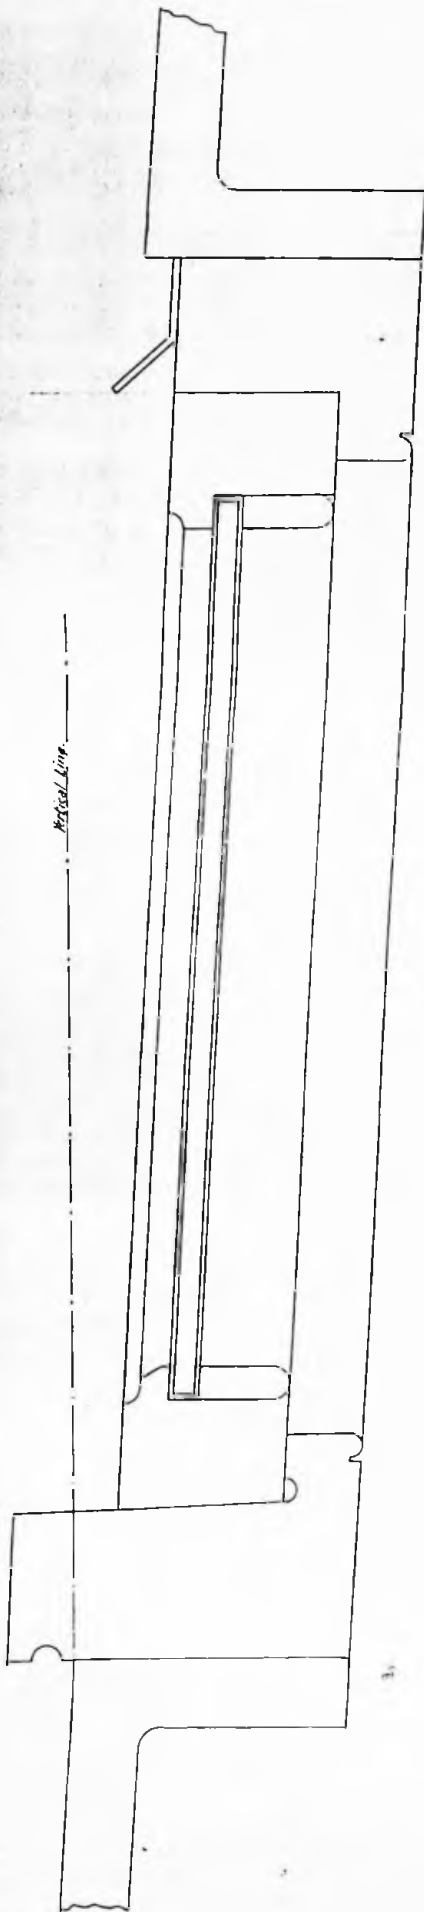


Vertical Section

96/24

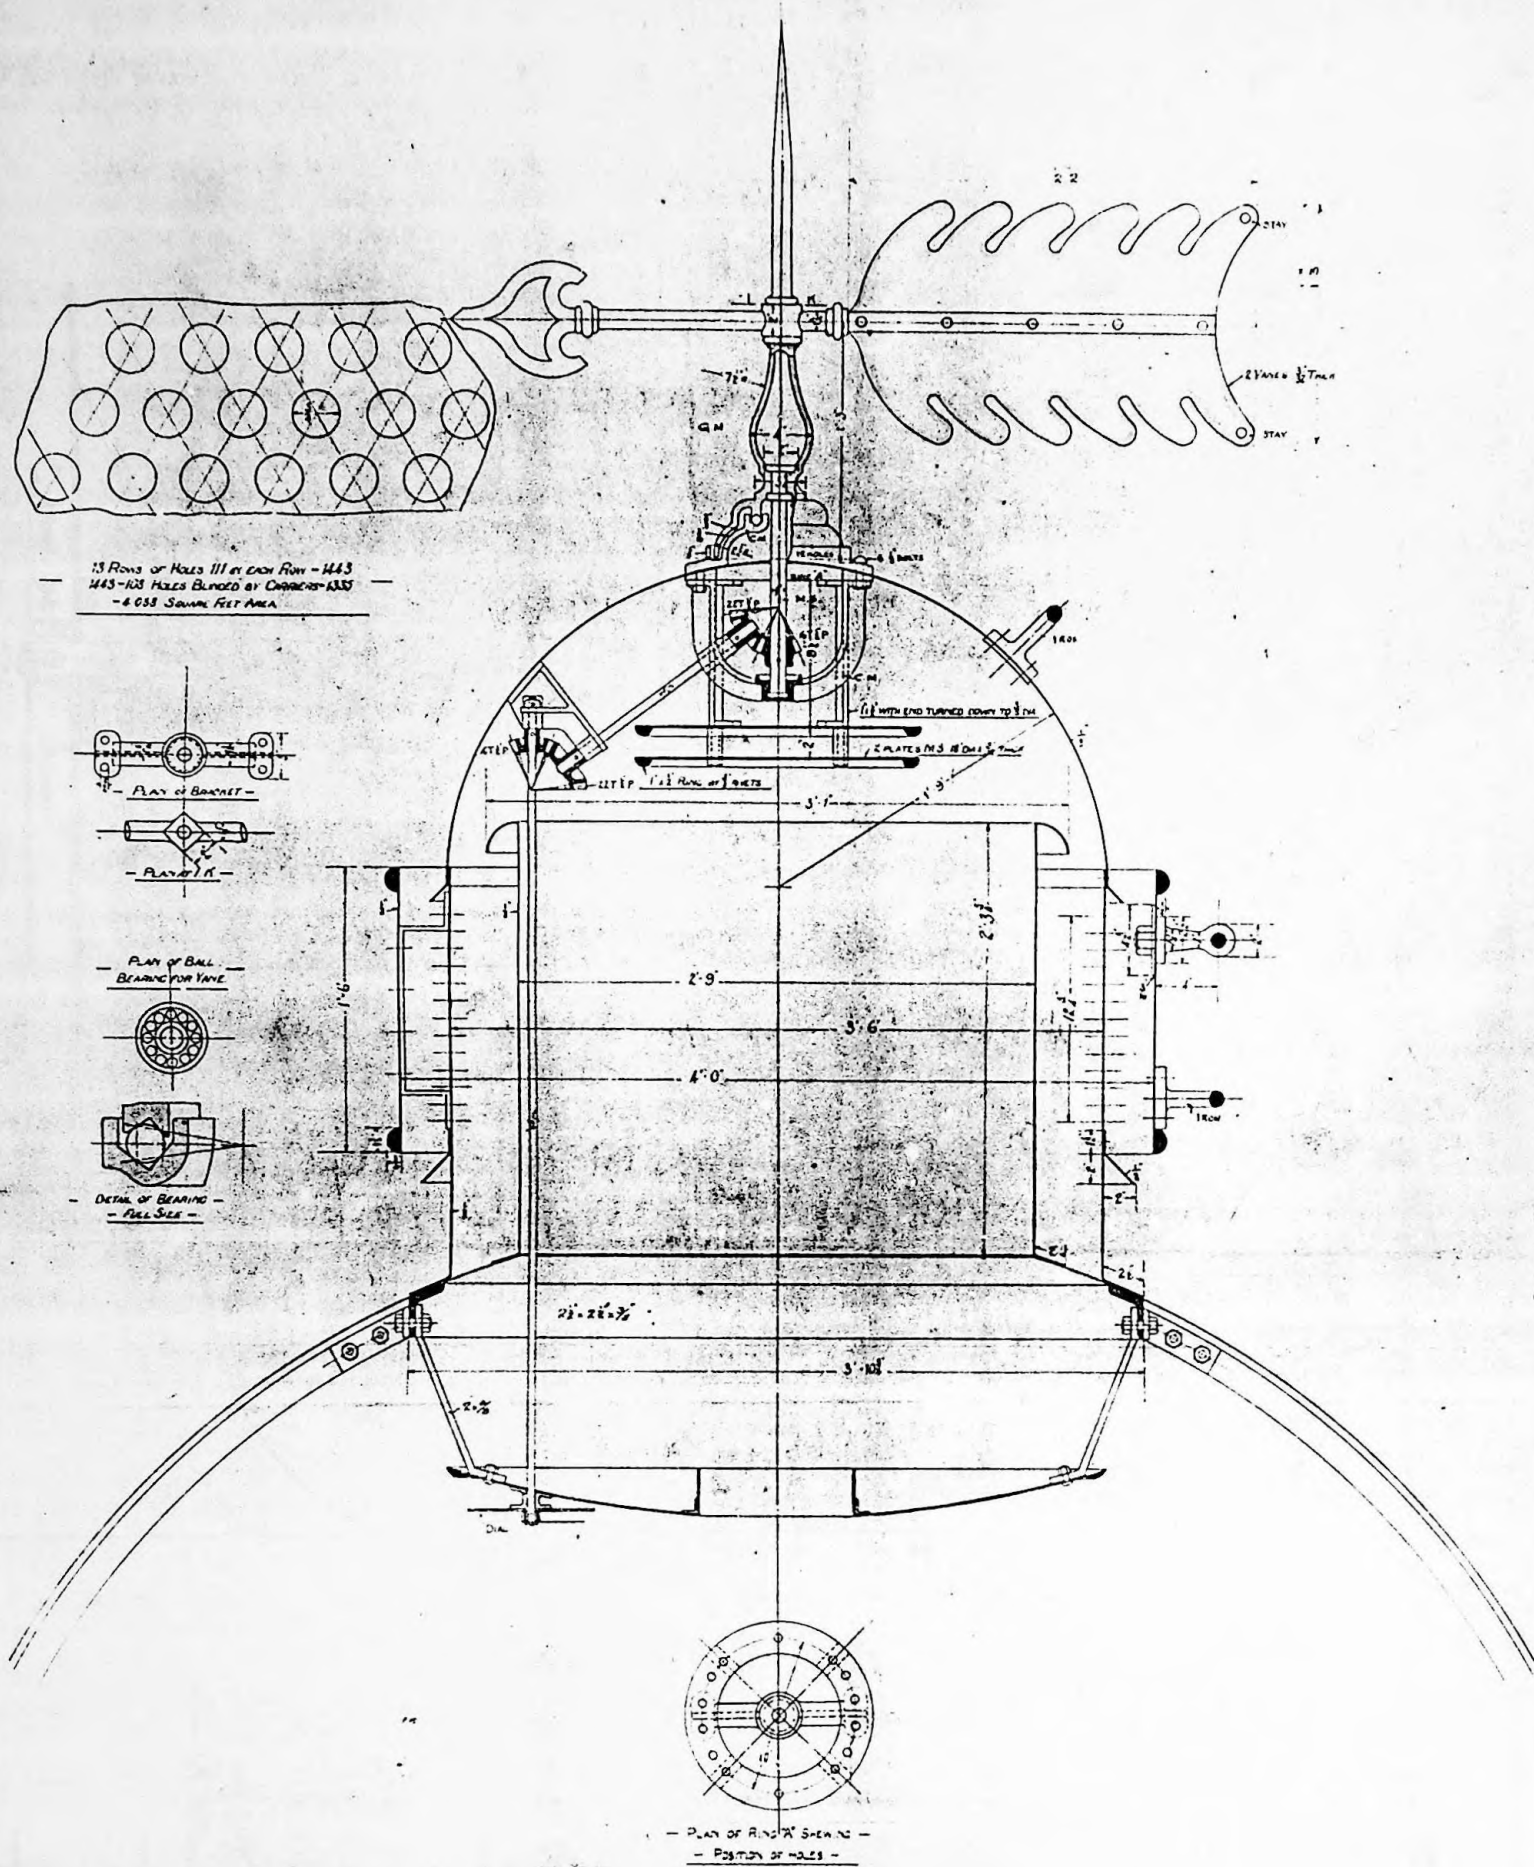J. Matthews
25 May 1906.





CAPE PEMBROKE LIGHTHOUSE.

DETAILS OF ROOF VENTILATOR

SCALE 3 - 1 FOOT

CHANCE BROTHERS
AND CO LIMITED
LIGHTHOUSE ENGINEERS
NEAR BIRMINGHAM

DRAWING No 4388

96/25

A0

A0

A1

A1

A2

A2

A3

A3

A4

A4

A4

A4

A3

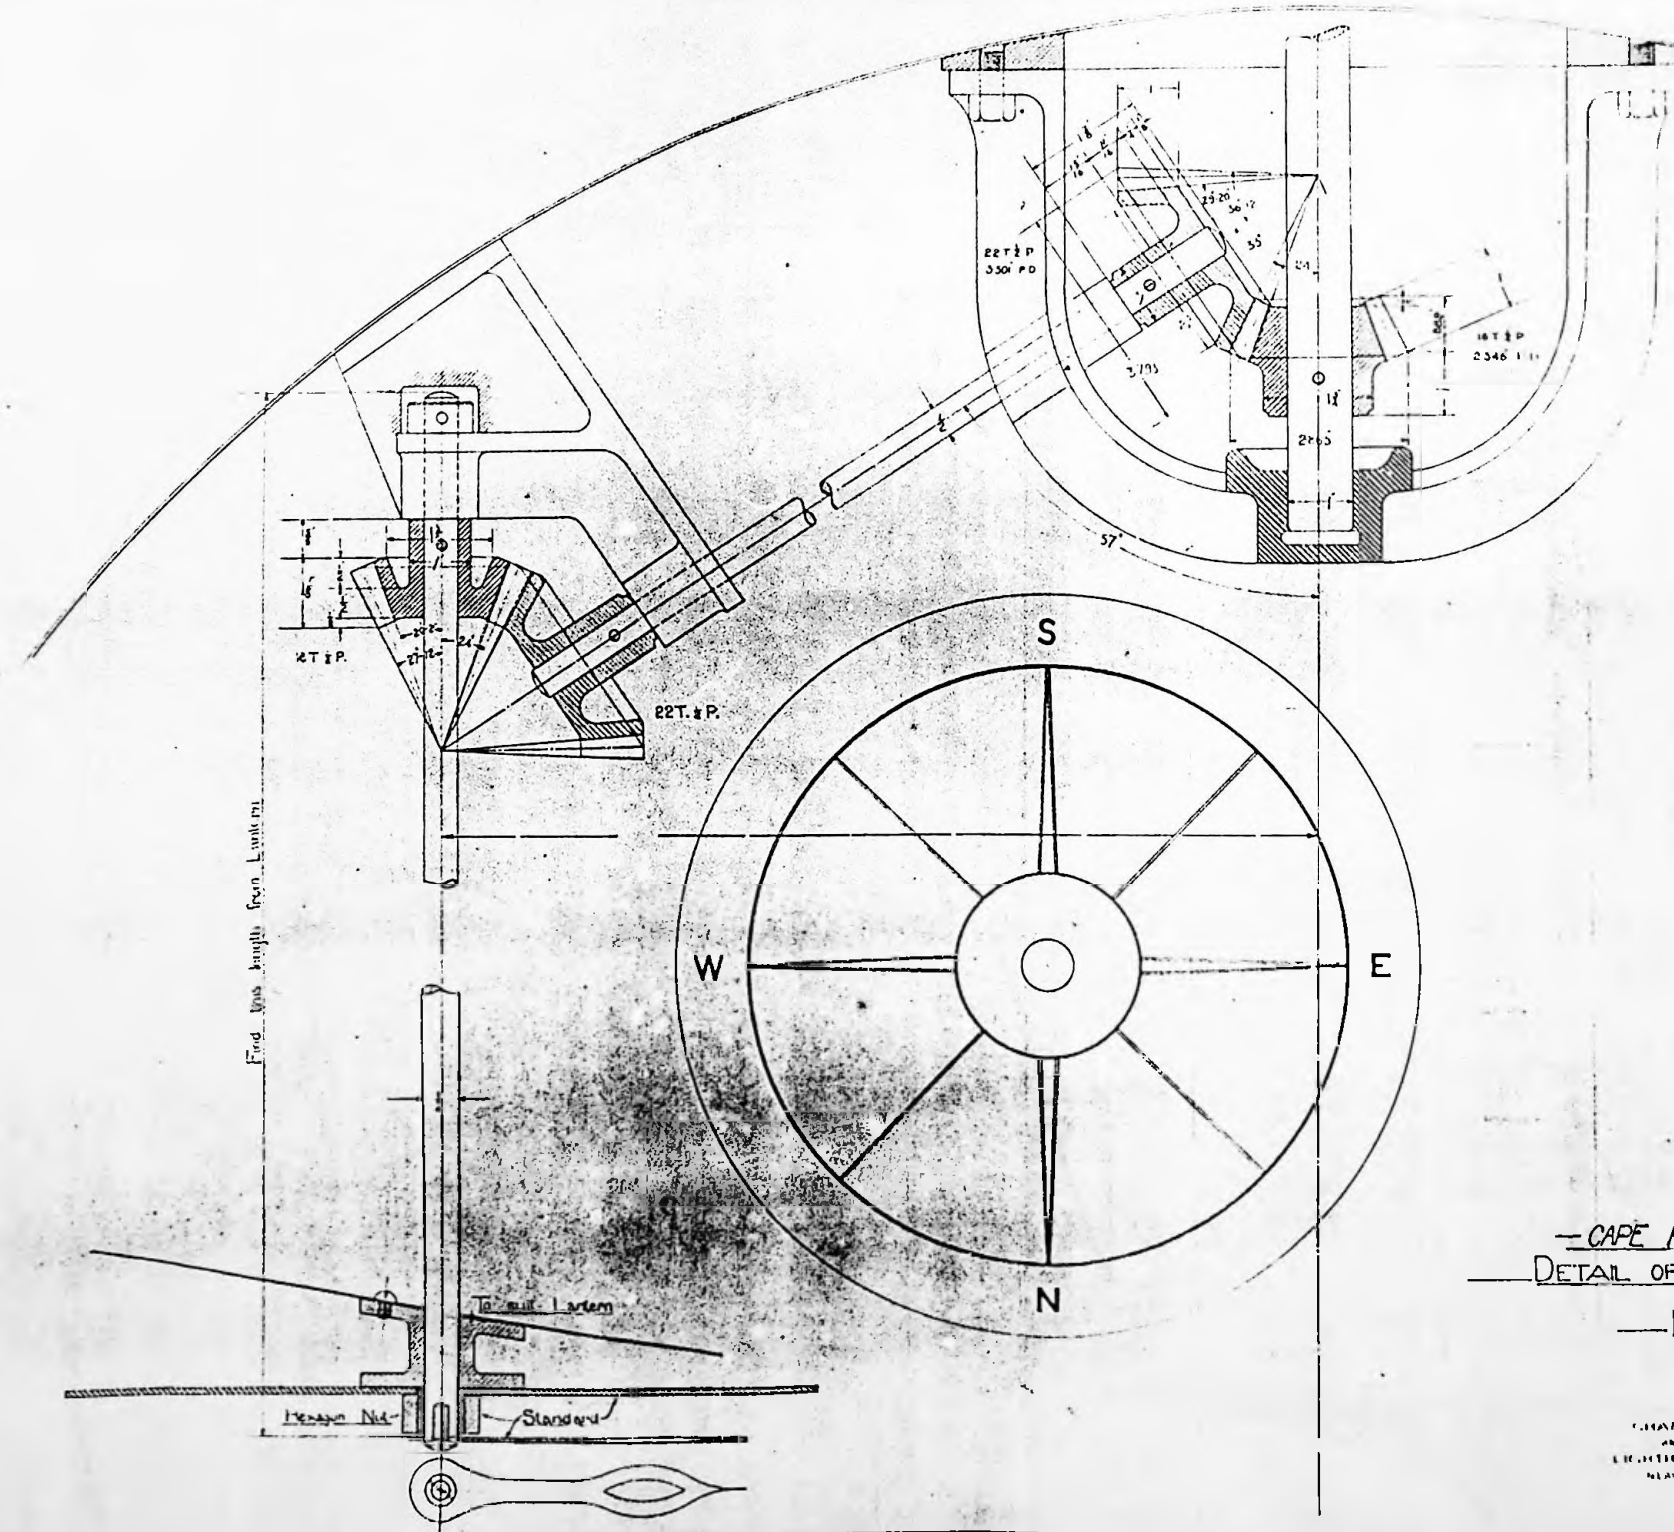
A3

A2

A2

A1

A1




96/26

C. H. BENTLEY & CO. LIMITED
MARINE ENGINEERS
NEWCASTLE-ON-TYNE

DRAWING NO 3333

P. 154

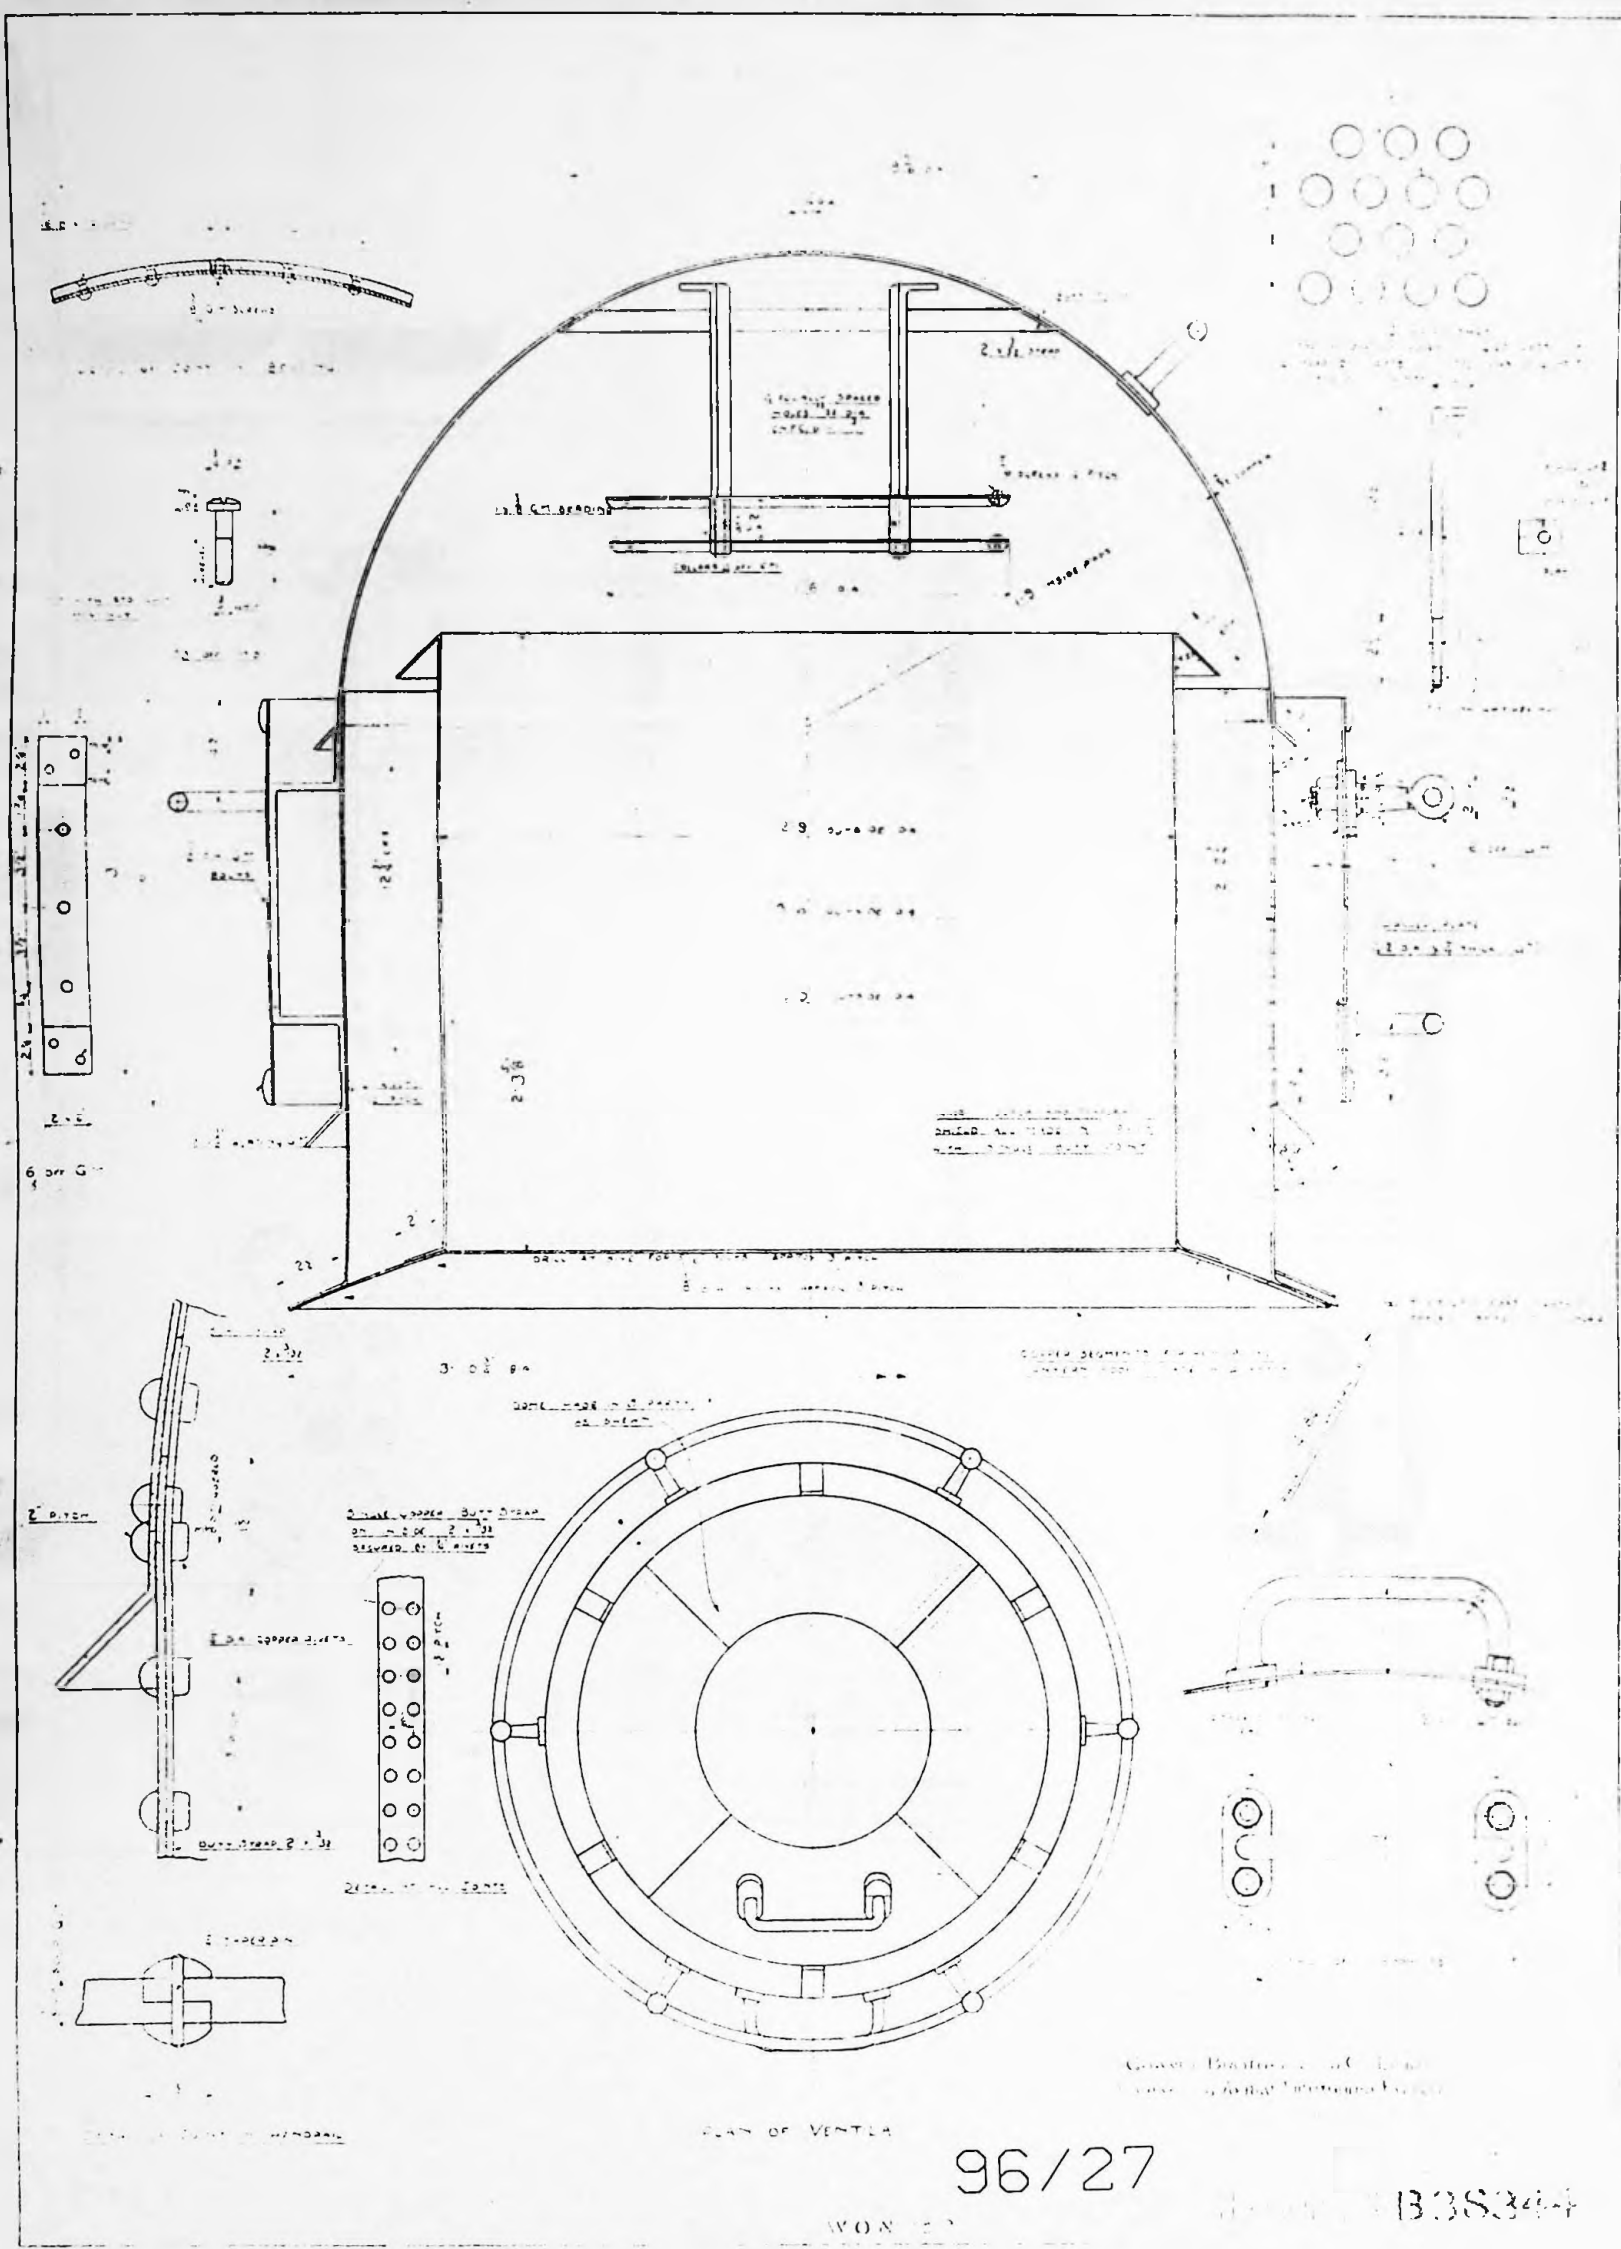
A1 A2 A3 A4



96/27 B3S344

A1 A2 A3 A4

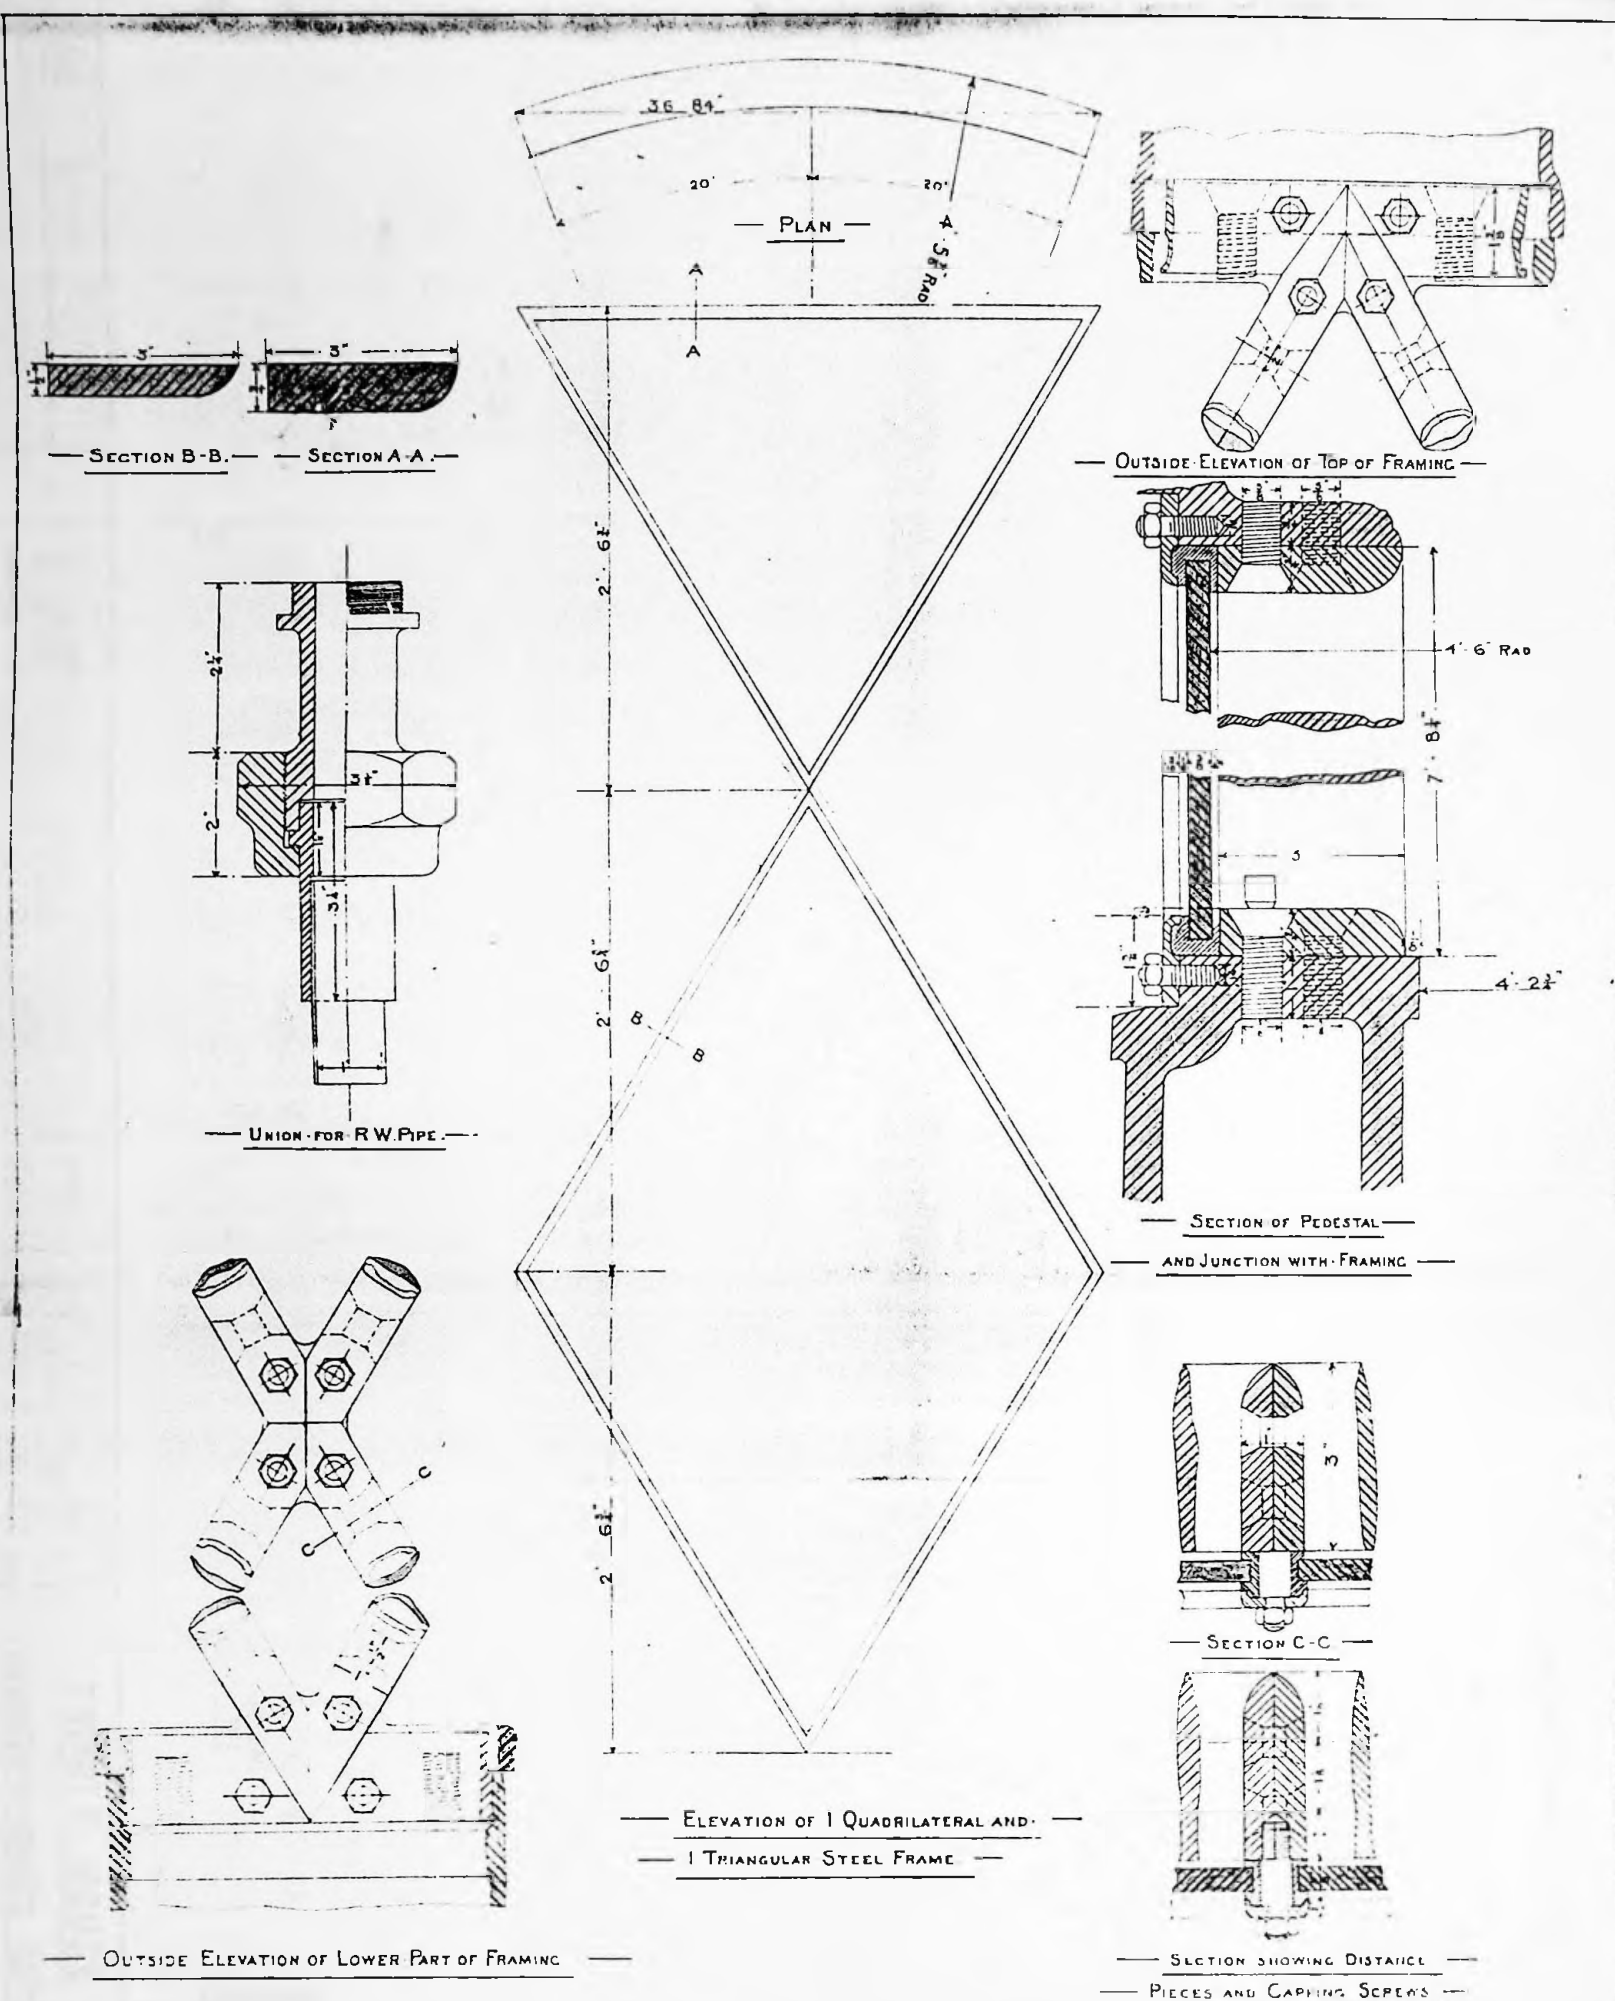A1 A2 A3 A4 A3 A2 A1 A0



— CAPE PEMBROKE LIGHTHOUSE —
— DETAIL OF STEEL HELICAL FRAMING AND CAPPING STRIPS. —
— SCALES 3" = 1' & FULL SIZE. —

A1 A2 A3 A4 A3 A2 A1 A0

DRG. No

37 1/2 ACROSS POINTS IN FLAT
37 1/2 ACROSS POINTS IN FLAT

36 5/8 ACROSS POINTS IN FLAT
36 5/8 ACROSS POINTS IN FLAT



96/30

SCALE	1 inch = 1 foot
AMENDMENTS	

LANTERN RAISE FOR CAPE PEMBERTON

TRINITY HOUSE
ENGINEER-IN-CHIEF'S DEPT.
TOWER HILL, LONDON, E.C.3.

DRG. No	F1/19
DRAWN	D. J. Jones
DATE	11.2.55
APPROVED	
DRG. No	61272

A1

A2

A3

A4

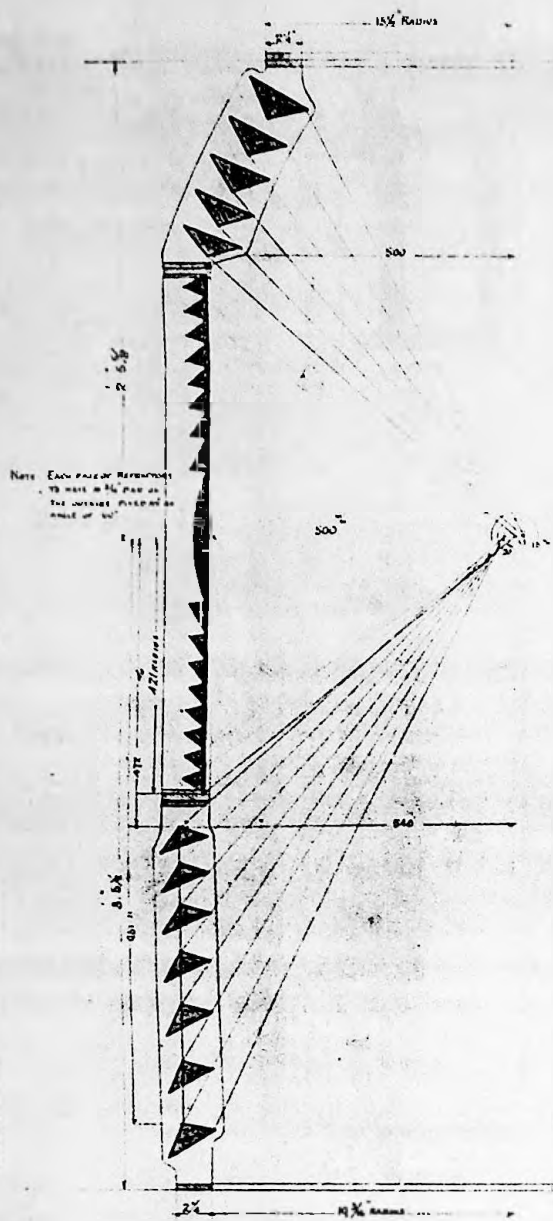
A1

A2


A3

A4


A1



— VERTICAL SECTION —

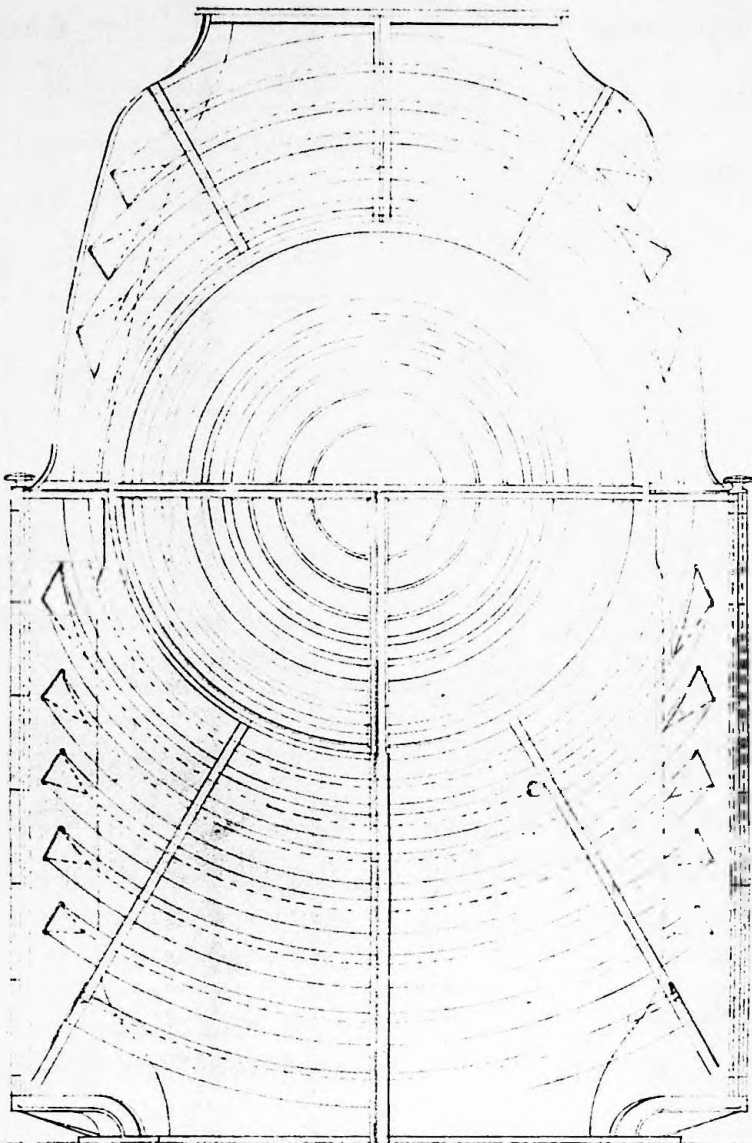

— ELEVATION OF LANTERN SHOWING DOORS —

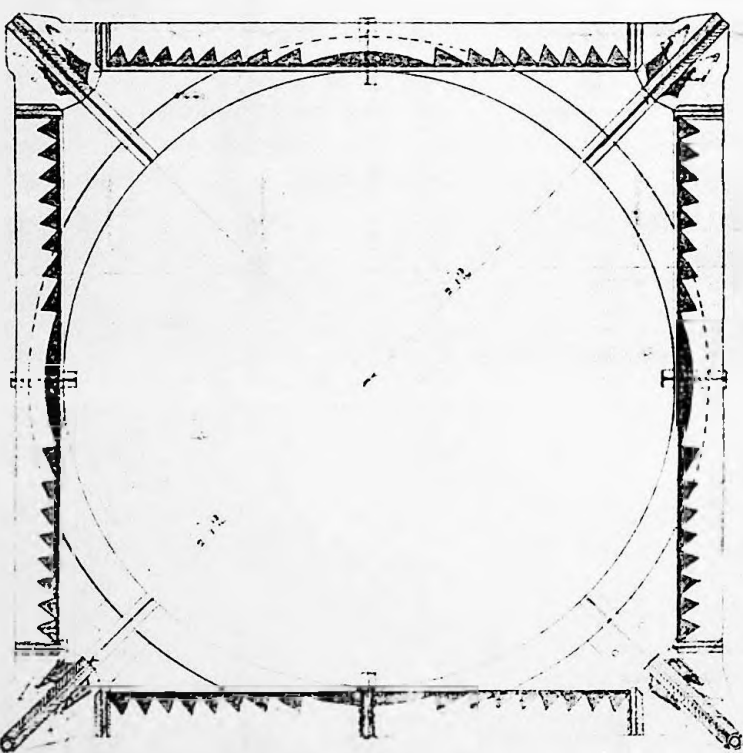

— SECTION OF LANTERN ROOM —

— CAPE PEMBROKE LIGHTHOUSE —

— SINGLE FLASHING APPARATUS OF 500' FOCAL DISTANCE —
FULL SIZECHANCE BROTHERS
AND COMPANY
LIGHTING ENGINEERS
NEW YORK, N.Y.

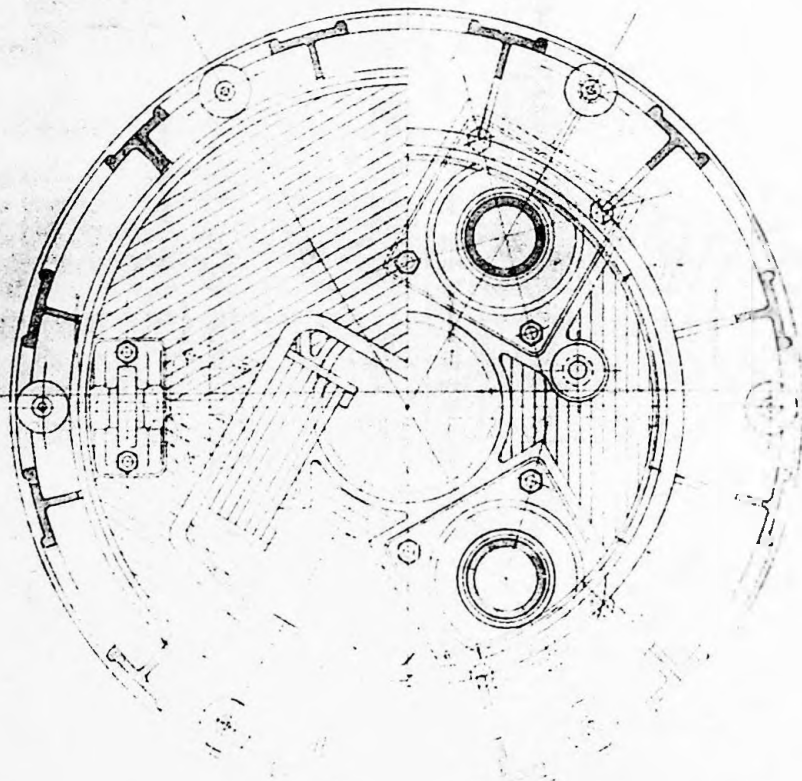
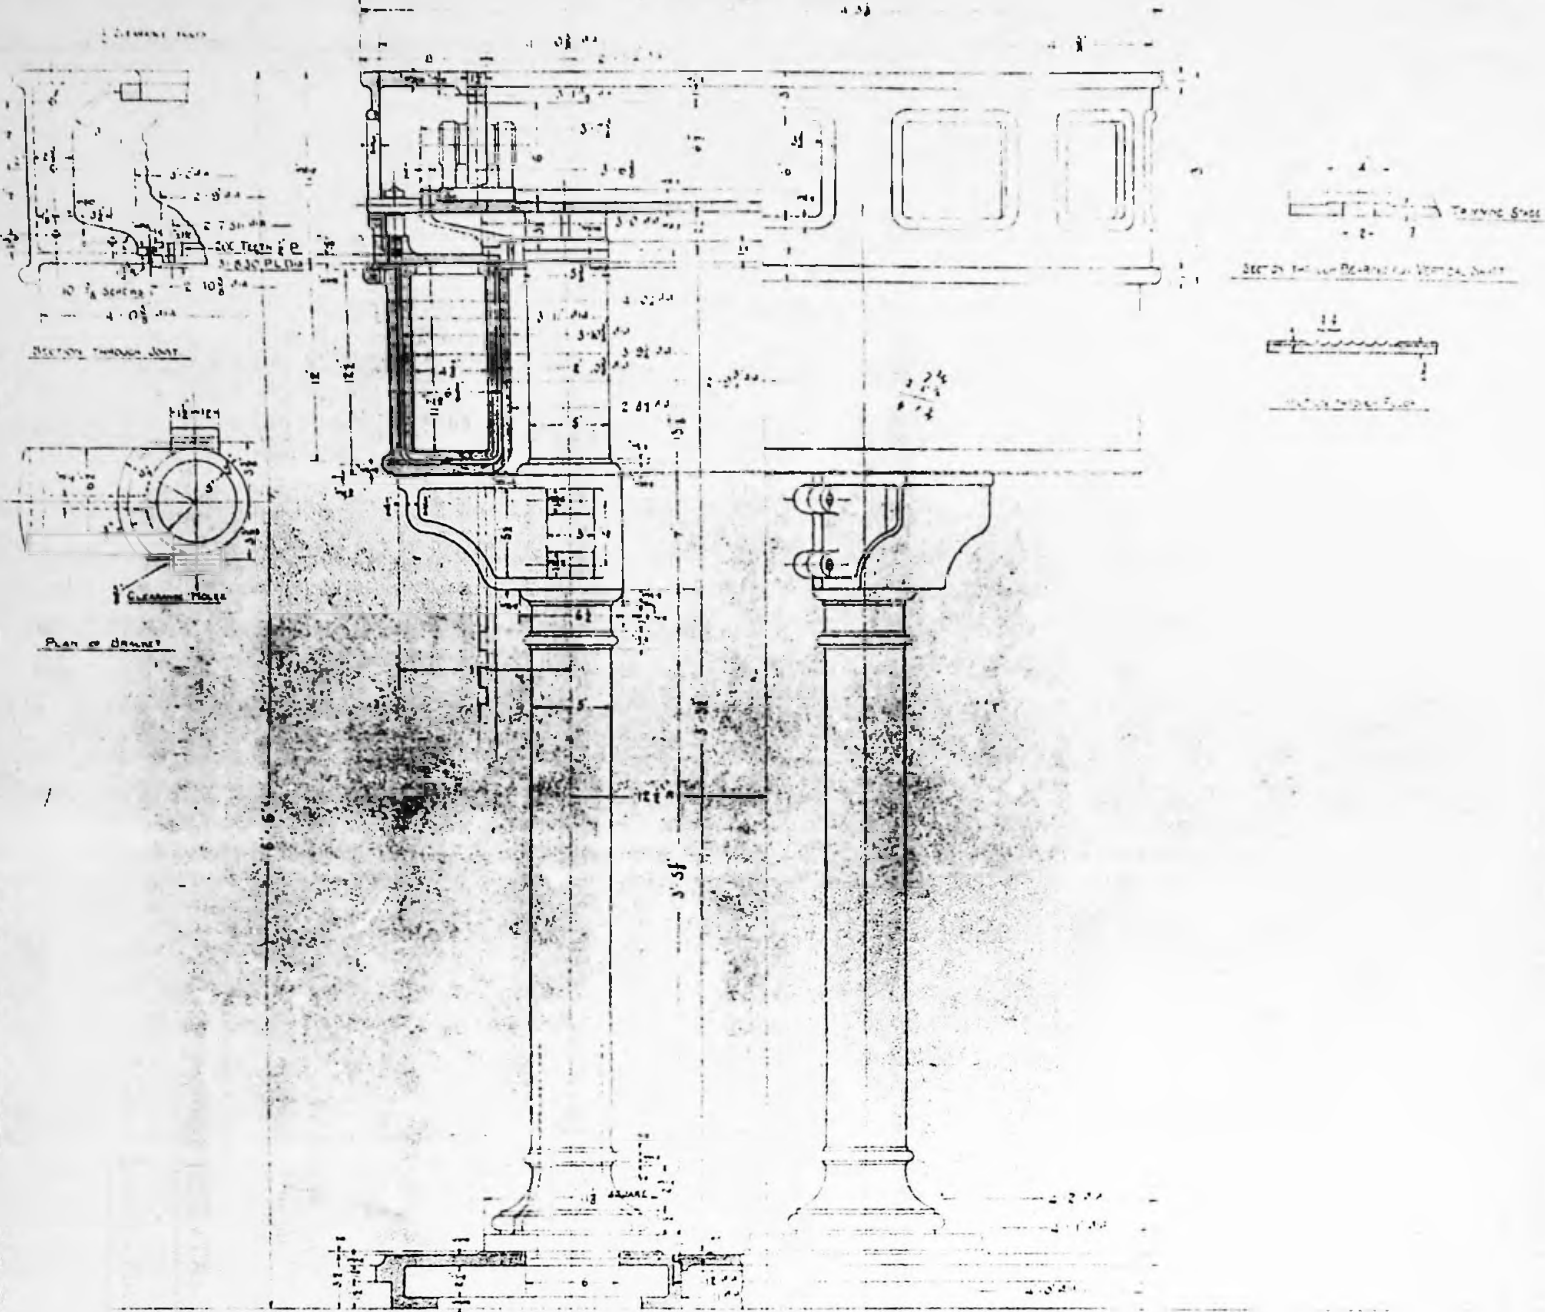
DRAWING NO 4436

96/31

— MERCURY PEDESTAL SUITABLE FOR 3RD ORDER APPARATUS —

— TRINITY HOUSE TYPE —

SCALE 3/16" = 1" 1/2"




96/32

CHARLES BROTHMAN
AND COMPANY LIMITED
LIGHTHOUSE ENGINEERS
NEW BIRMINGHAM

DRAWING N° 4542

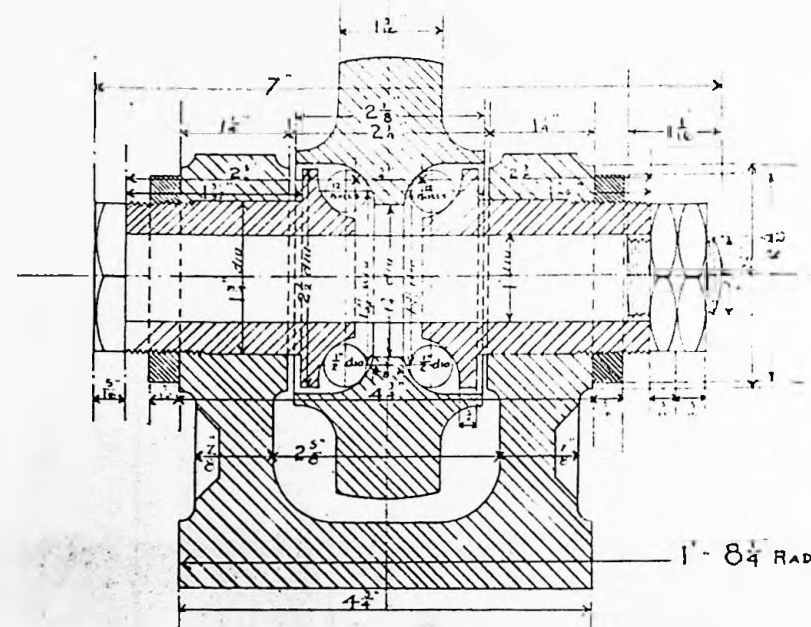
DETAIL OF THIRD ORDER PEDESTAL ROLLERS




SECTION.

3 OFF THIS

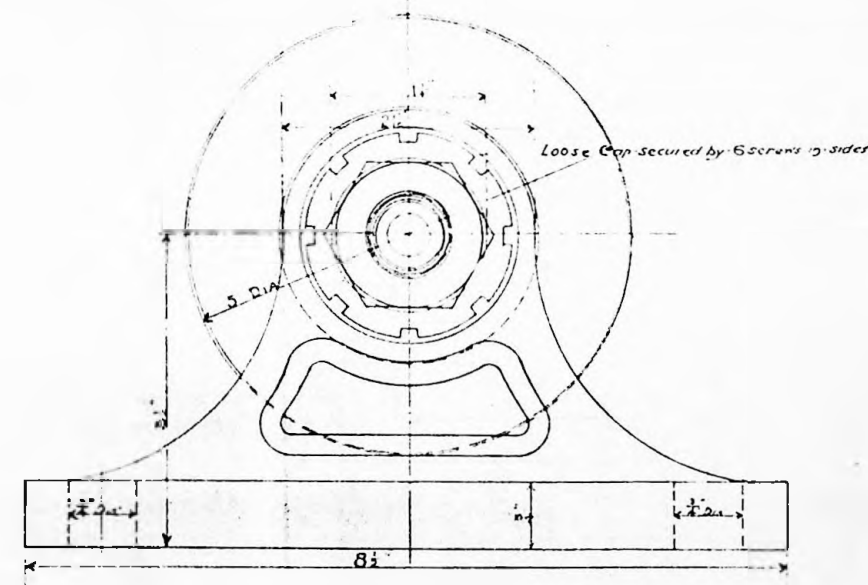VERTICAL ROLLERS WITH BALL BEARINGS



ELEVATION

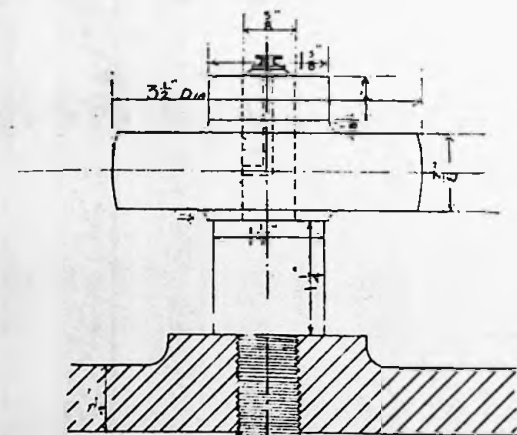


ELEVATION

6 OFF THIS

HORIZONTAL ROLLERS.

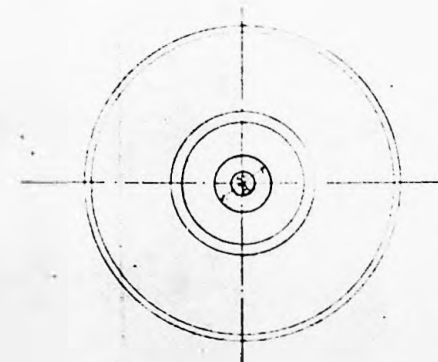SCALE - FULL SIZE



PLAN

CHANCE BROTHERS
AND CO LIMITED
LIGHTHOUSE ENGINEERS.
NEAR BIRMINGHAM

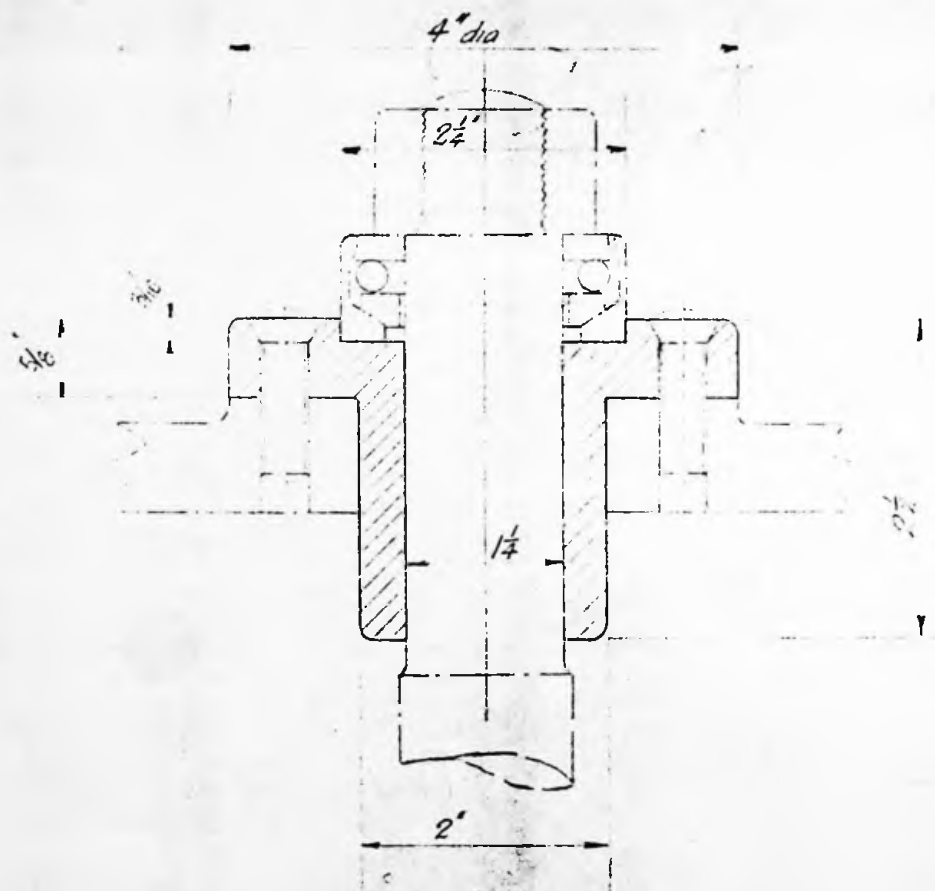
10 Aug 1905
Admitted

96/33

DRAWING No 4361

CAPE PEMBROKE L.H°





SKETCH OF UPPER BEARING OF DRIVING SHAFT



SK NO 4506/H

96/34

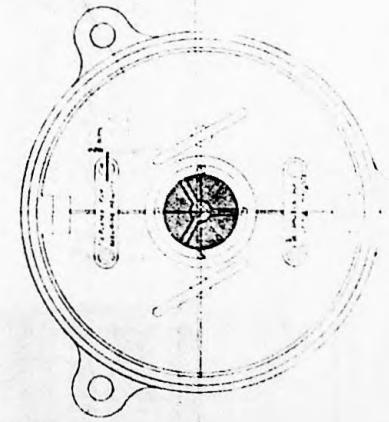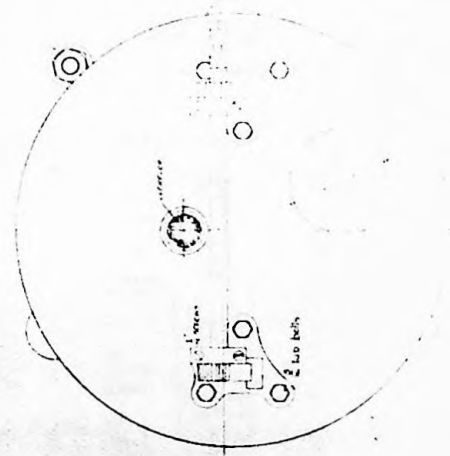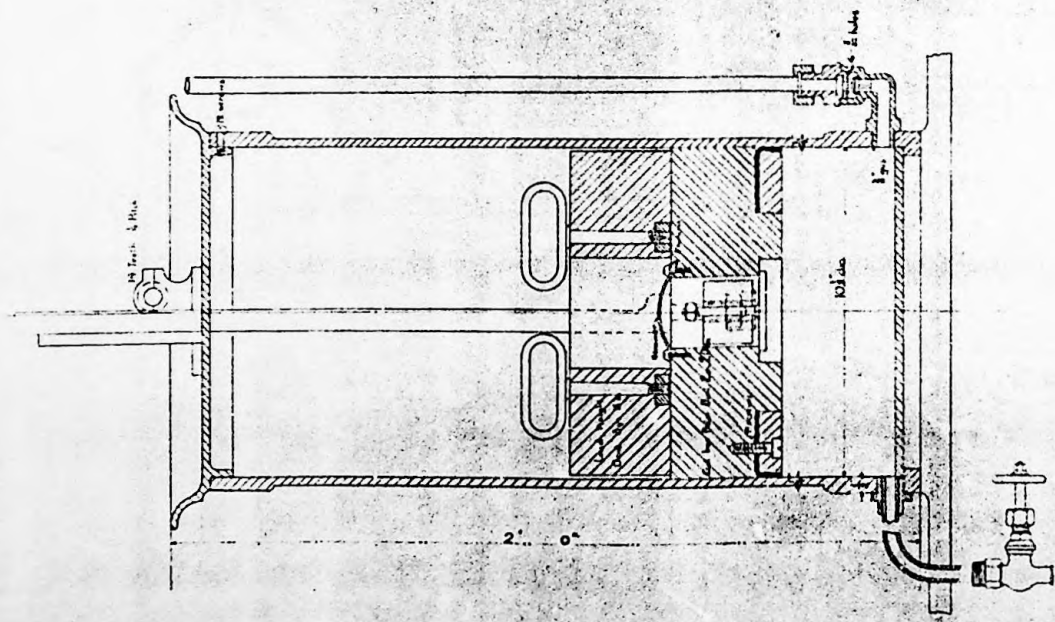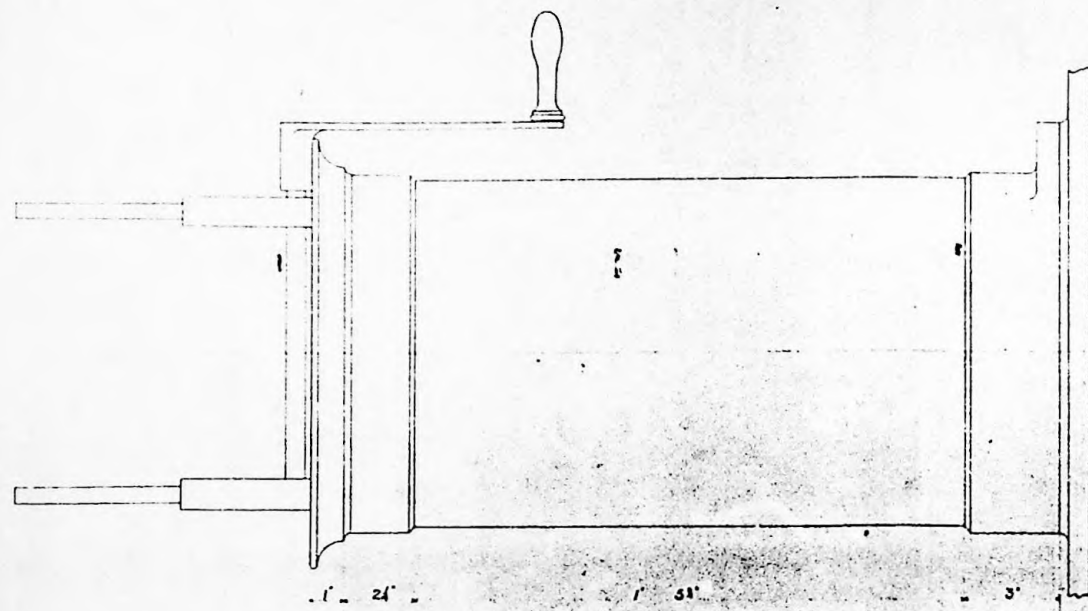SEE CB DRG NO 4506



CAPE · PEMBROKE · LIGHTHOUSE

GENERAL ARRANGEMENT OF PRESSURE LAMP

96/35

Half Full Size
CHANCE BROTHERS
AND CO LIMITED
LIGHTHOUSE ENGINEERS
NEAR BIRMINGHAM

DRAWING No 4397

24 Sep 1905
D. J. Smith

A0

A1

A2

A3

A4

A4

A3

A2

A1

A0

A0

A1

A2

A3

A4

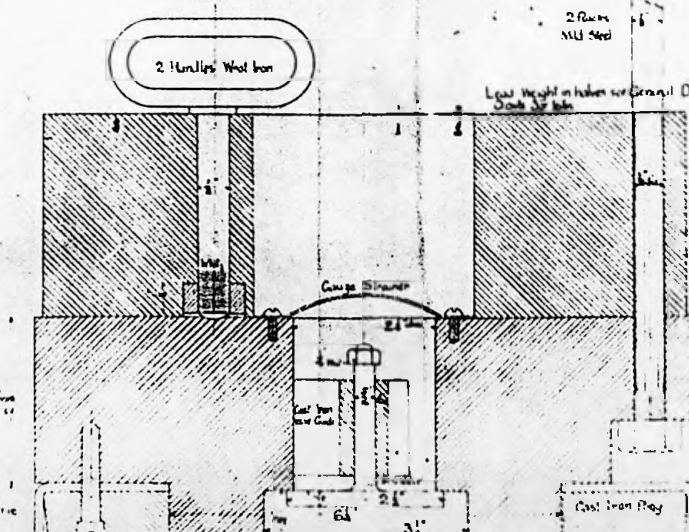
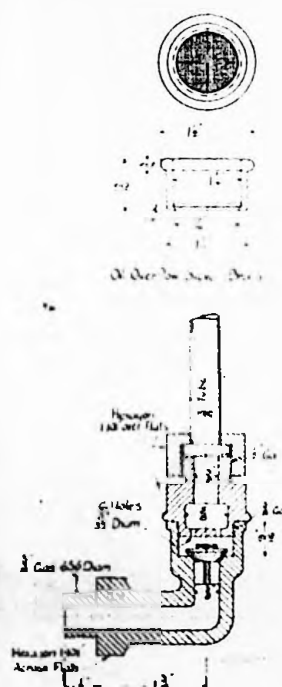
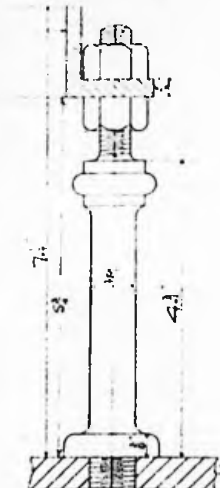
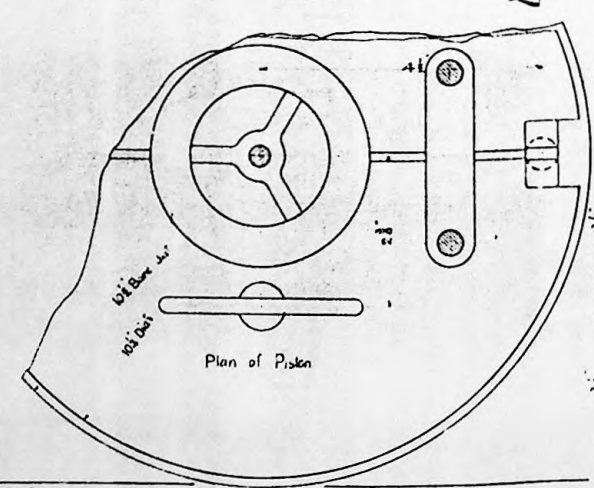
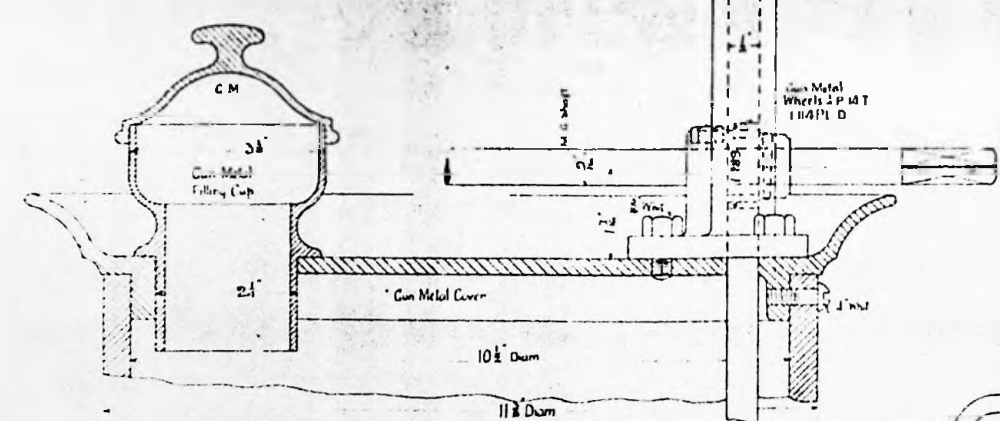
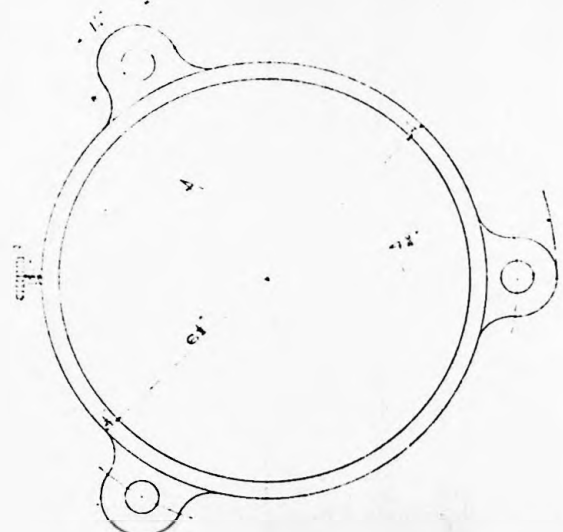
A4

A3

A2

A1

A0



CAPE PEMBROKE LIGHTHOUSE

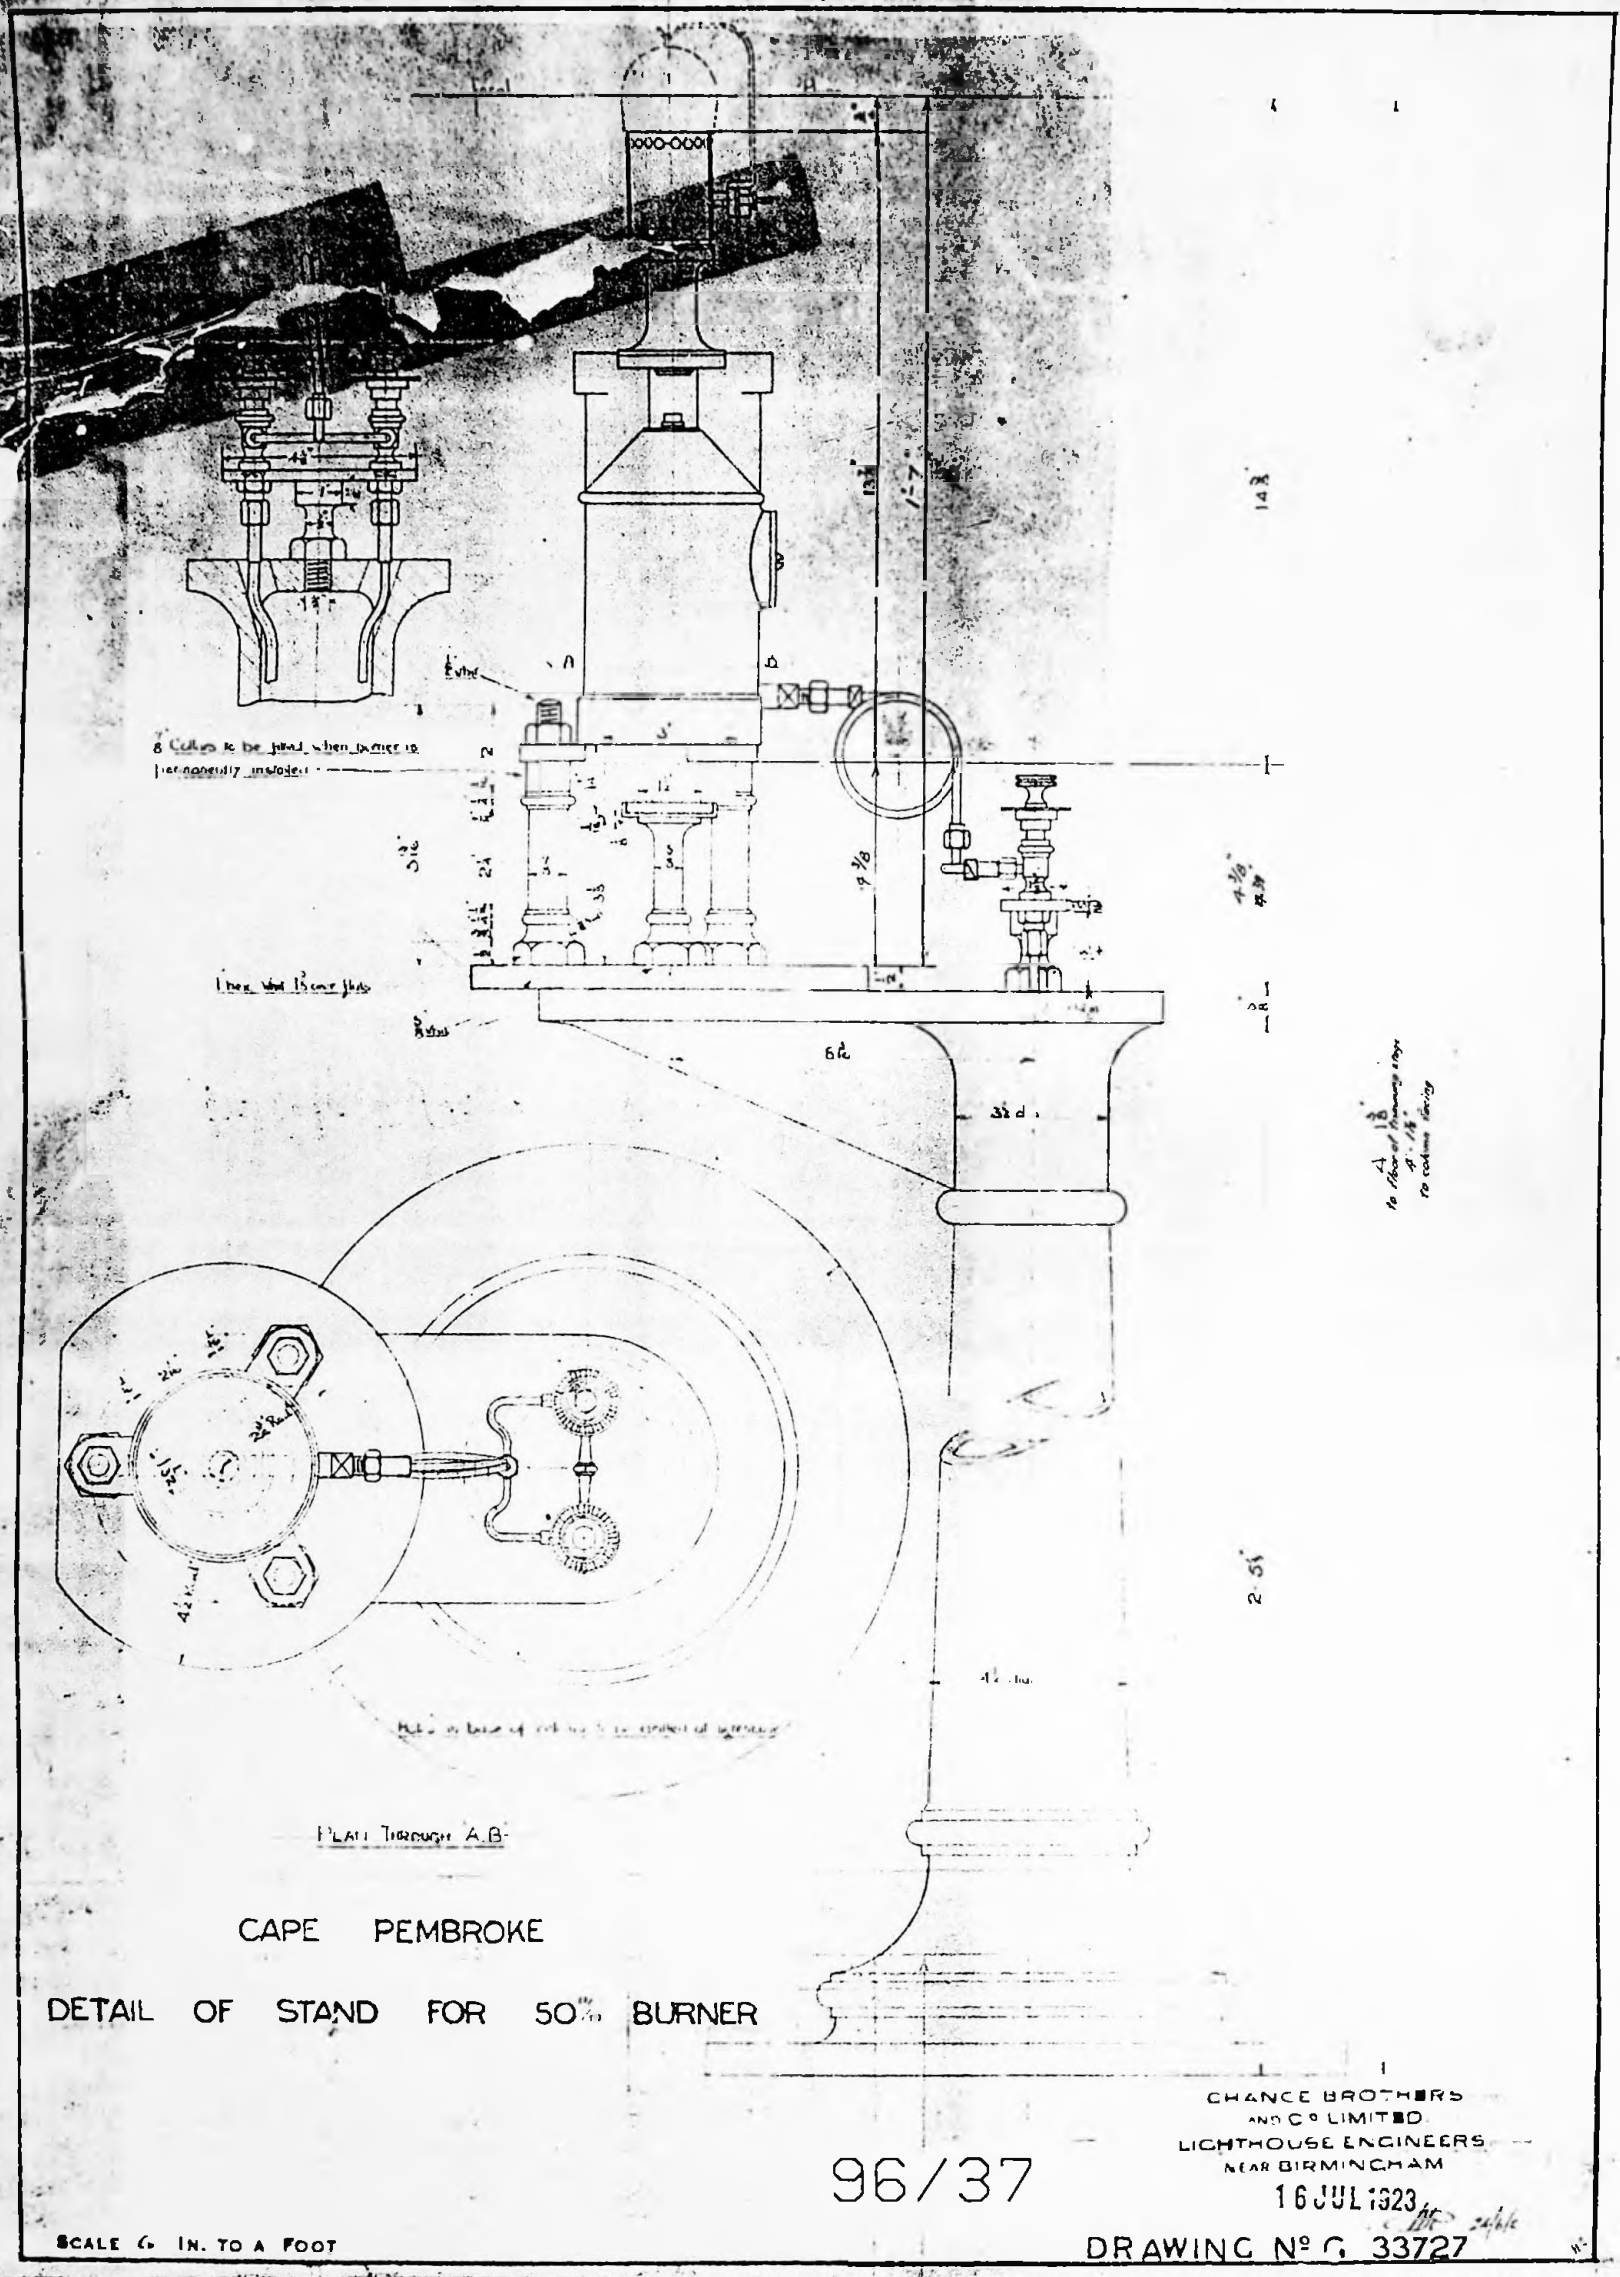
DETAILS OF SCALE IN THE SCALE LINE

96/36

Full Size
CRANE BROTHERS
LIMITED
ENGINEERS
NEW BIRMINGHAM

DRAWING NO 4396

29.5.1905
J. H. H. H.



CAPE PEMBROKE
 DETAIL OF STAND FOR 50th BURNER

CHANCE BROTHERS
 AND CO LIMITED
 LIGHTHOUSE ENGINEERS
 NEAR BIRMINGHAM

96/37

16 JUL 1923

DRAWING N° G. 33727

SCALE 6 IN. TO A FOOT

A2 A3 A4 A4 A3 A2 A1

A 0

A 0

A 1

A 1

A 2

A 2

A 3

A 3

A 4

A 4

A 4

A 4

A 3

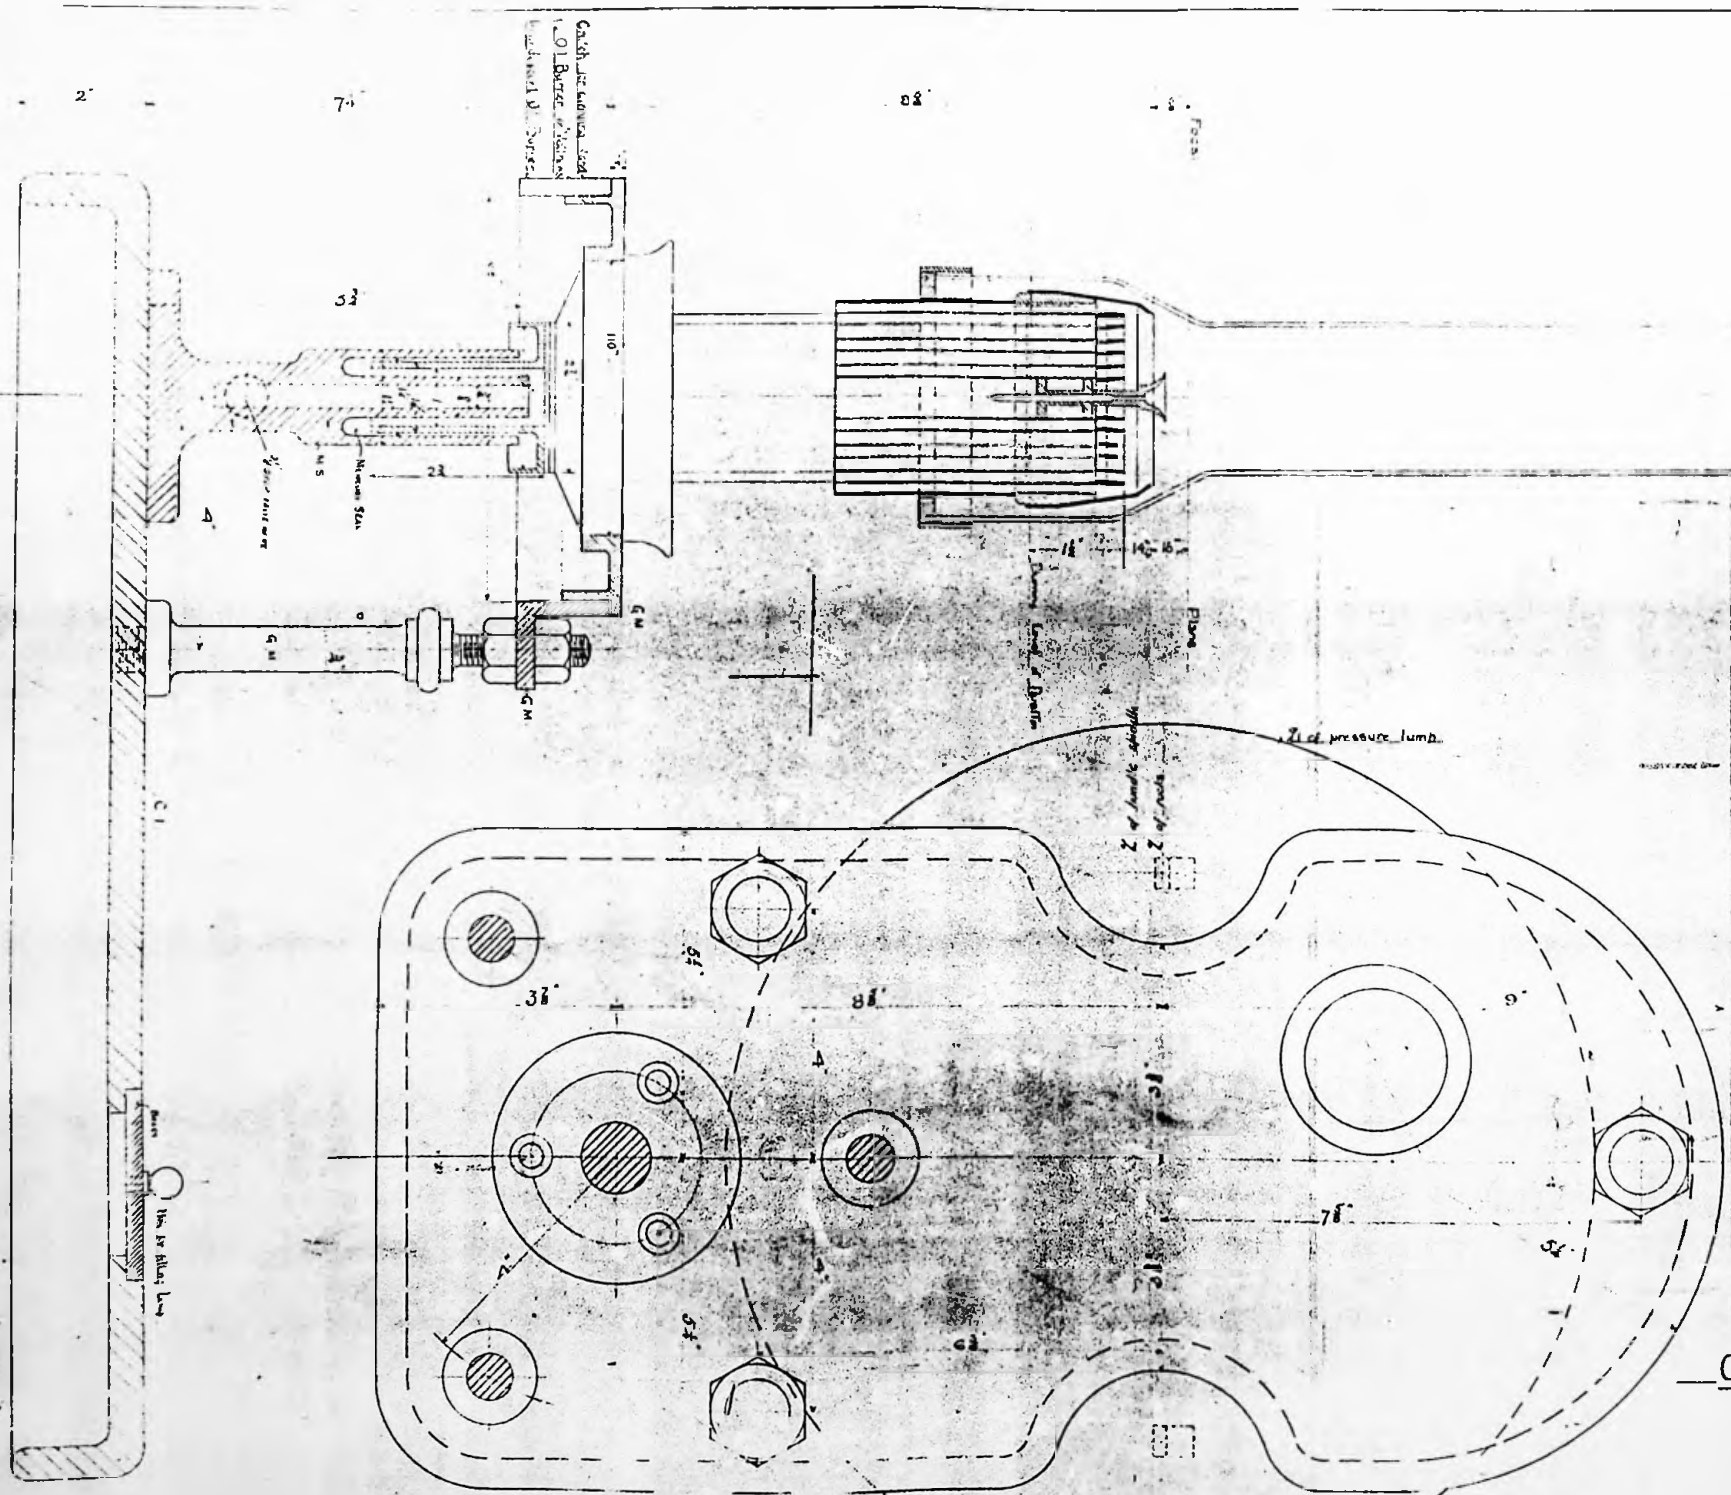
A 3

A 2

A 2

A 1

A 1



CAPE · PEMBROKE · LIGHTHOUSE

DETAILS · OF · BURNER · STAND

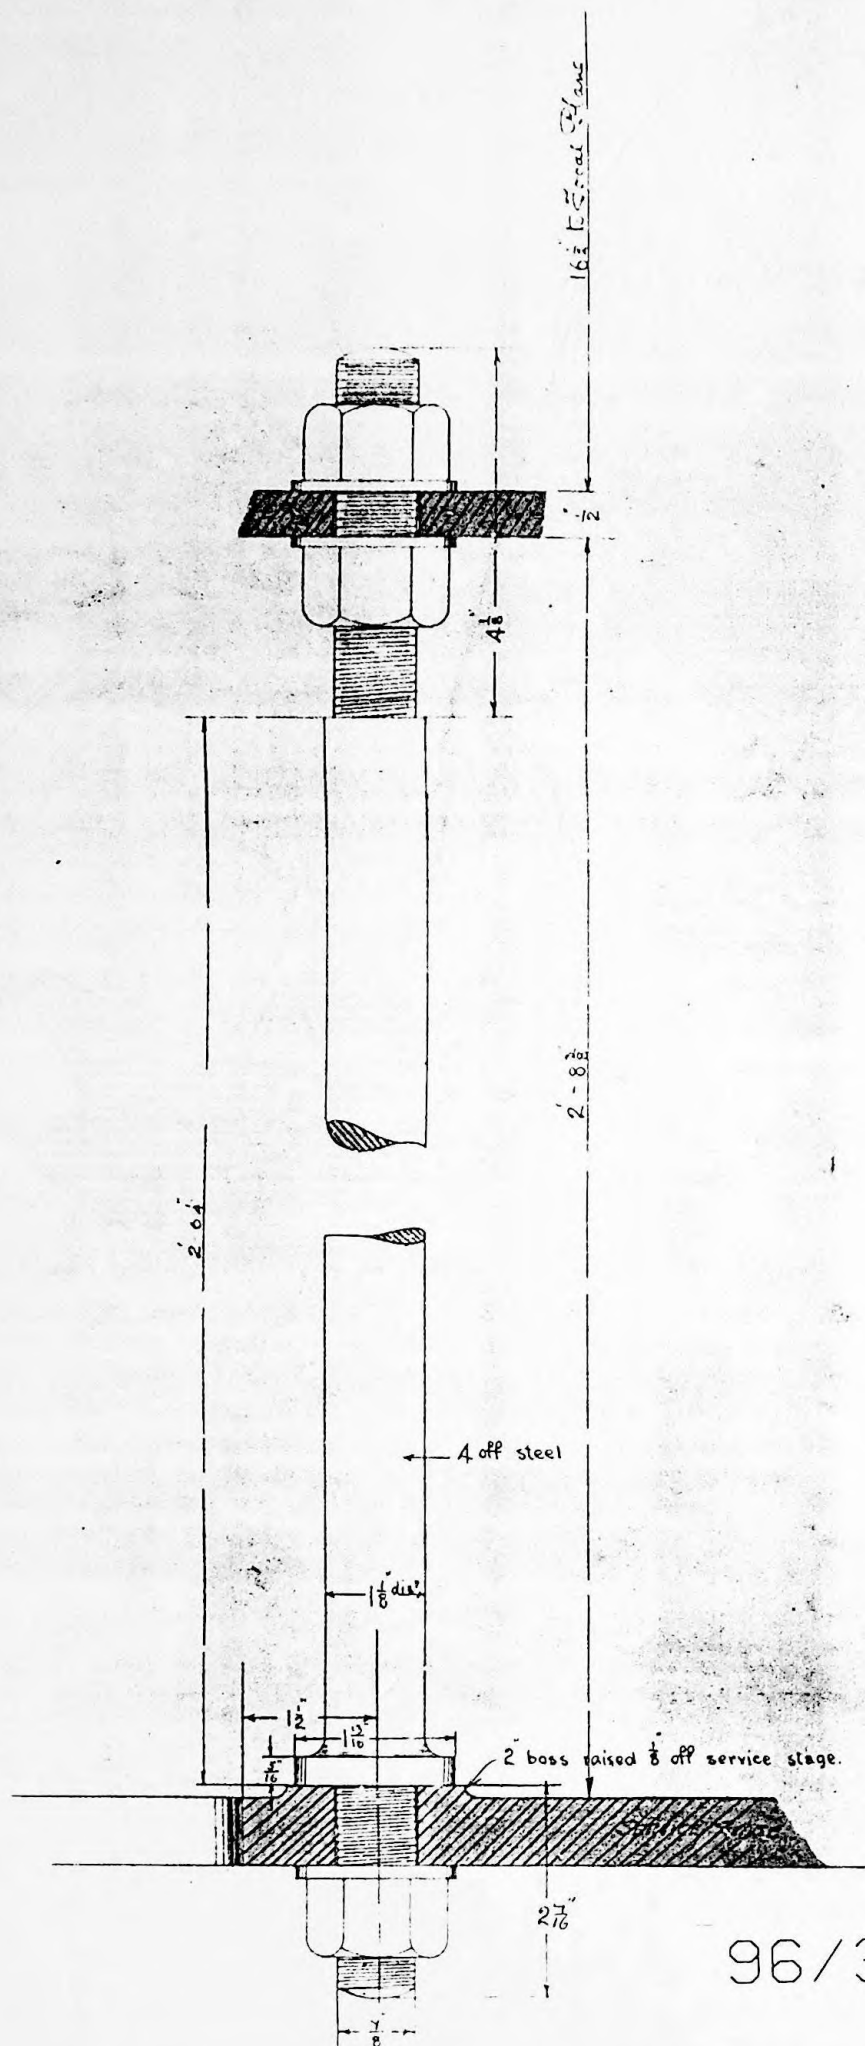
Full Size

CHANCE BROTHERS
LIMITED
LIGHTHOUSE ENGINEERS
SHEFFIELD

96/38

DRAWING No. 4109

3rd 1905
10/1/05



— Standards for carrying burner stand —
— Full Size —

CHANGE BROTHERS
AND CO. LIMITED
LIGHTHOUSE ENGINEERS
NEAR BIRMINGHAM

96/39

DRAWING No 4480

A2

A3

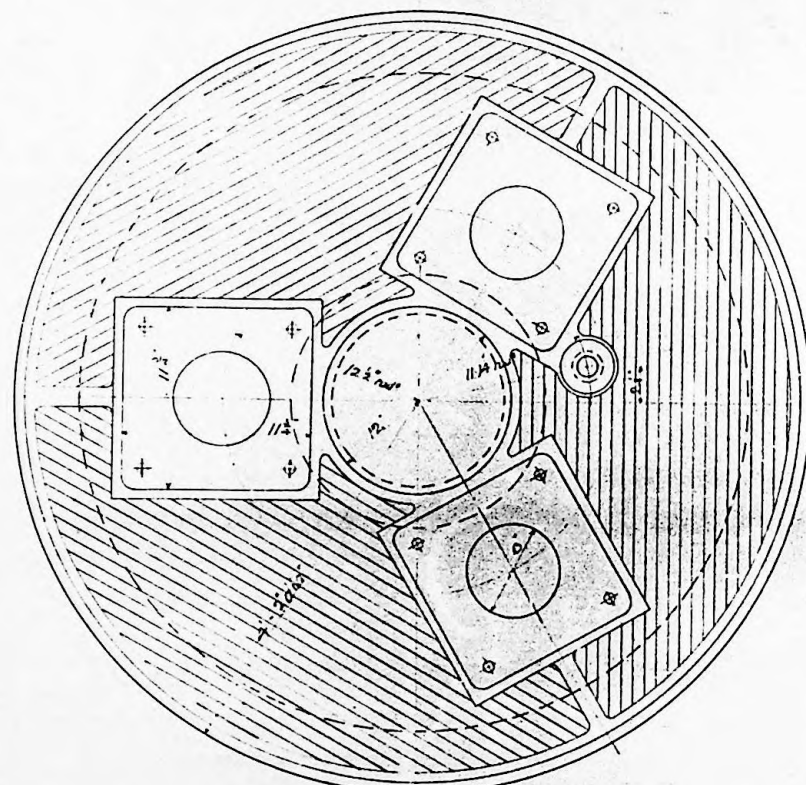
A4

A4


A3

A2


A1



PLAN OF BASE PLATE

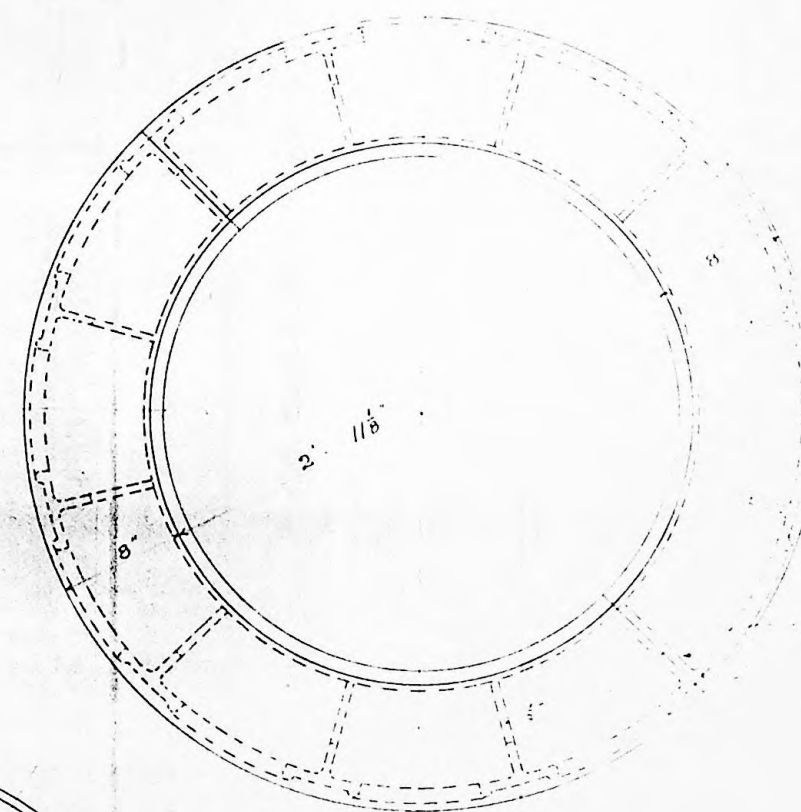

PLAN OF TOP CARRIAGE

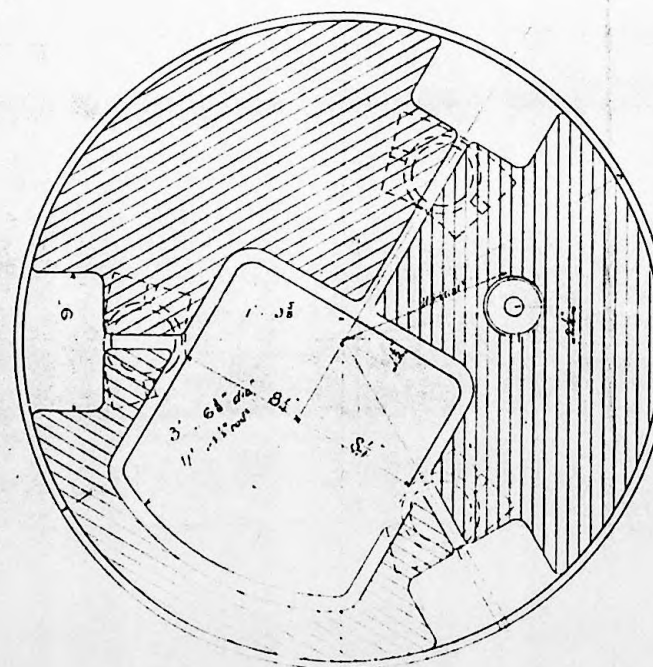

PLAN OF SERVICE FRAME

CAPE PEMBROKE LIGHTHOUSE.

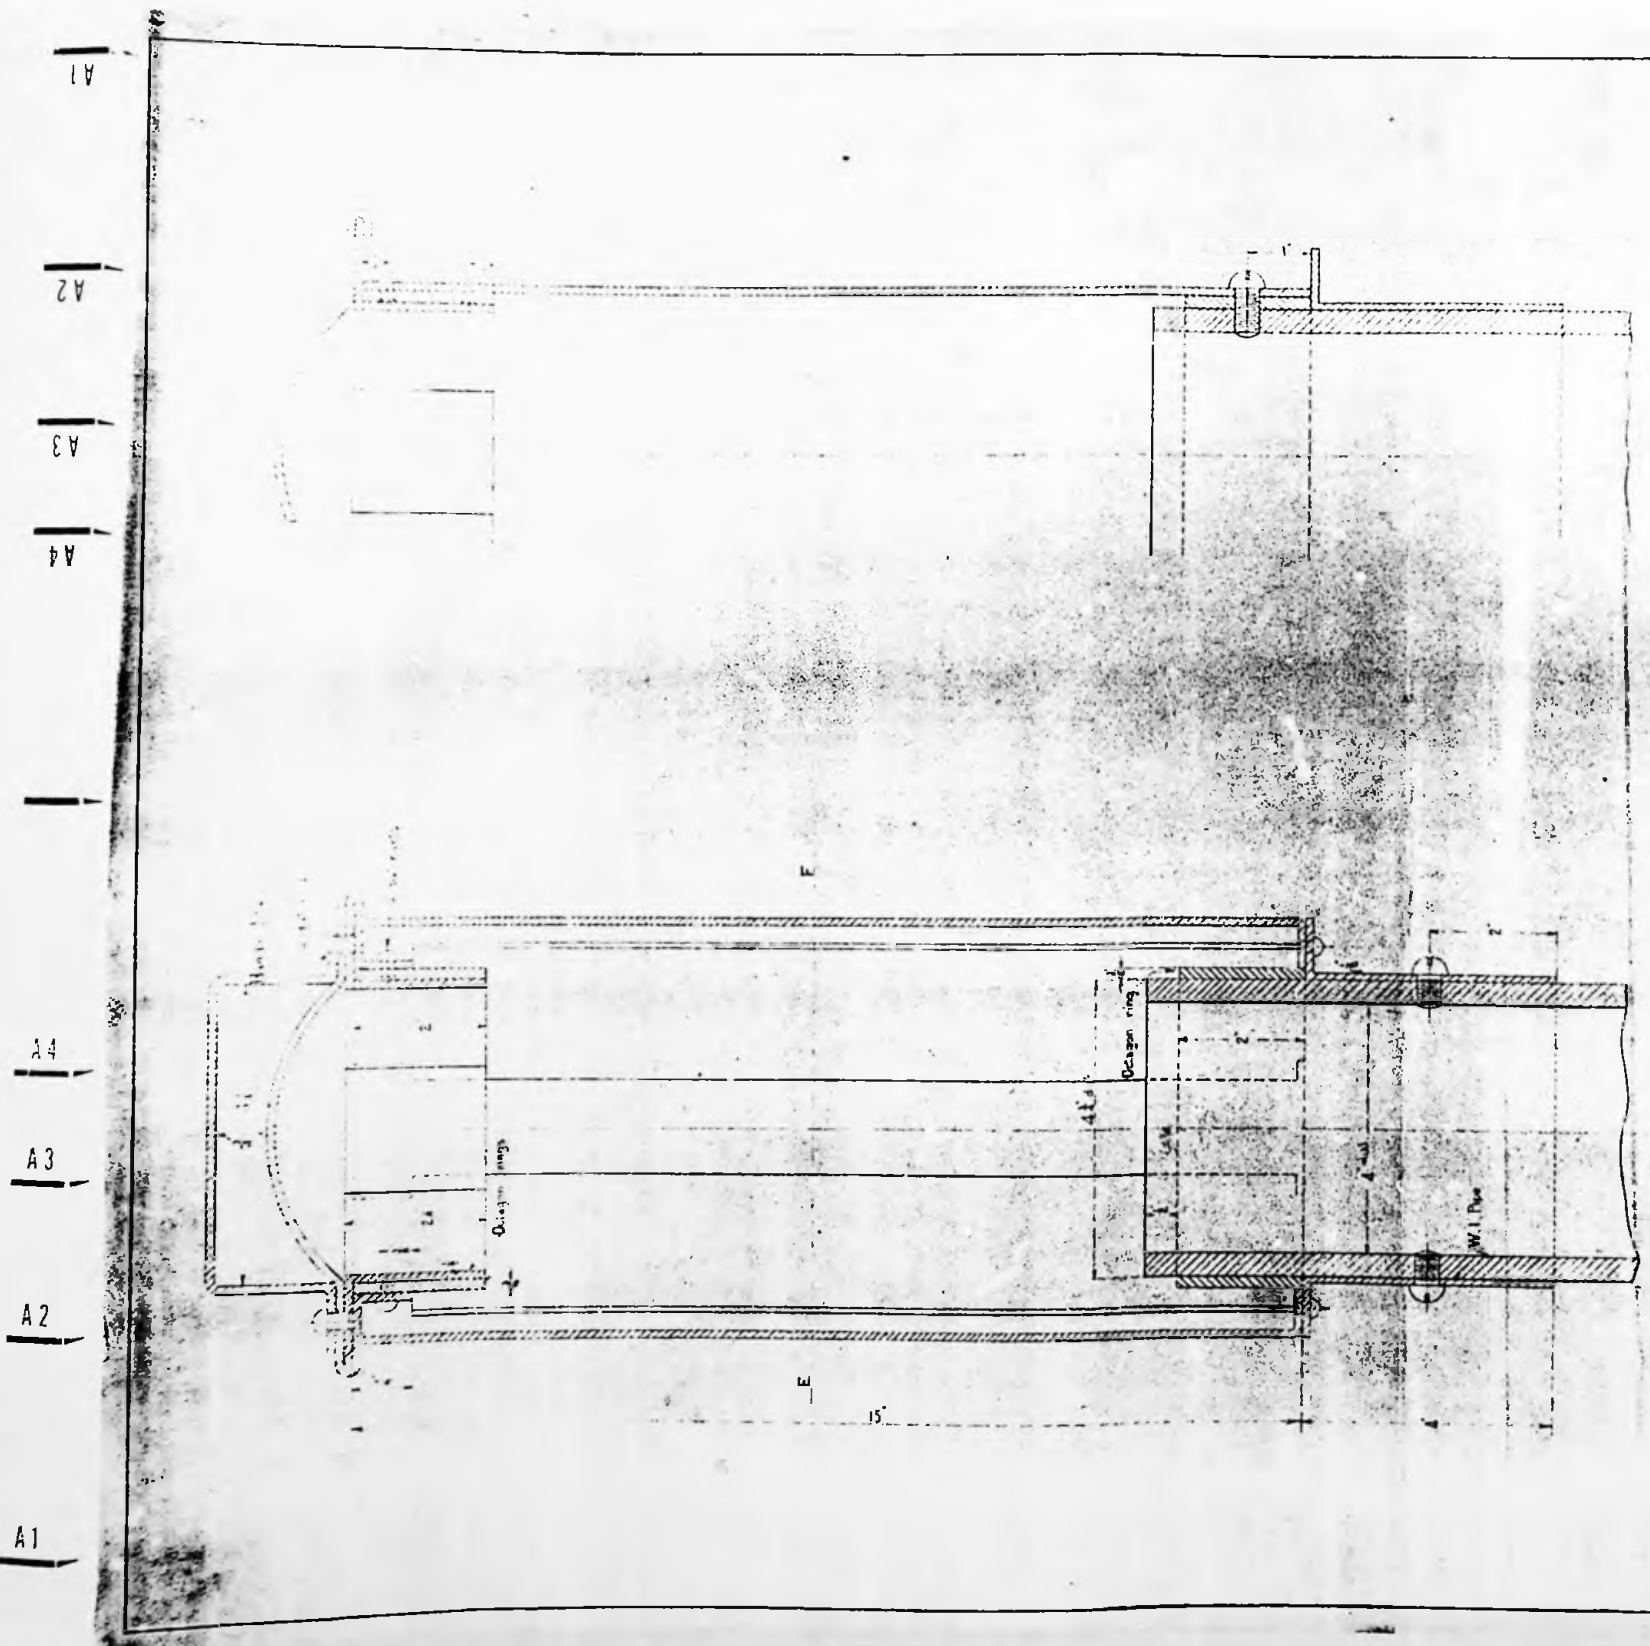
PLANS OF
CARRIAGE, SERVICE FRAME, BASE PLATE.

Scale: 1/4" = 1"

96/40


CHANCE BROTHERS
AND CO. LIMITED
LIGHTHOUSE ENGINEERS
NEW BIRMINGHAM

DRAWING NO. 4390



Half Sectional Elevation on line C D

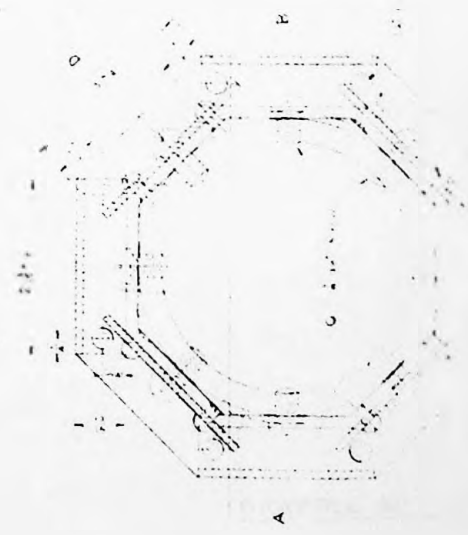Sectional Elevation on line A B




COPPER WINDGUARD

Full Size

96/41

FRANK BROTHERS
INC. LIMITED
ENGINEERS
SHEFFIELD, ENGLAND


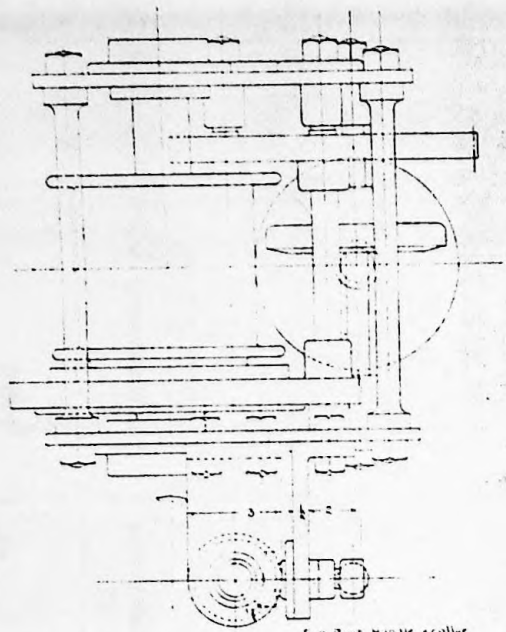
DRAWING NUMBER



Wheel	N ^o of teeth	Pitch	Pitch dia	Revs per min	Remarks
A	84	$\frac{3}{8}$	10.026	180	G.M.
B	16	-	1.910	997	M.S.
C	80	-	2.549	-	G.M.
D	16	-	1.910	5	M.S.
E	36	-	4.297	-	G.M.
F	36	-	-	-	-
G	91	$\frac{1}{4}$	7.241	-	-
H	15	-	1.194	30.3	M.S.
J	72	-	5.729	-	G.M.
K	16	-	1.273	136	M.S.

Race Wheel, 200 teeth, $\frac{1}{2}$ pitch, 31.83 pitch dia
 Race Pinion, 60 teeth, $\frac{1}{2}$ pitch, 2.549
 Fall of weight per hour - 16-5 direct.
 Fall of weights 20 feet per hour
 Driving weights 186 lbs.

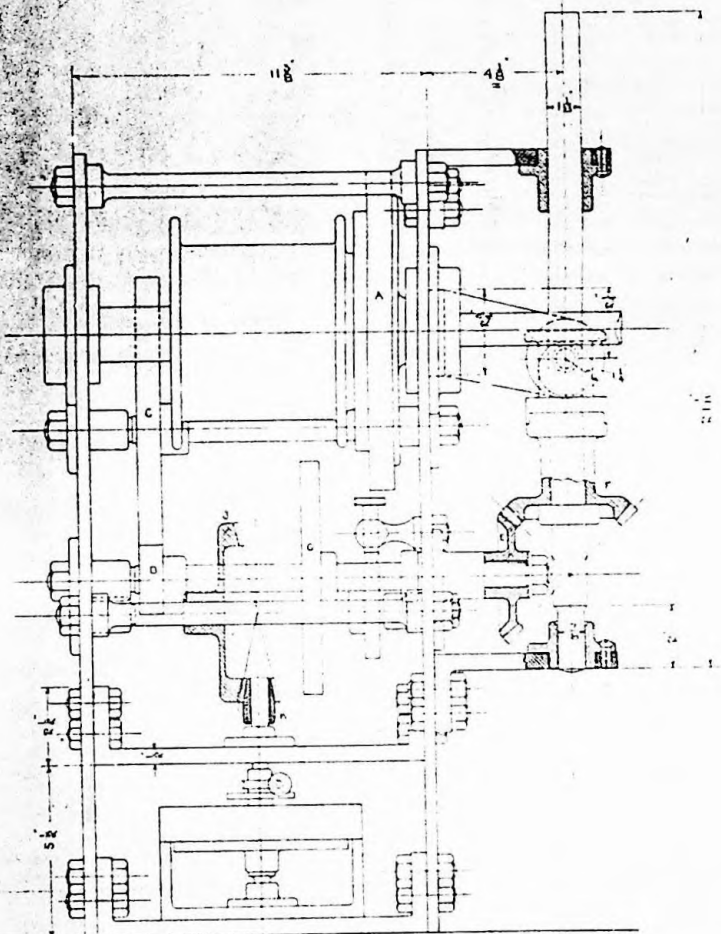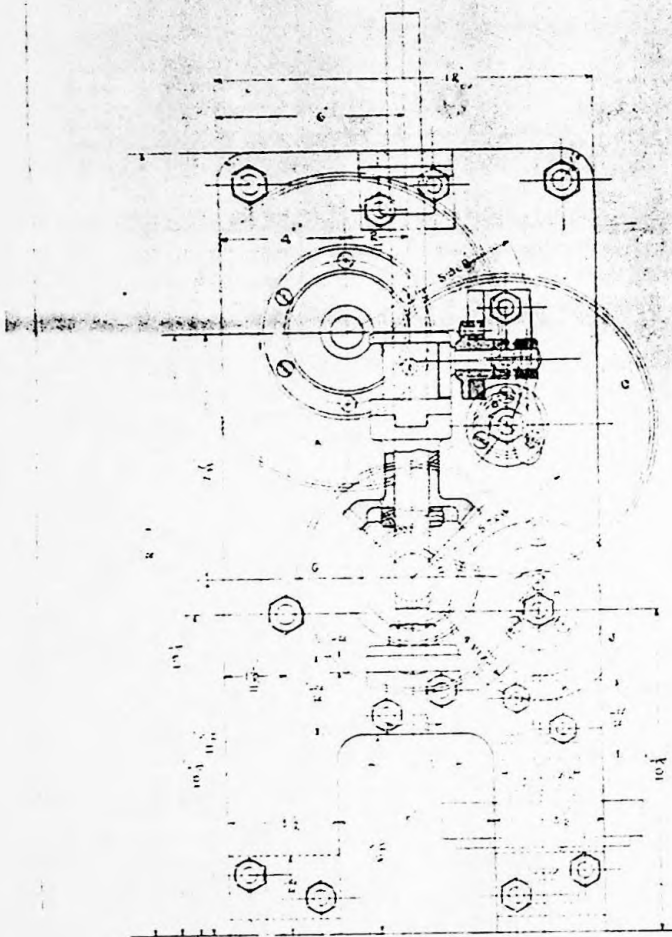For shaft handle roller
see Drawing 4825



CAPE PEMBROKE
3RD ORDER CLOCK.

Half Size.

DRAWING N^o 437-1

W. & A. L. BROTHERS
LIMITED
ENGINEERS
11, BIRMINGHAM

96/42

A0

A1

A2

A3

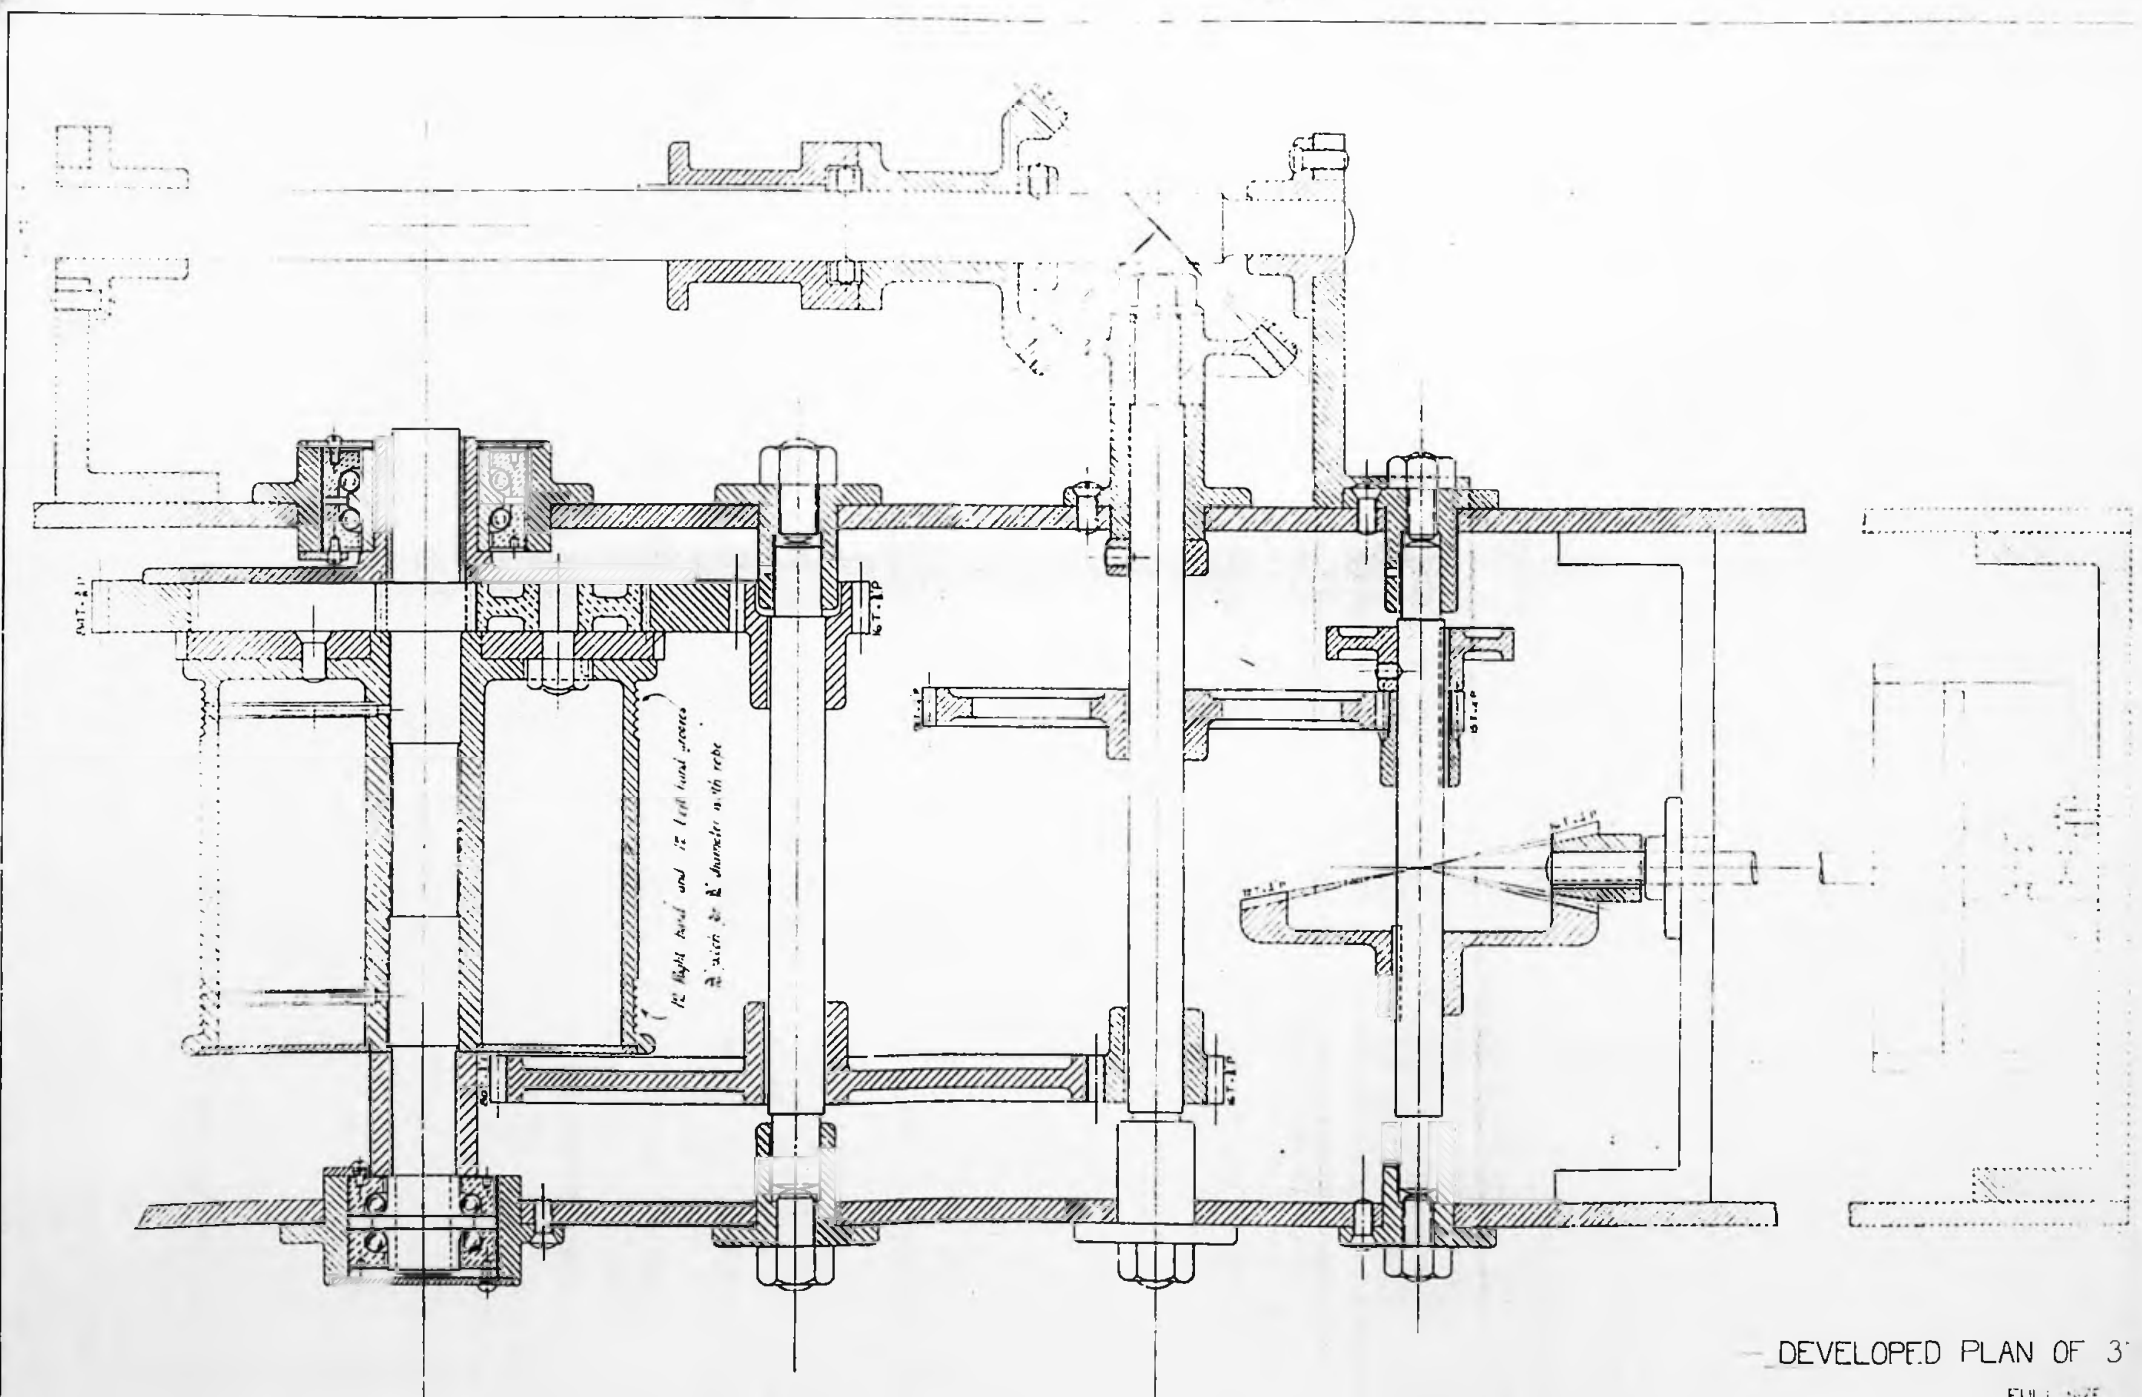
A4

A4

A3

A2

A1




DEVELOPED PLAN OF 3rd ORDER CLOCK.
FULL SIZE.

96/43

W. & A. T. & S. CO.
LONDON

DRAWING NO 4308

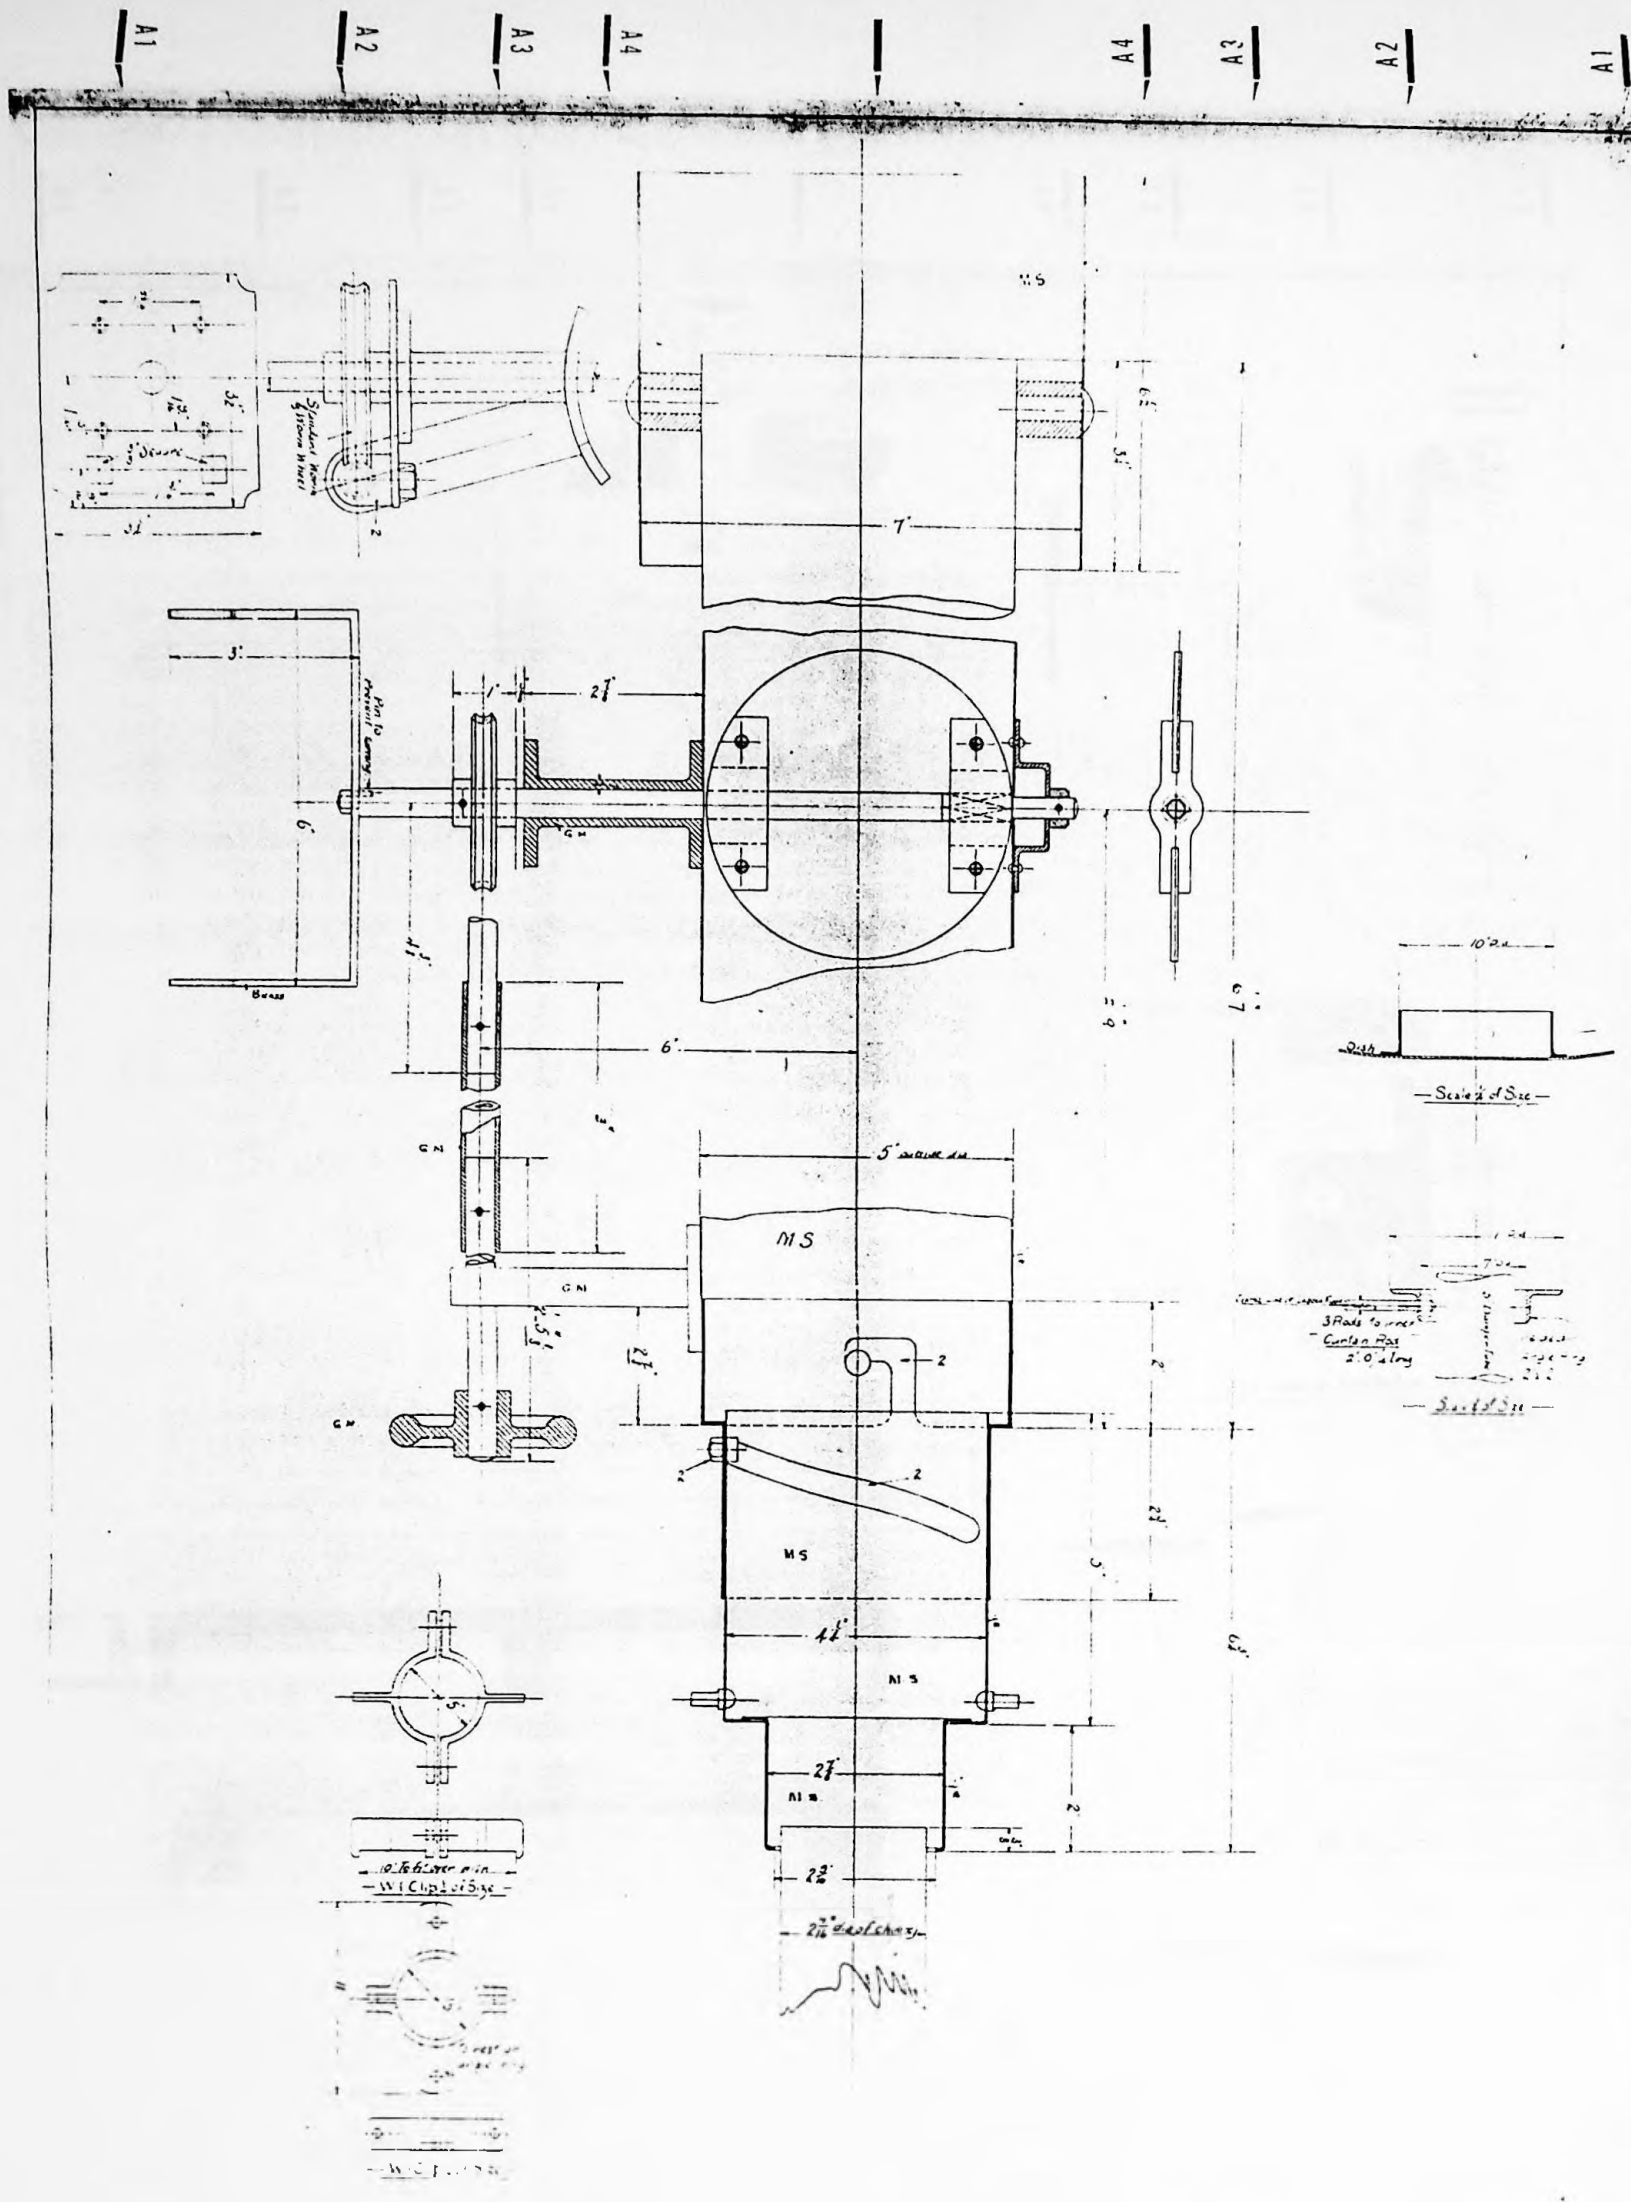96/43




CAPE PEMBROKE LIGHTHOUSE

96/44

CHANCE BROTHERS
LIMITED
LIGHTHOUSE ENGINEERS
NEW BIRMINGHAM

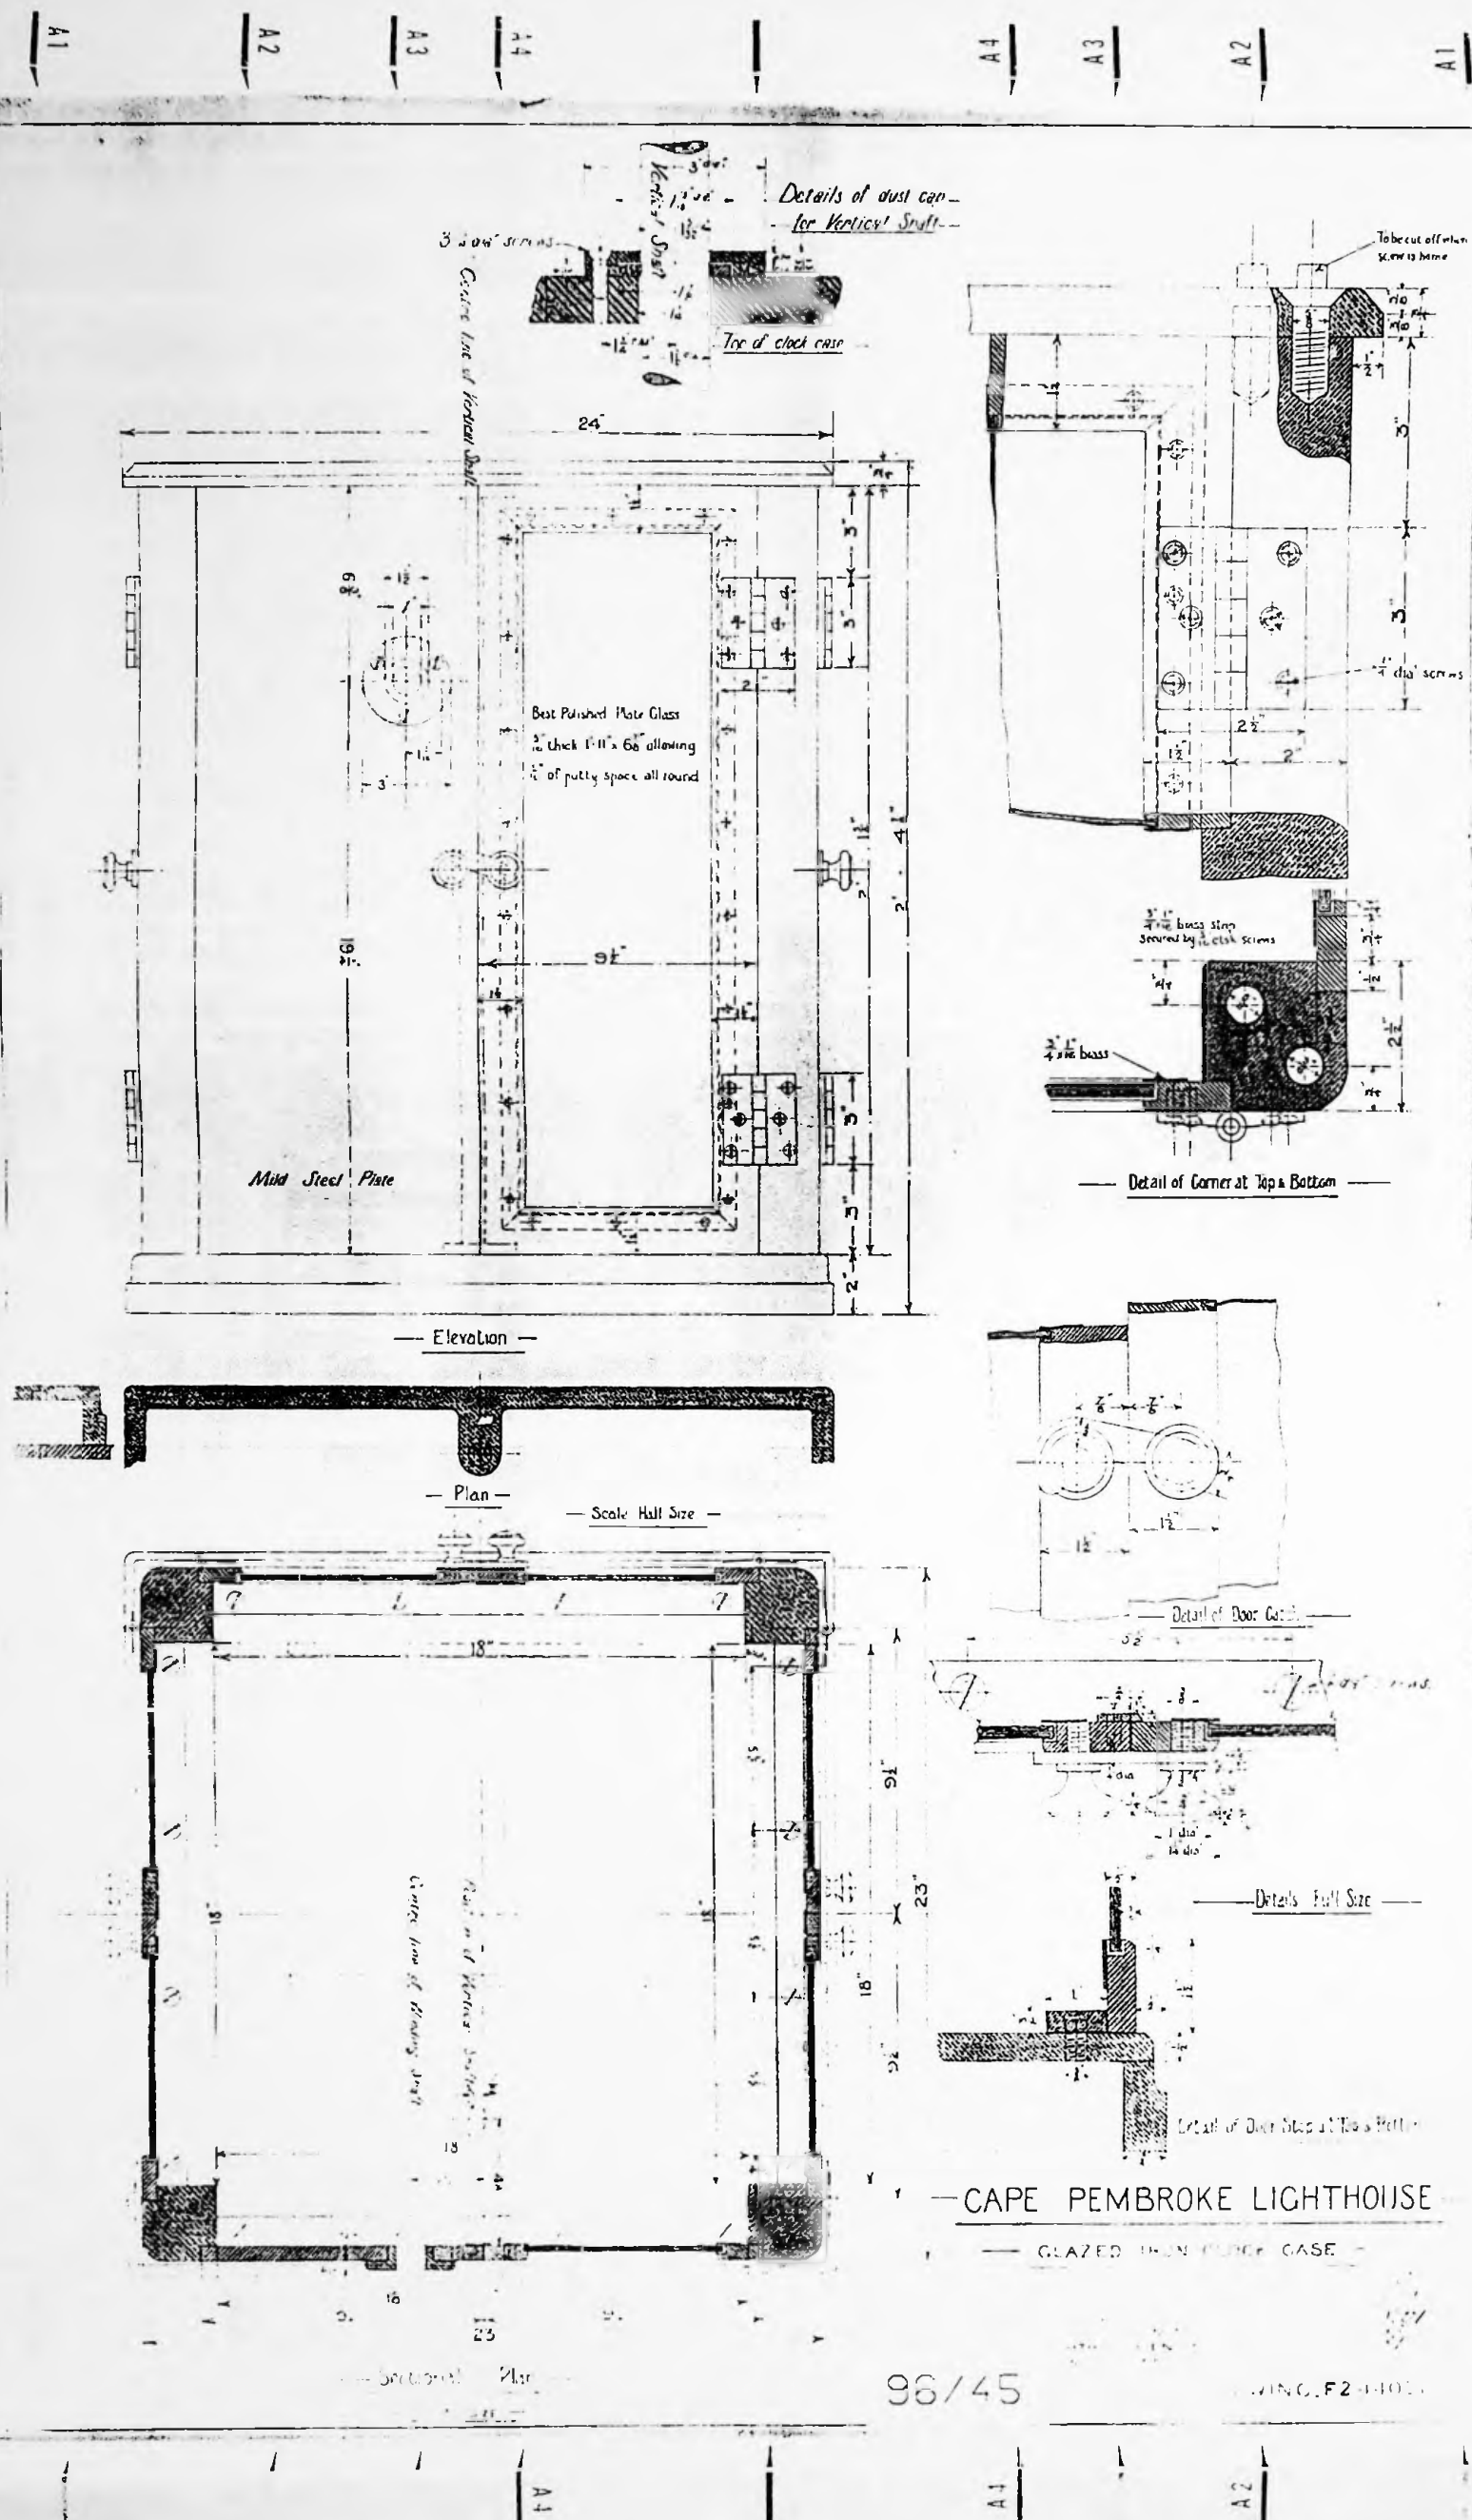DRAWING NO 4417



A 0

11

A 2

A 3

44

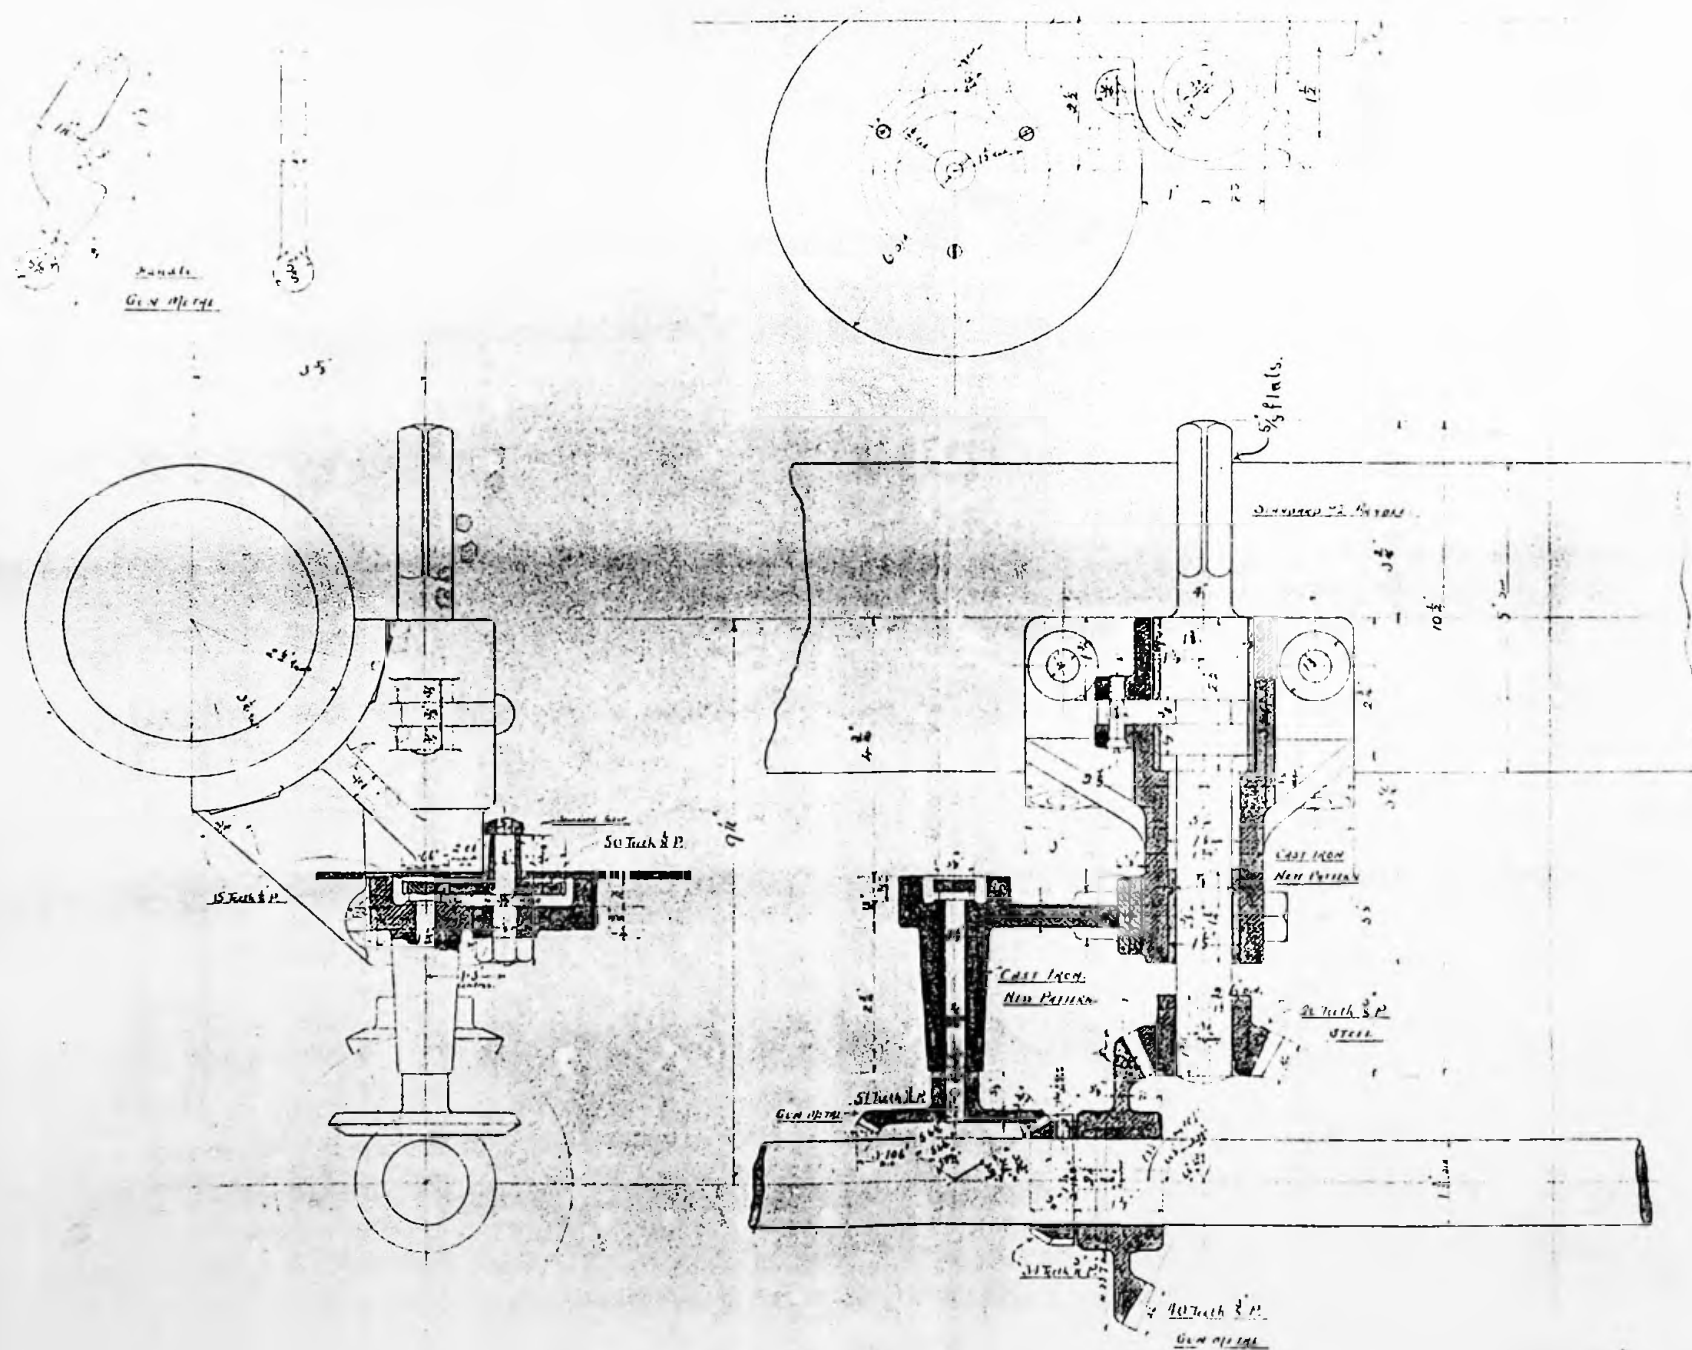
A 4

A 3

A 2

A 1

2
 4




-- CAPE PEMBROKE --
-- HAND TURNING & DIAL GEAR --
-- FULL SIZE --

CHANCE LIGHTING
AND CO LIMITED
LIGHTING ENGINEERS
NEW BIRMINGHAM

96 / 46

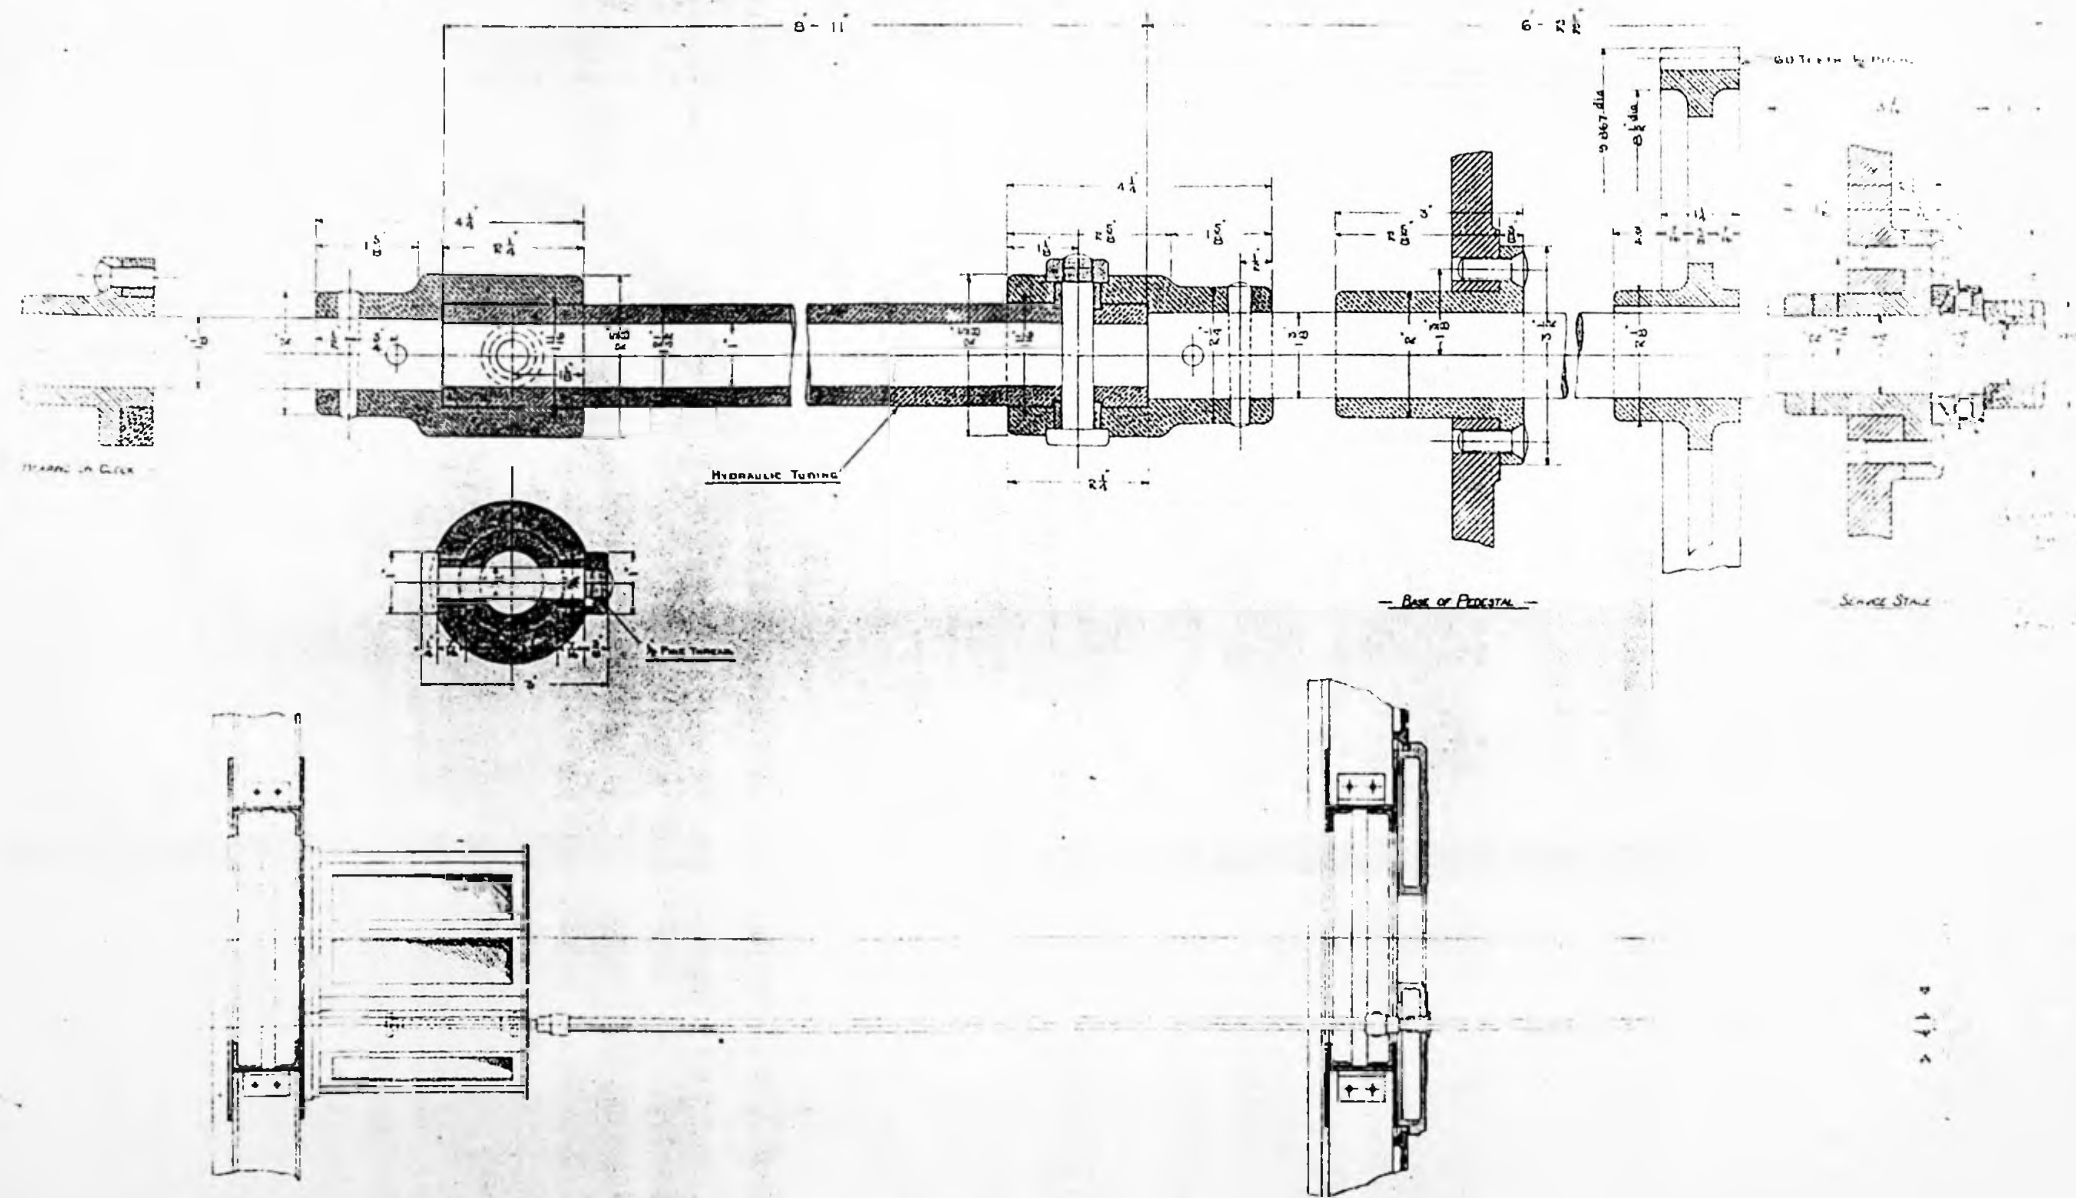DRAWING NO F 24620



— CAPE PEMBROKE —
 — DETAILS OF VERTICAL SHAFT —
 — FULL SIZE & IN PLACE —

96/47

CHANCE BROTHERS
 AND CO LIMITED
 LIGHTHOUSE ENGINEERS
 NEW BIRMINGHAM

DRAWING NO 4506

27.3.1936
 K. J. W.

A0

A1

A2

A3

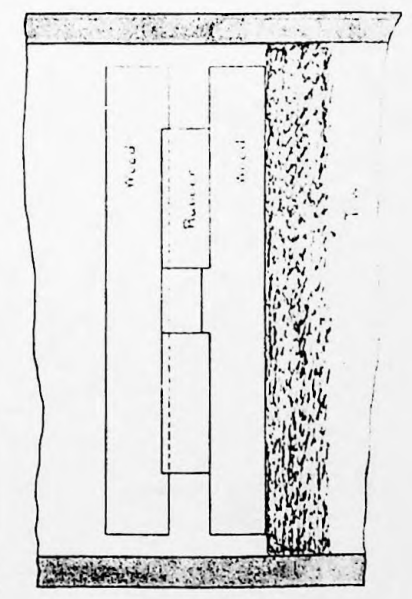
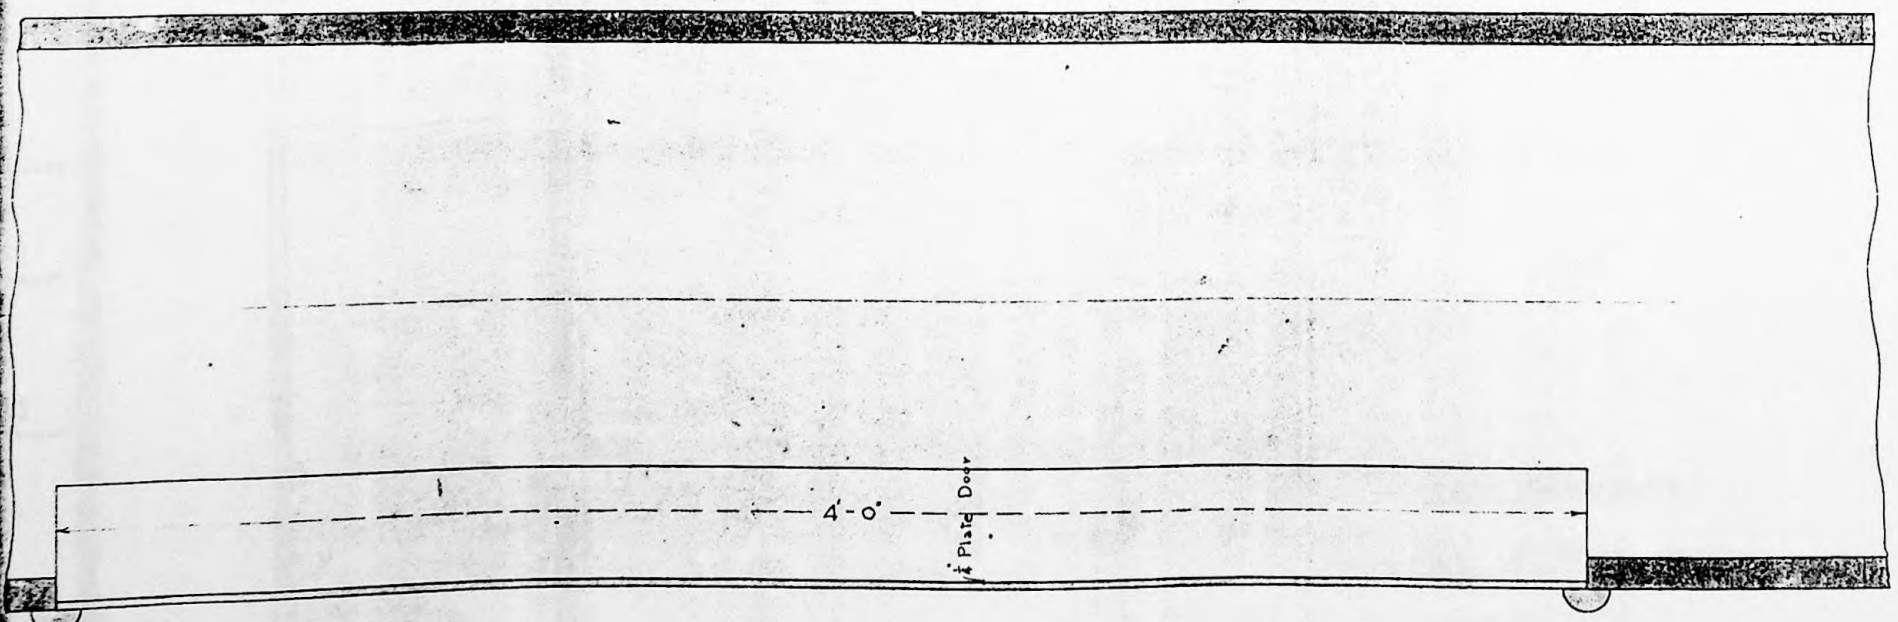
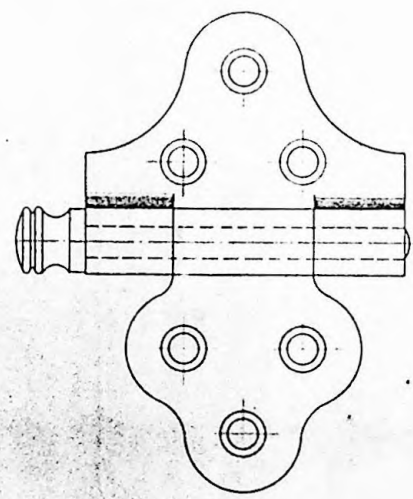
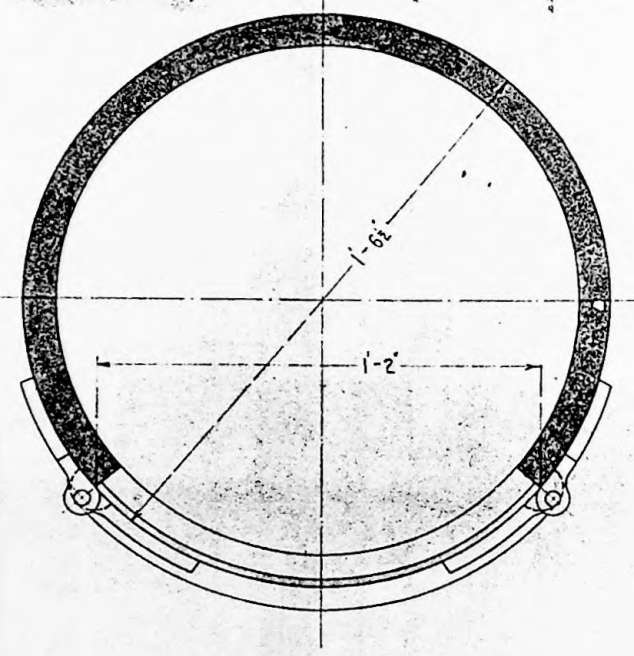
A4

A4

A3

A2

A1



CAPE PEMBUKE LIGHTHOUSE

Details of Door & Buffer in Weight Tube

Scales Full & Half Size

CHANCE BROTHERS
AND CO. LIMITED
LIGHTHOUSE ENGINEERS
NEW BIRMINGHAM

DRAWING NO. C24995

96/48

A0

A1

A2

A3

A4

A3

A2

A1

A0

A0

A1

A2

A3

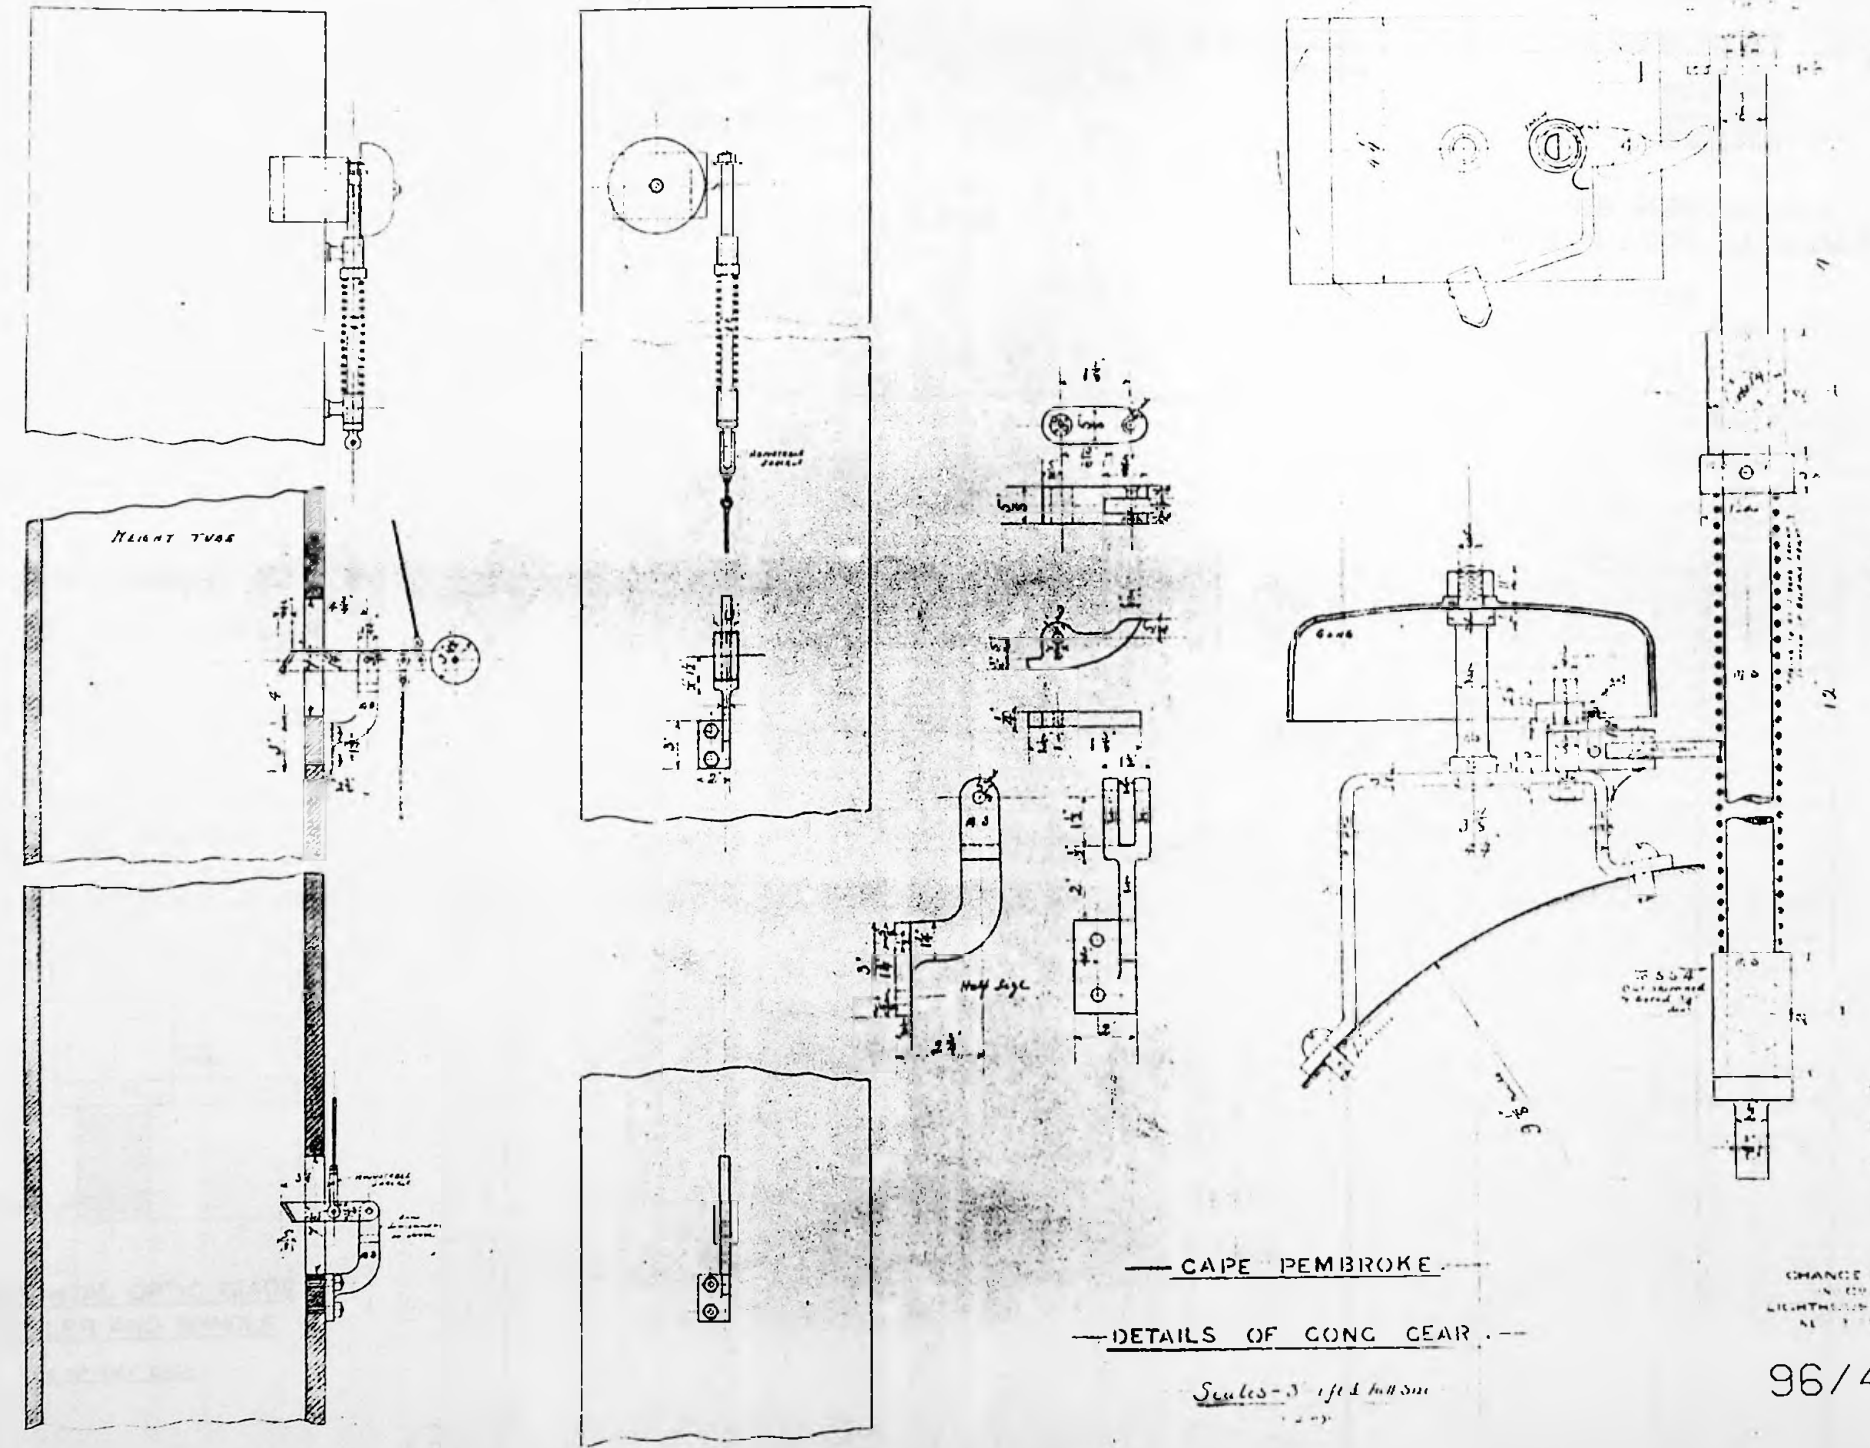
A4

A4

A3

A2

A1



— CAPE PEMBROKE —
— DETAILS OF CONG GEAR —

Scales - 3" = 1 ft & full size

CHANCE BROTHERS & CO. LTD.
LIGHTHOUSE ENGINEERS
NEWCASTLE-ON-TYNE

96/49

DRAWING N. F. 24070

CAPE PEMBROKE LIGHTHOUSE
FALKLAND ISLES.
REPAIRS AND REPLACEMENTS
FOLLOWING ITS SURVEY - 1953.



DRG. N^o. 96/62
612/5. ENGINEER-IN-CHIEF.

A0

A1

A2

A3

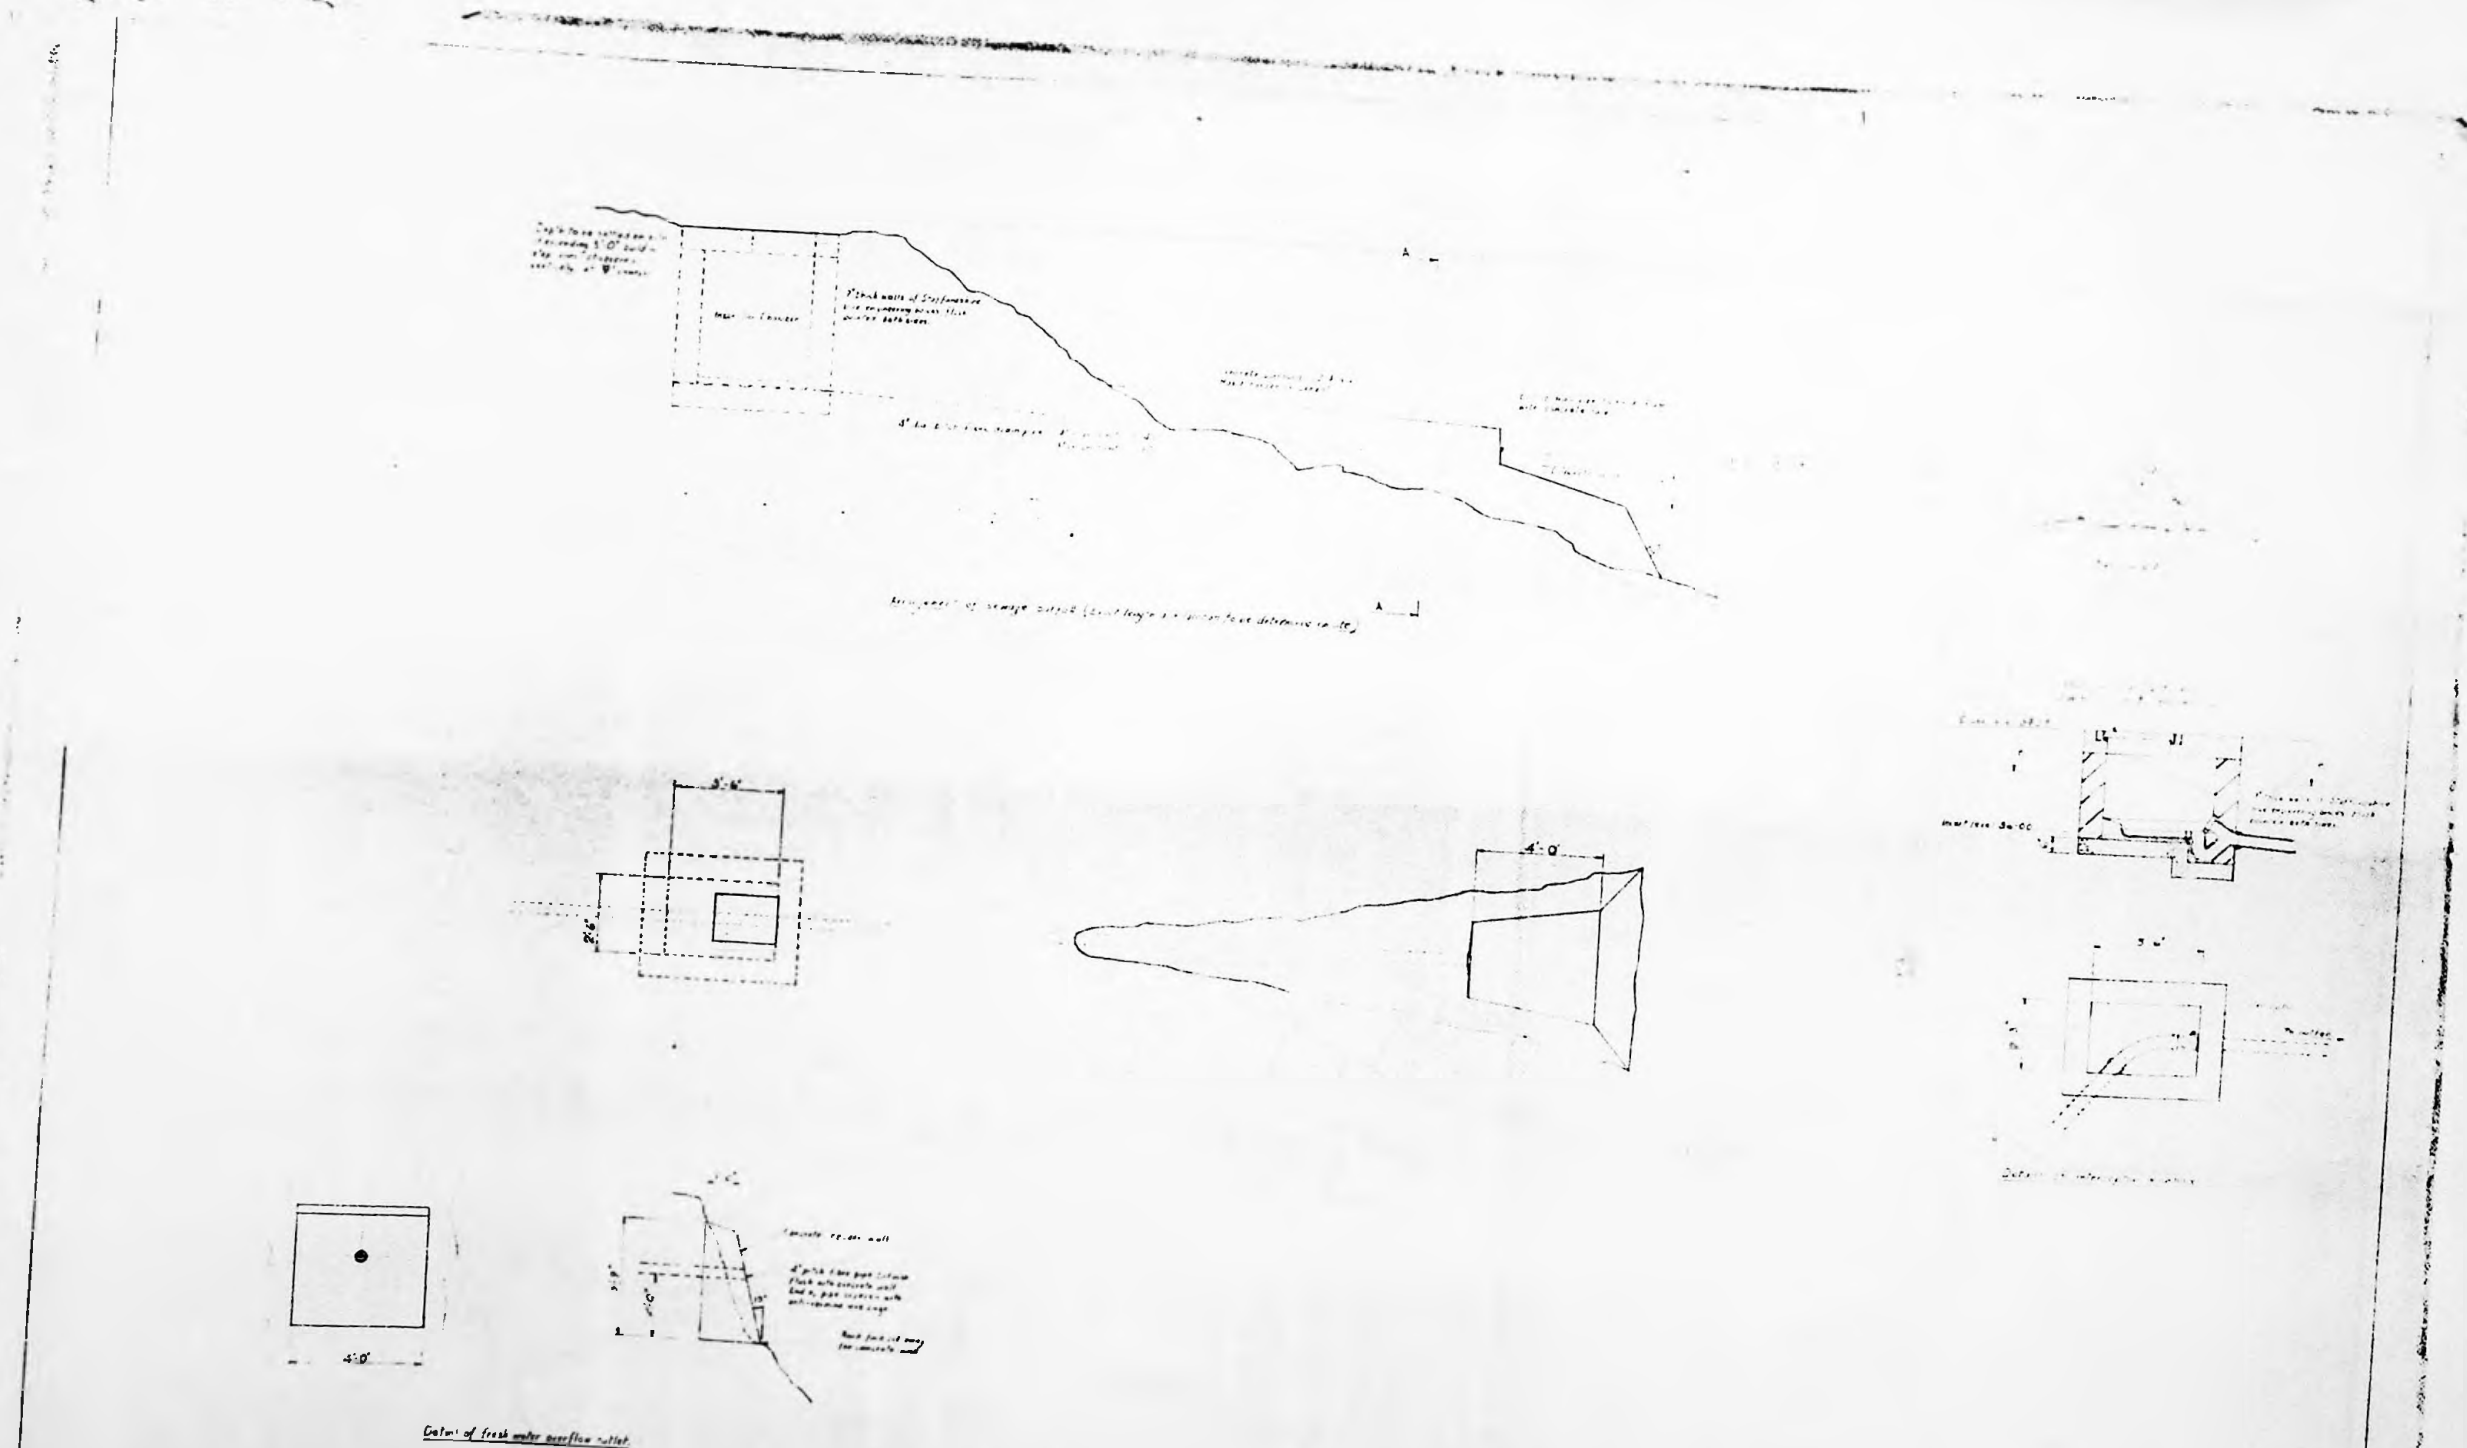
A4

A4

A3

A2

A1



TRINITY HOUSE
ENGINEERS DEPT.

FALKLAND ISLANDS: CAPE PEMBROKE LIGHTHOUSE.
DRAINAGE DETAILS.

96/63

DRWG No.
4127

A0

A1

A2

A3

A4

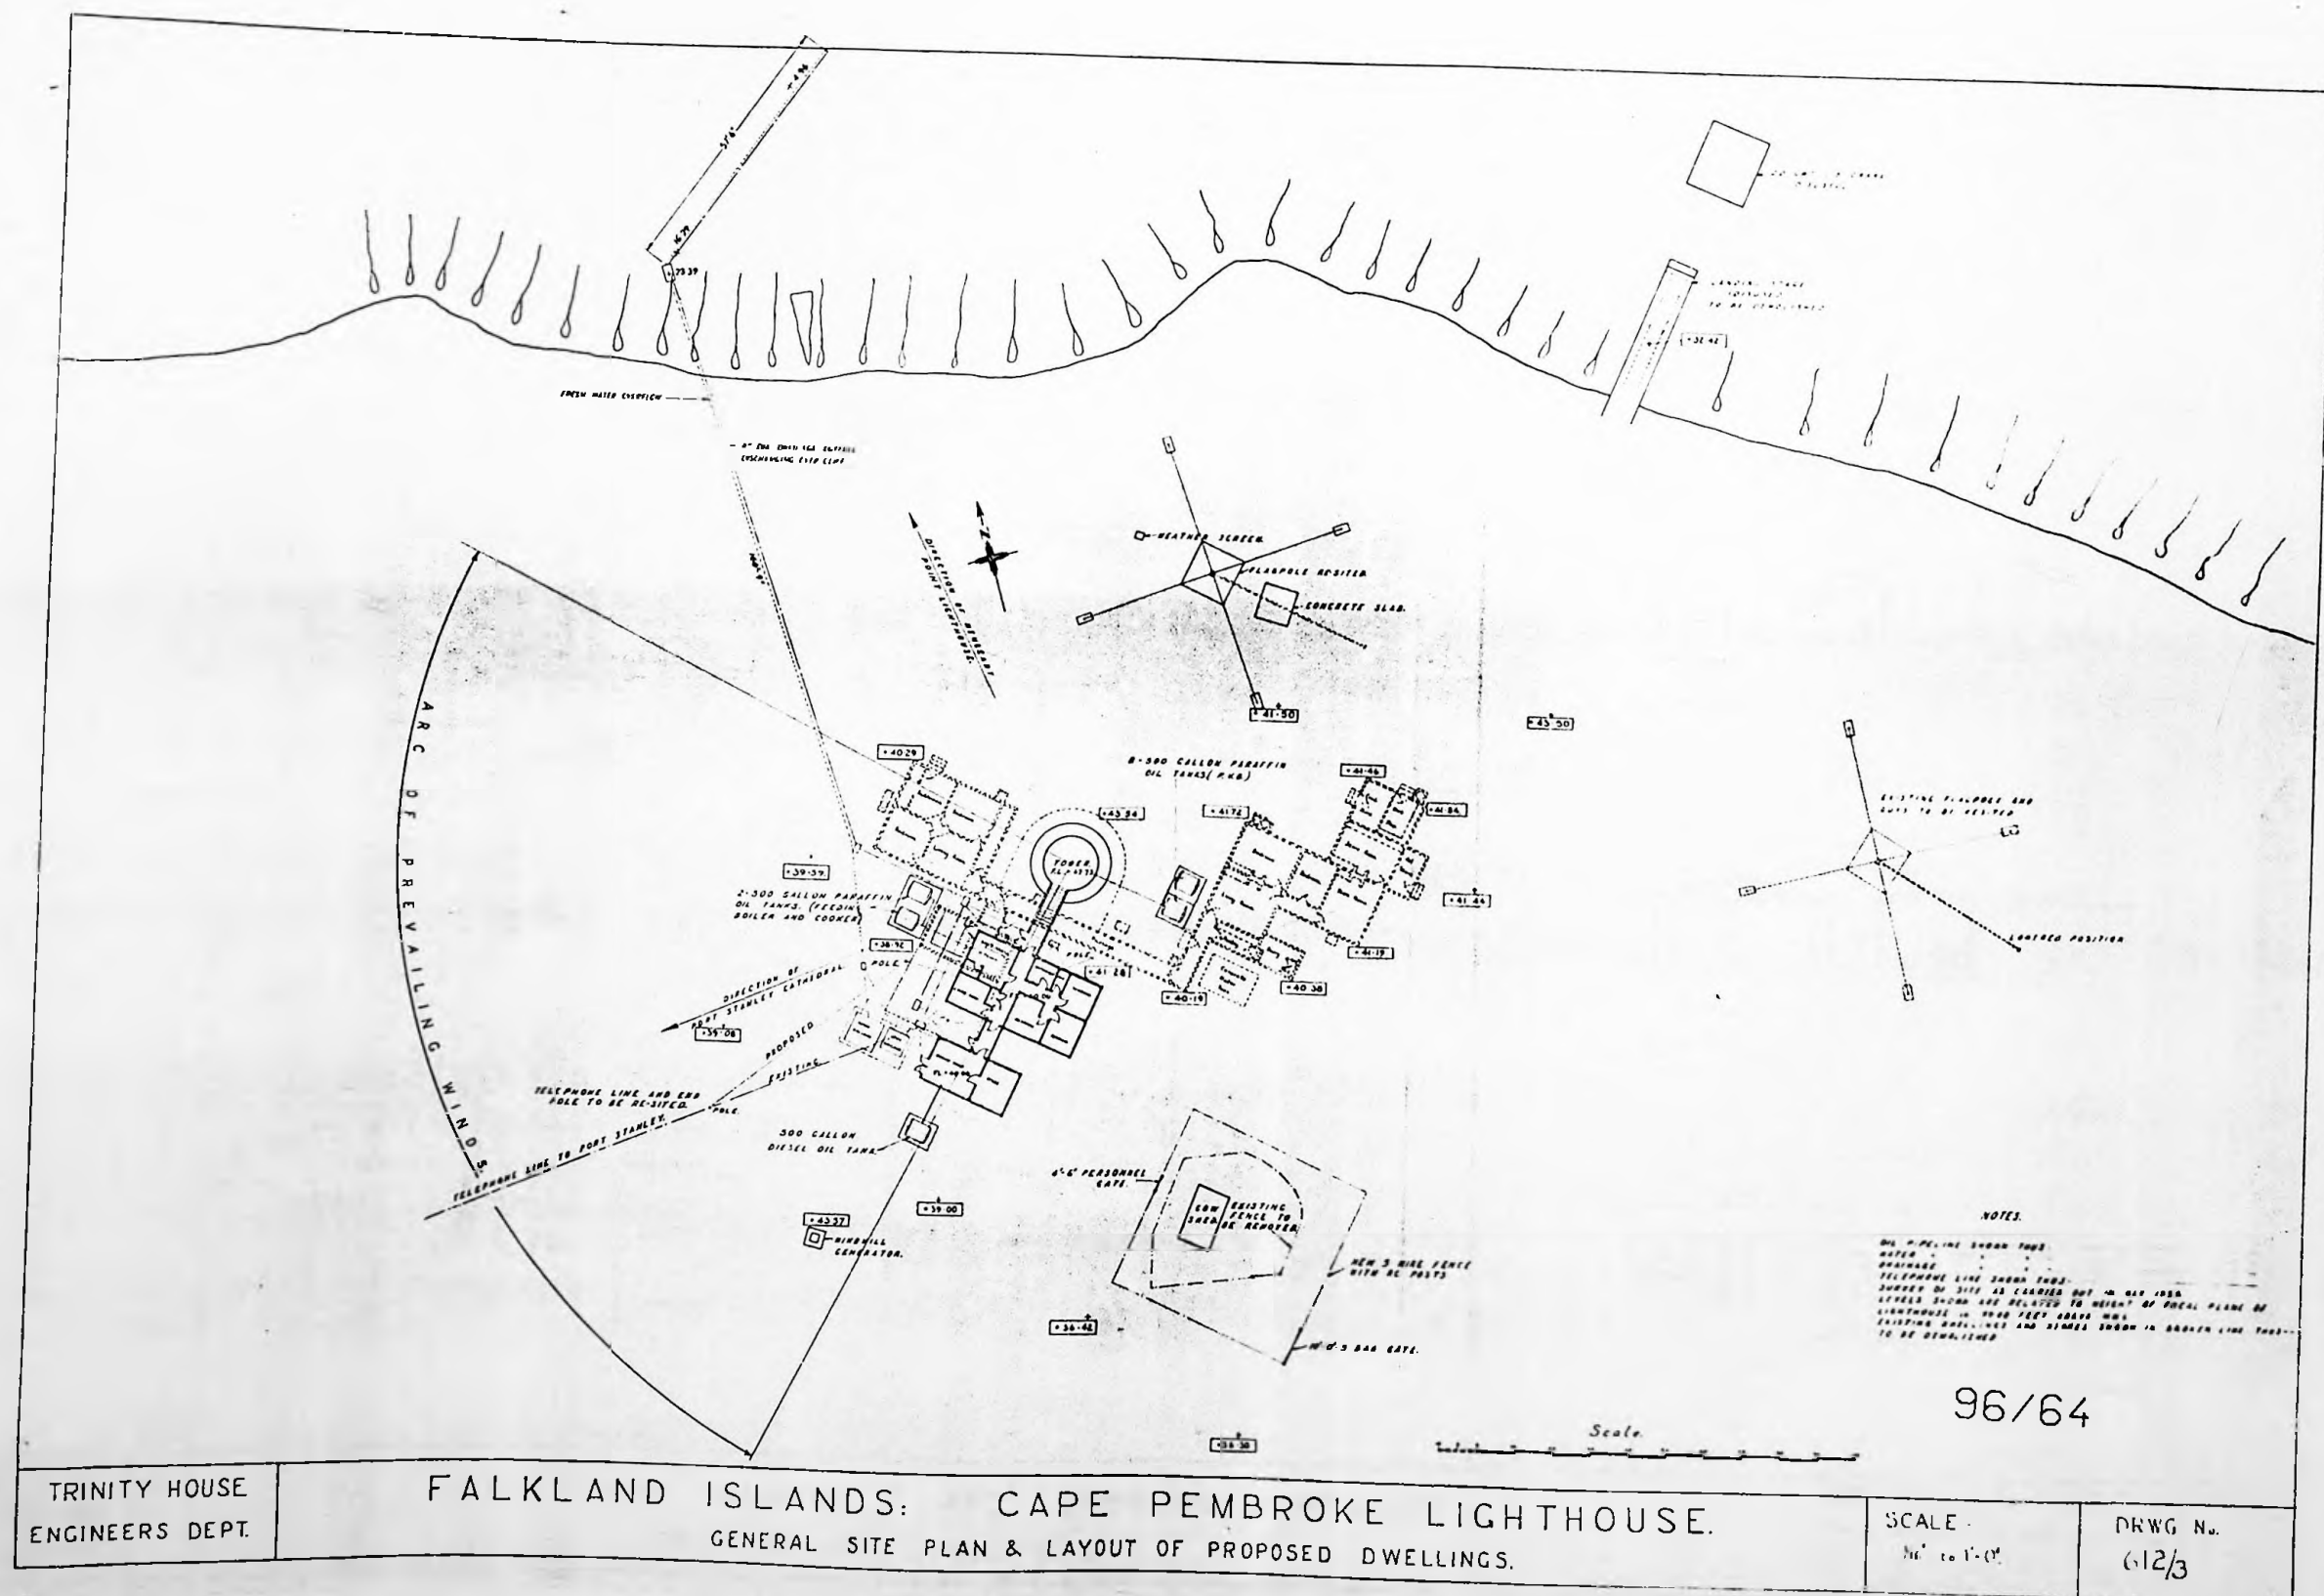
A4

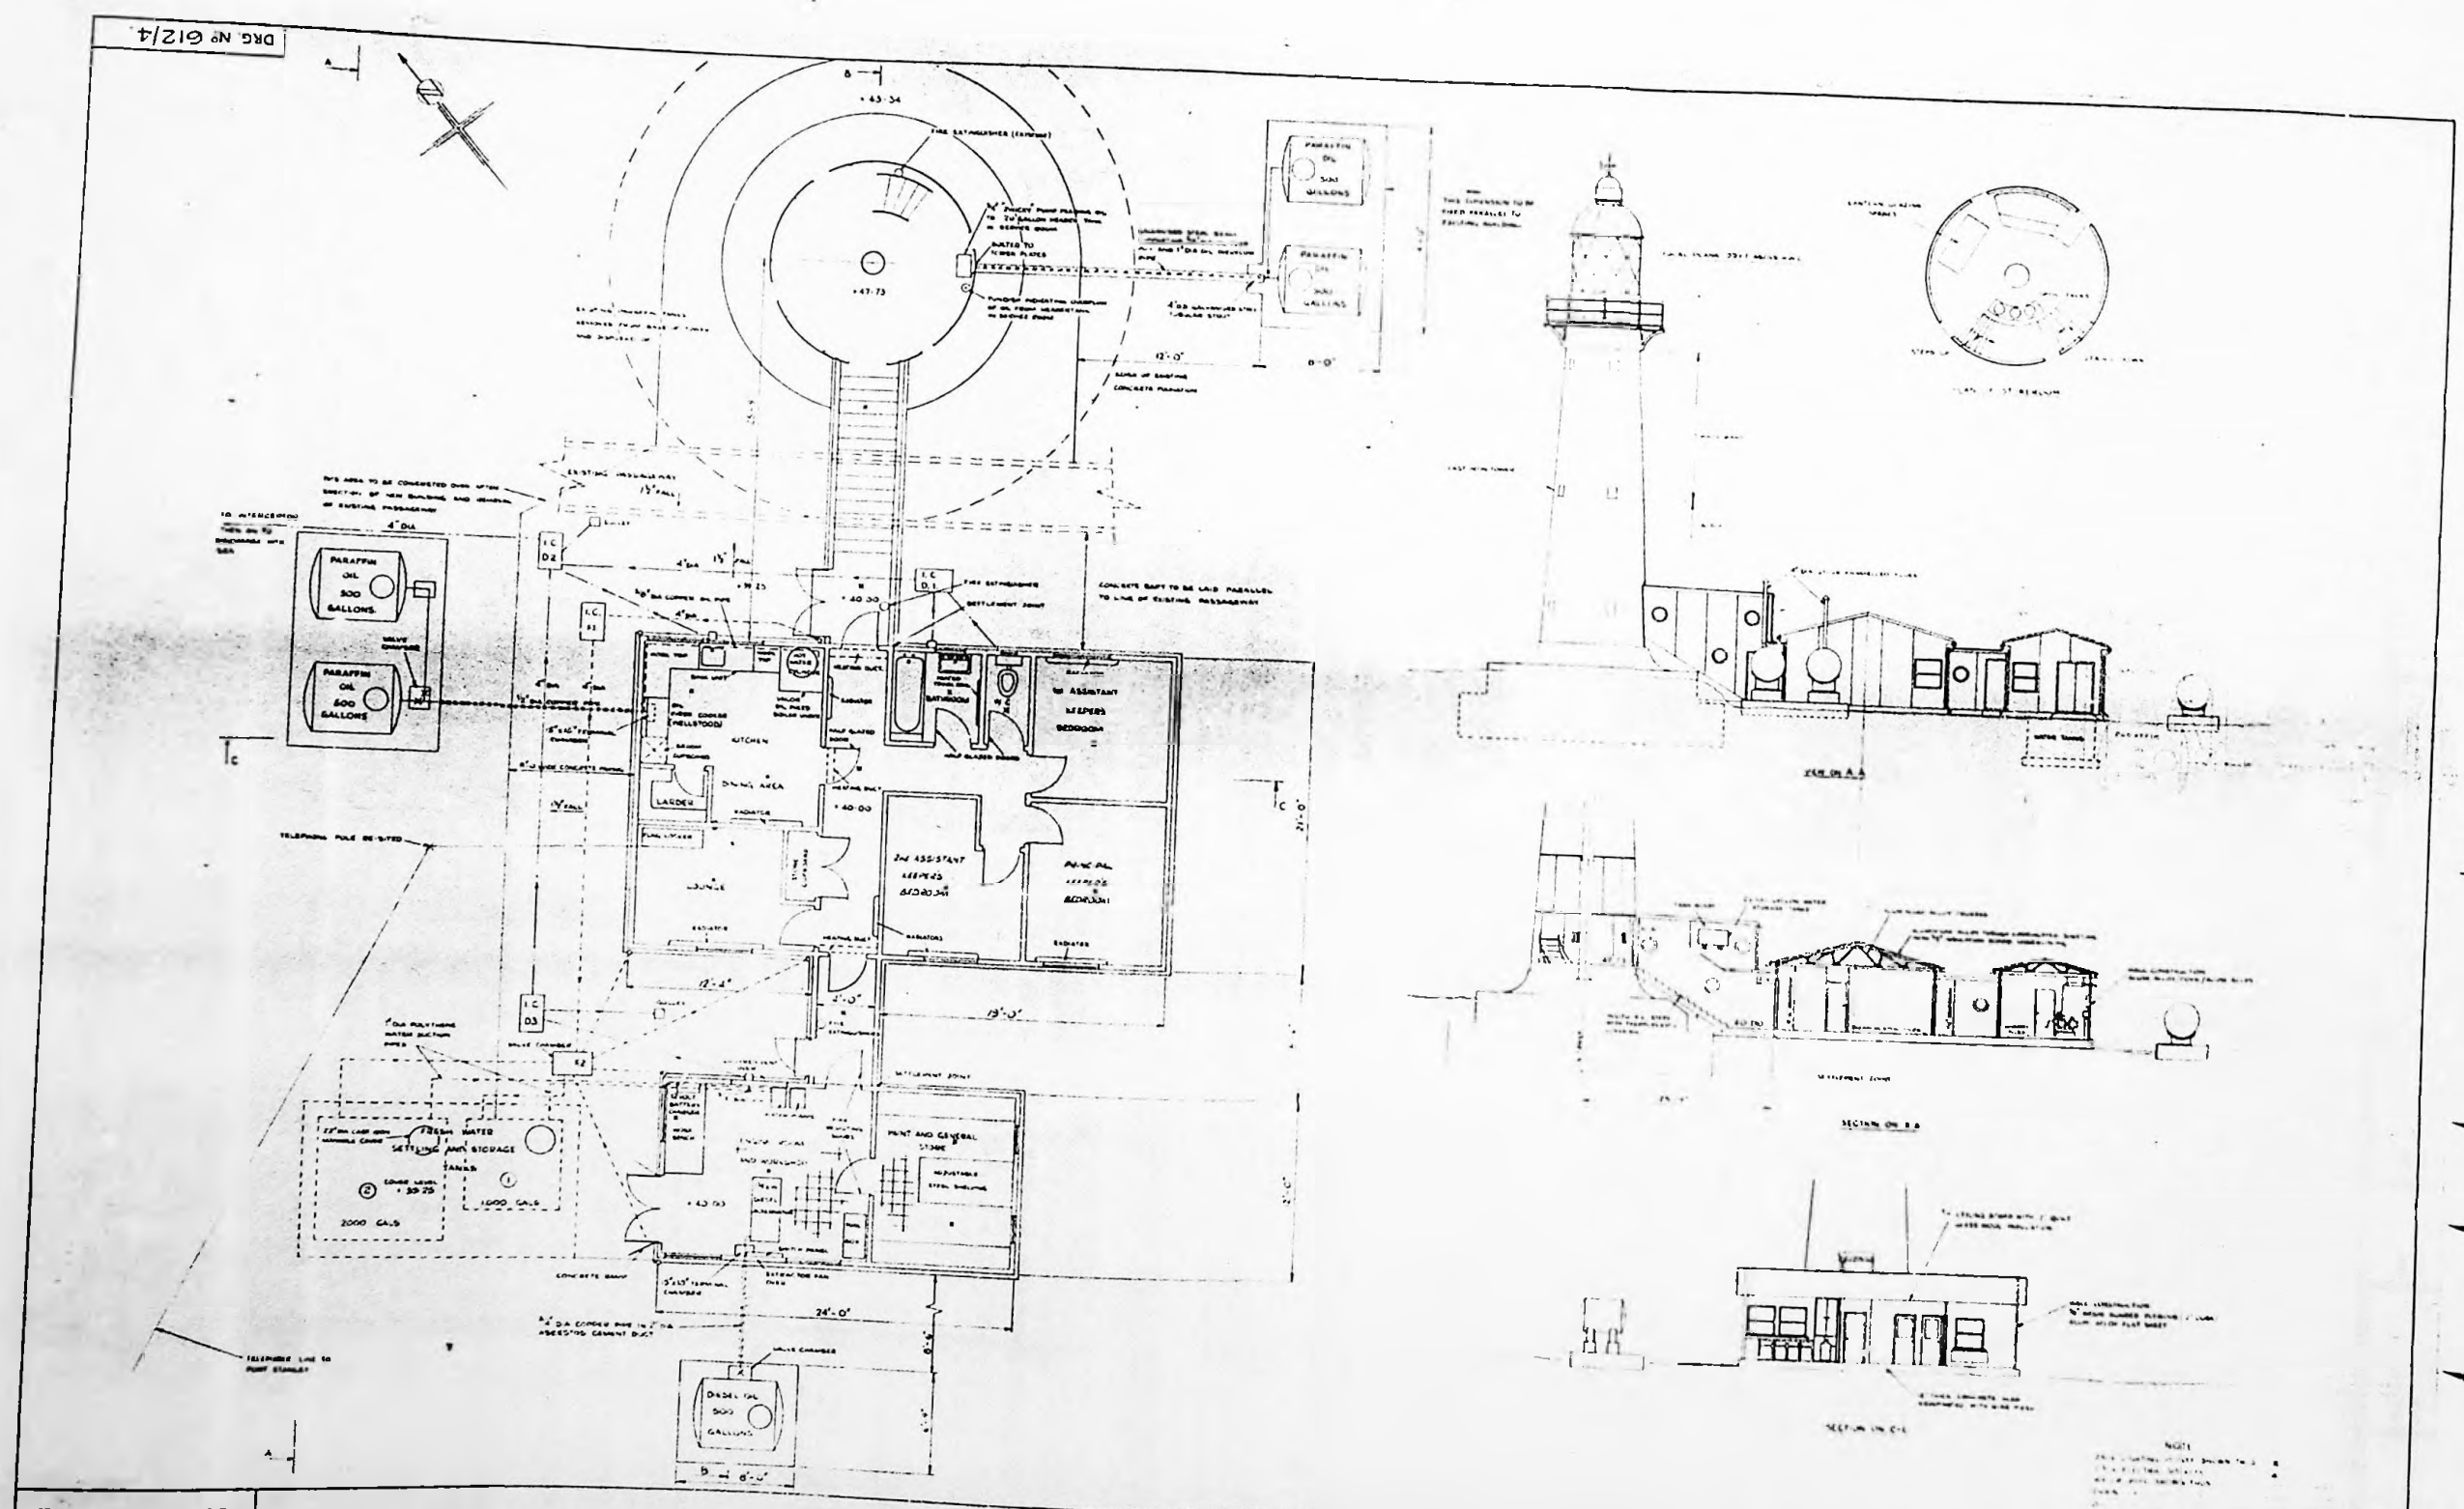
A3

A2

A1

A0





TRINITY HOUSE
ENGINEER-IN-CHIEF'S DEPT
TOWER HILL, LONDON, E.C.3.

FALKLAND ISLANDS . CAPE PEMBROKE LIGHTHOUSE
PROPOSED NEW DWELLINGS.

SCALE	1/4" = 1'-0"	DRAWN BY	A.J.N.	1/6
REVISED BY	H.M.	CHECKED BY		1/6
APPROVED BY				1/6
96/65				
DRG. NO 612/4				

0V

0V

A1

A1

A2

A2

A3

A3

A4

A4

A4

A4

A3

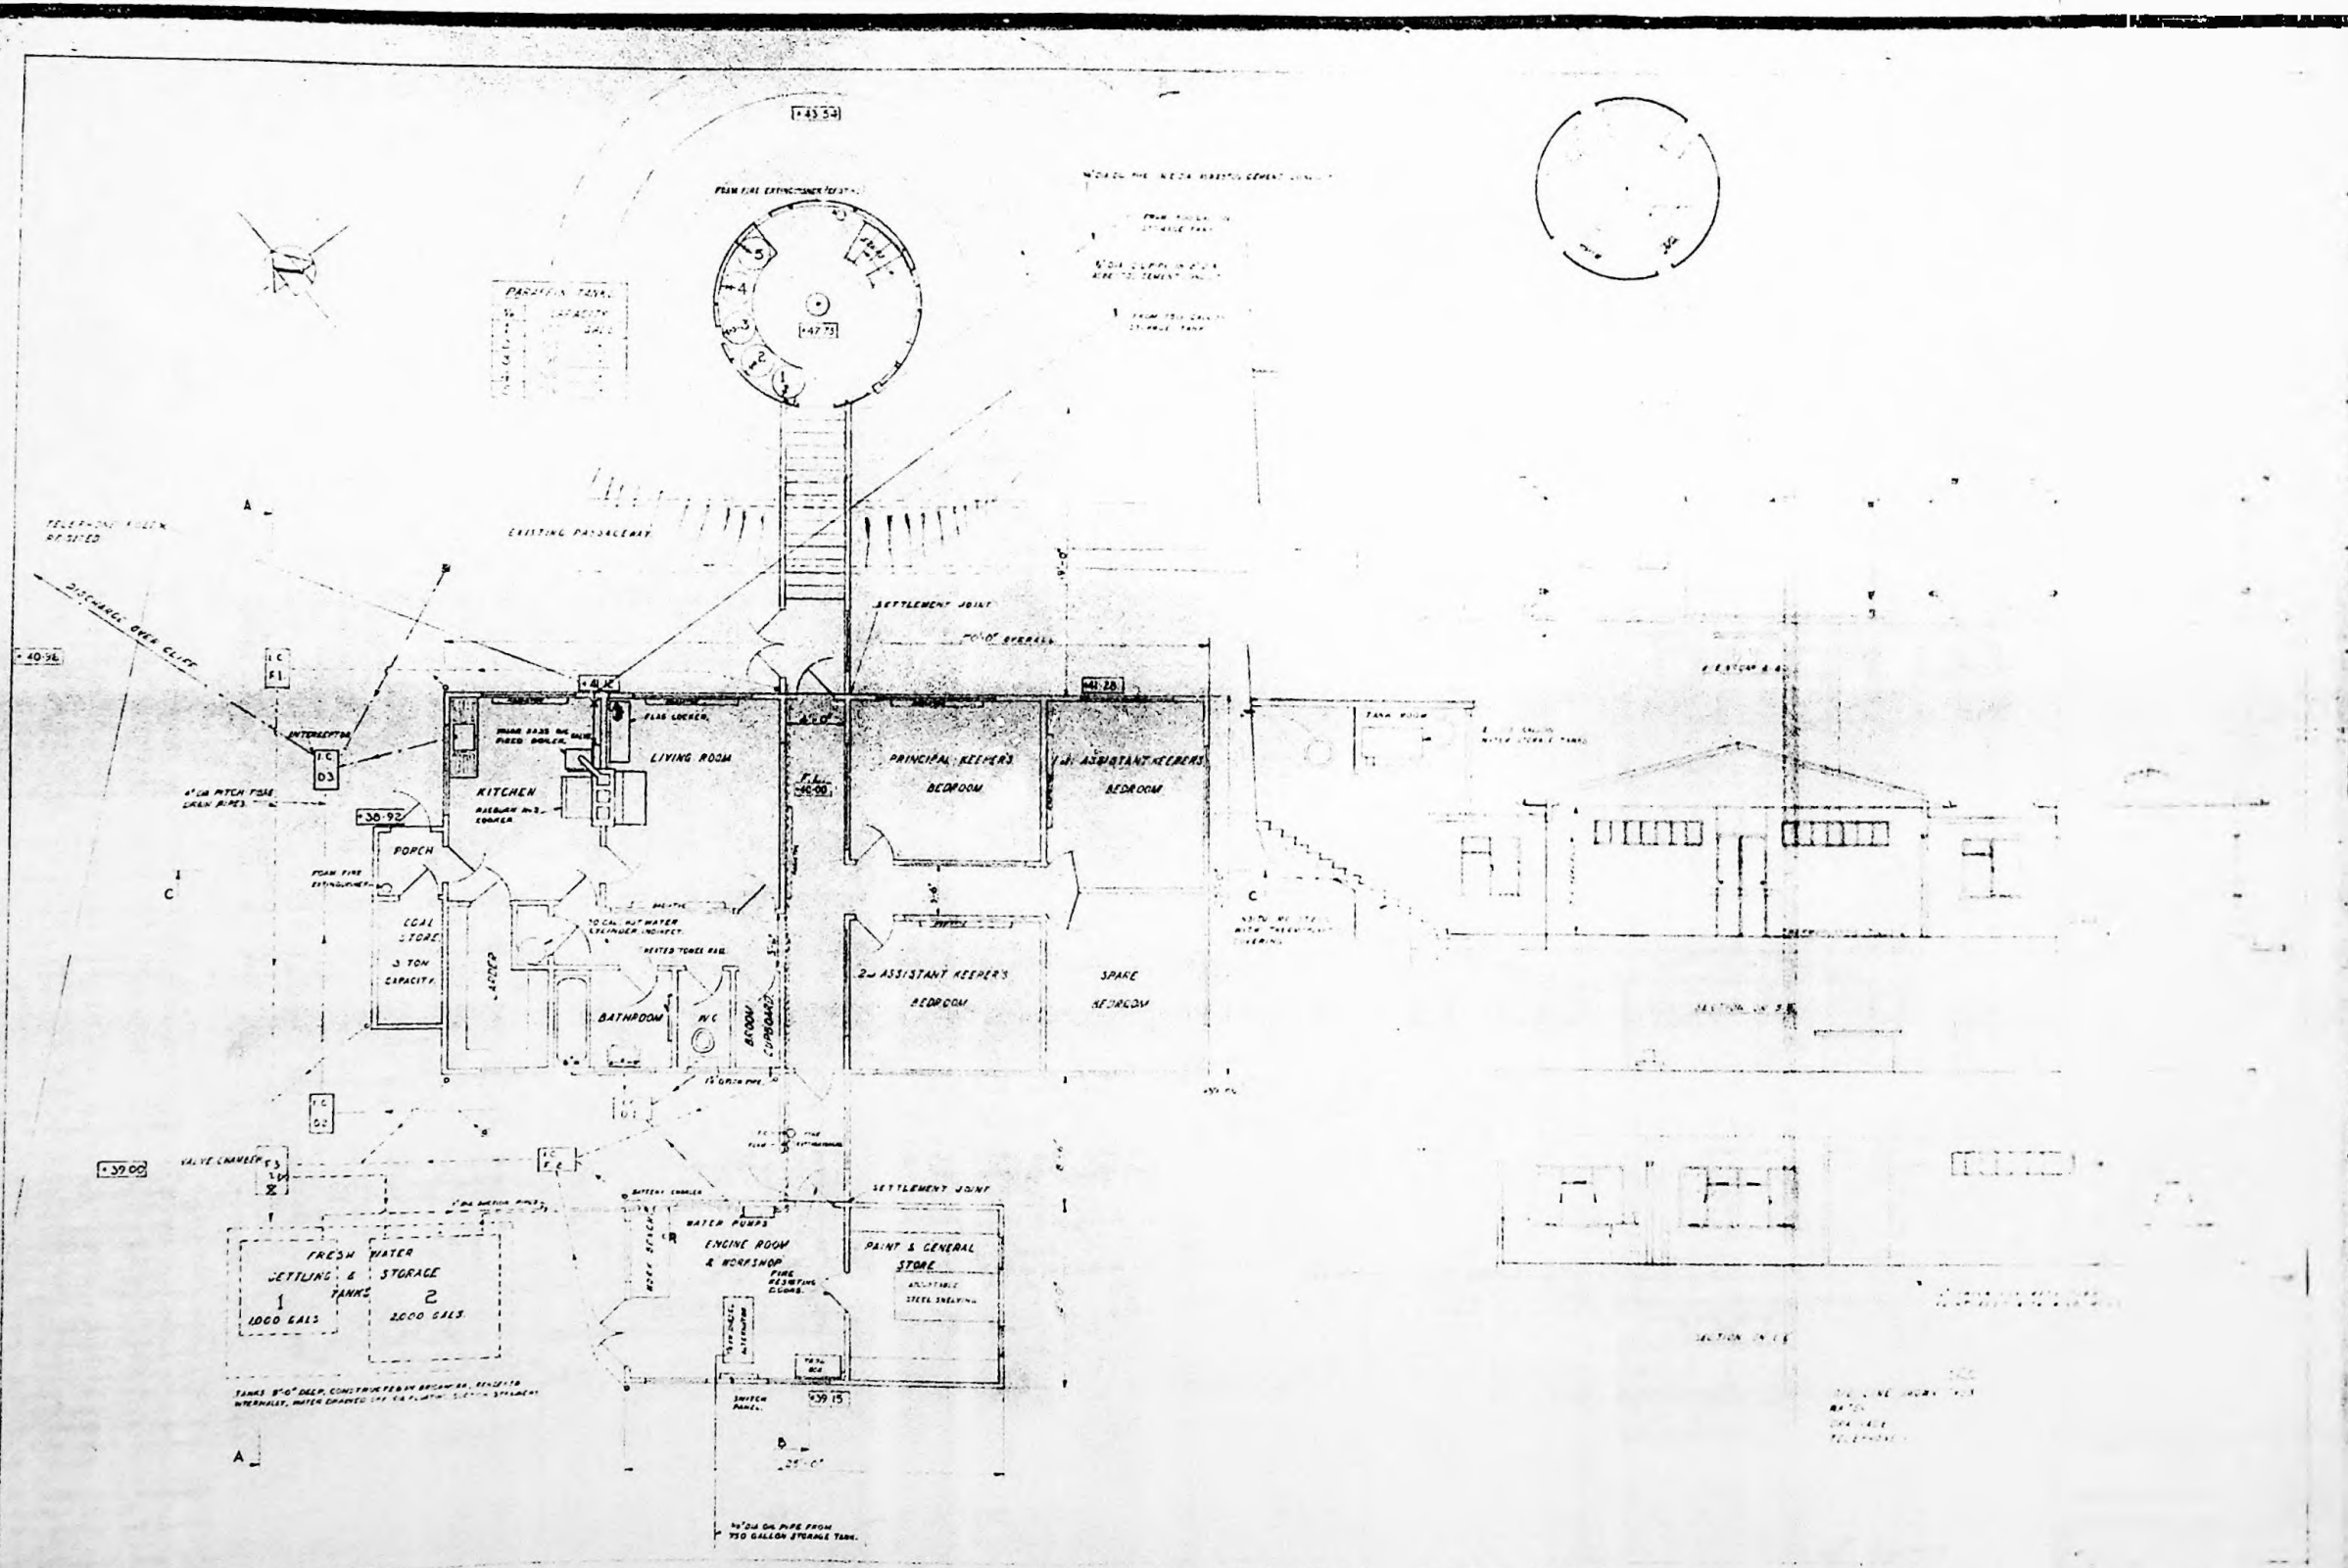
A3

A2

A2

A1

A1





TRINITY HOUSE
ENGINEERS DEPT.


FALKLAND ISLANDS. CAPE PEMBROKE LIGHTHOUSE.
PROPOSED NEW DWELLINGS.

SCALE
1" = 10'

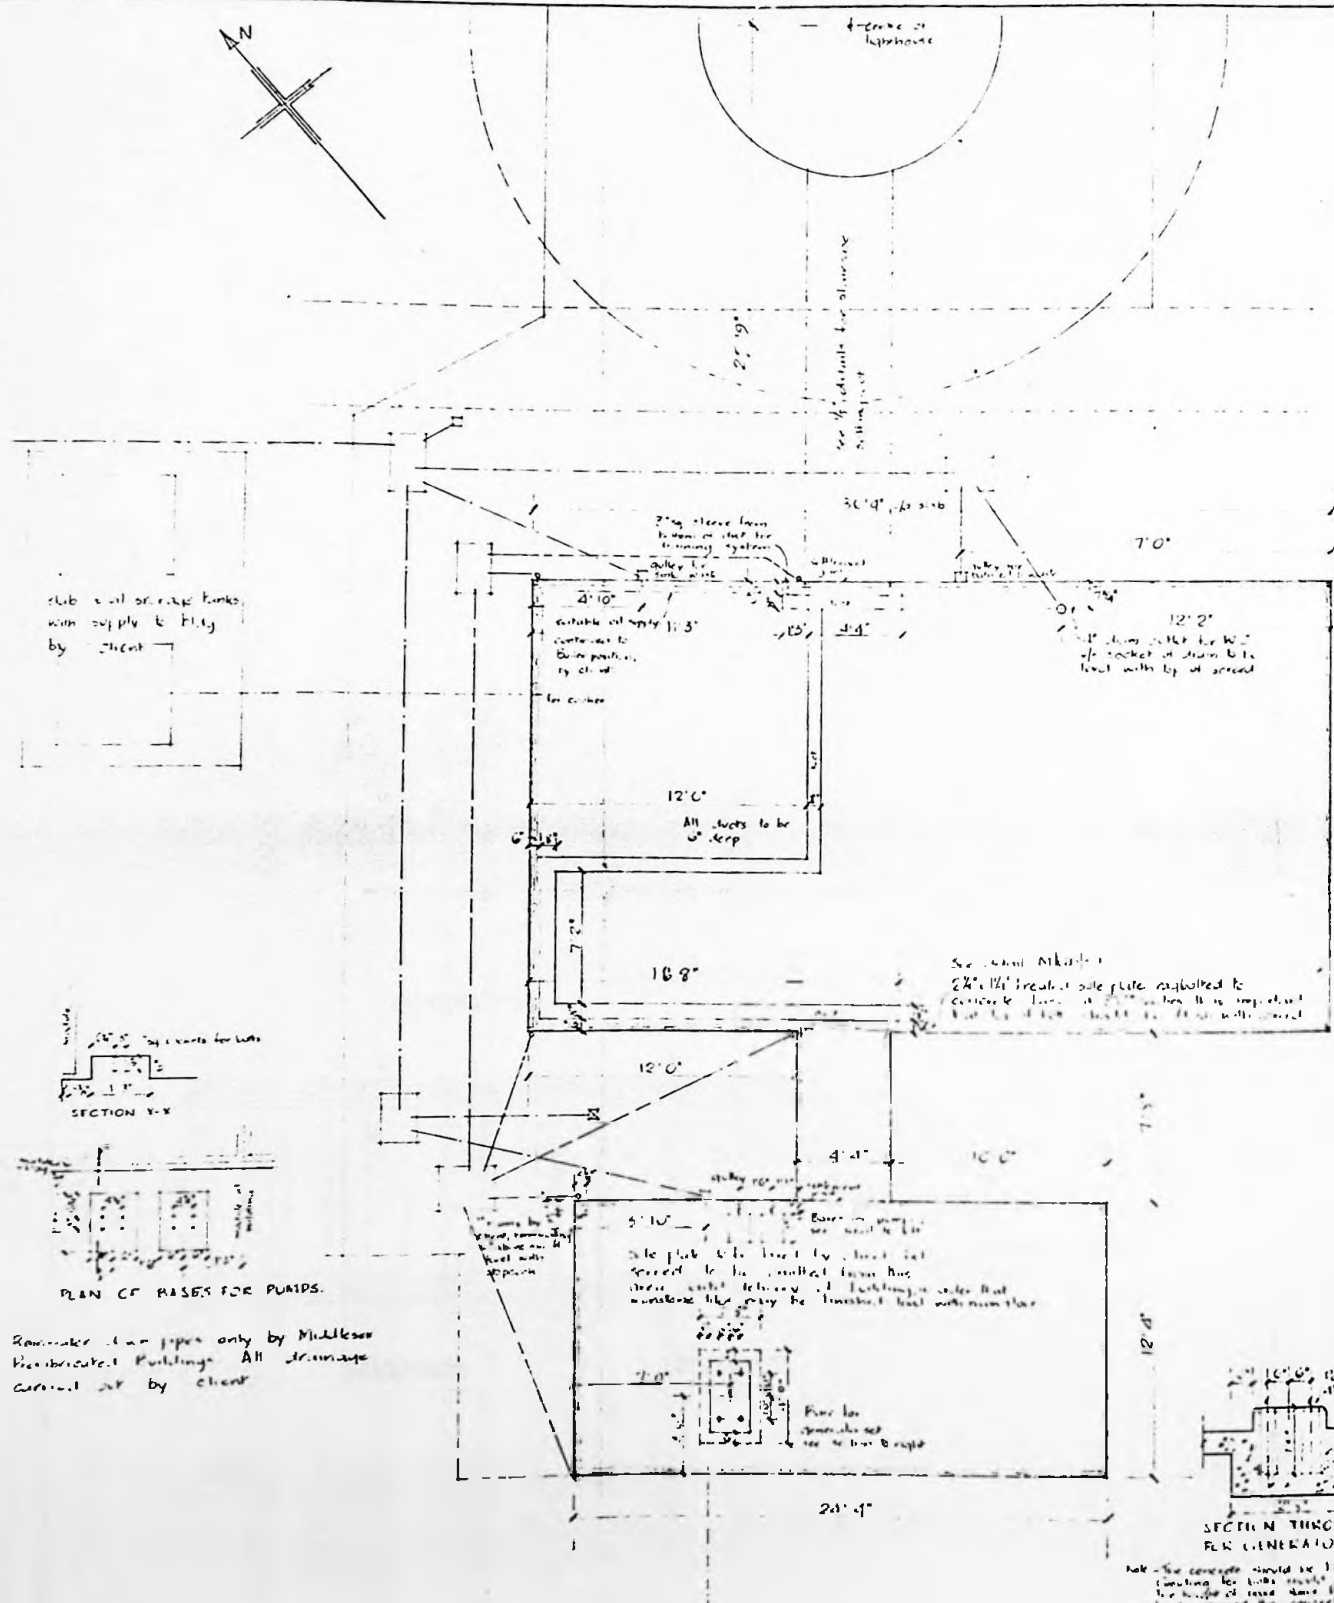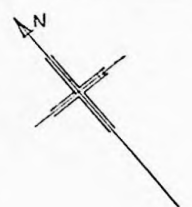96/66



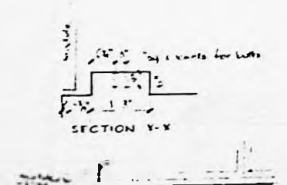slab & all service tanks
water supply to Bldg
by client




PLAN OF BASES FOR PUMPS.

Remember: Run pipes only by Middlesex
Prefabricated Buildings. All drainage
current set by client.

slab & all service
tanks water supply
to Bldg by client.

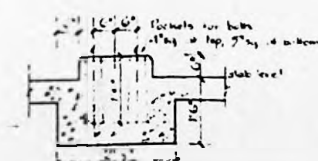
FOUNDATION PLAN




1. The concrete should be 1:2:4
2. The height of base should be 18\"/>



 SECTION A-A



SECTION B-B

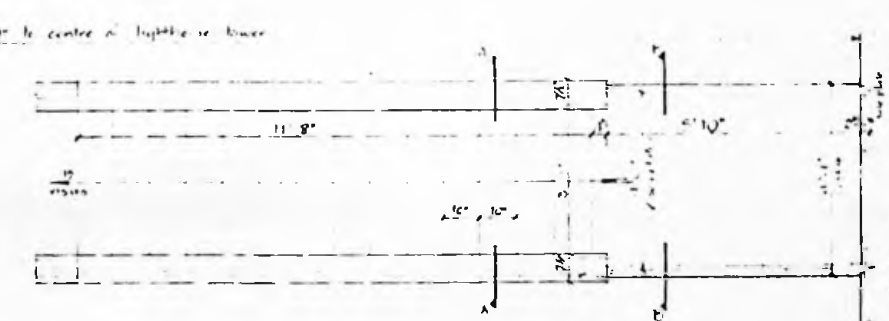


PLAN




SECTION THRU STAIR SLAB

96/68

MIDDLESEX PREFABRICATED BUILDINGS LTD.			
A MEMBER OF THE  INSTITUTION OF MECHANICAL ENGINEERS			
GREEN LANE, HOUNSLOW, MIDDLESEX, ENGLAND			
(Telephone: MDU 7381-7)			
DATE:	Client, JOB & DRAWING TITLE:		
21.8.68	CORPORATION OF TOWN & COUNTRY PLANNING		
SCALE:	PROPOSED NEW TOWN		
1/4" = 1'0"	EWEASTON, FALKLAND ISLANDS		
DRAWING BY:	DETAILS OF CONCRETE SLAB		
MR B	COPYRIGHT RESERVED		
CHECKED BY:	1522	3	E. H.

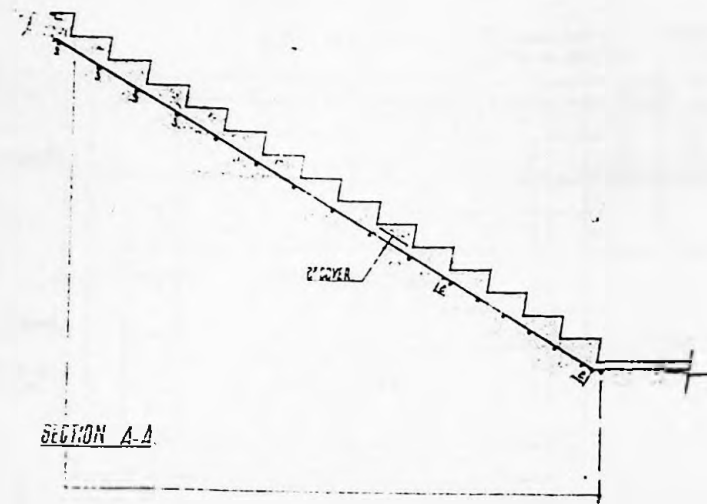

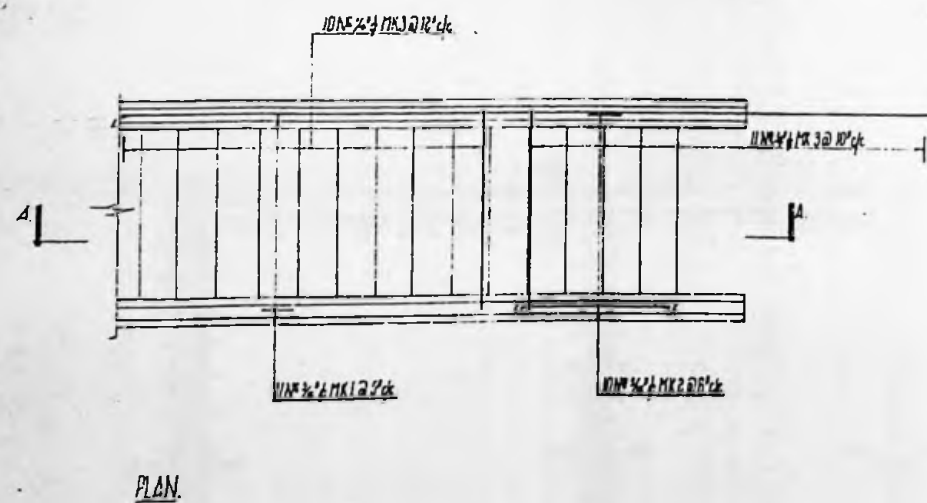NOTE: THIS DWS. TO BE READ IN
CONJUNCTION WITH DWS. 612/6



96/69

THIS DRAWING IS THE COPYRIGHT DESIGN OF THE SQUARE GRIP CO., AND MUST NOT BE TRACED OR USED FOR ANY OTHER PURPOSE THAN THAT SPECIFIED HEREON.


SCALE 1/8" = 1'-0"	
DRAWN BY	DATE
CHECKED BY	DATE
DATE	DATE
DWG. No.	2

CAPE PEMBROKE LIGHTHOUSE.
STAIRCASE TO TOWER.


ENGINEERS DEPT. TRINITY HOUSE

THIS DESIGN HAS BEEN BASED ON CONCRETE MIX AGGREGATES AS B.S. No. 882
MINIMUM CUBE STRENGTH TO BE 1500 LBS. PER SQUARE INCH AT 28 DAYS.
CONCRETE COVER TO STEEL TO BE — 2" SLABS BEAMS COLUMNS FOUNDATIONS
FABRIC NEAR BOTTOM OF SLAB SHEWN IN FULL LINES AND LETTERED THUS 
FABRIC NEAR TOP OF SLAB SHEWN IN DOTTED LINES AND NUMBERED THUS 

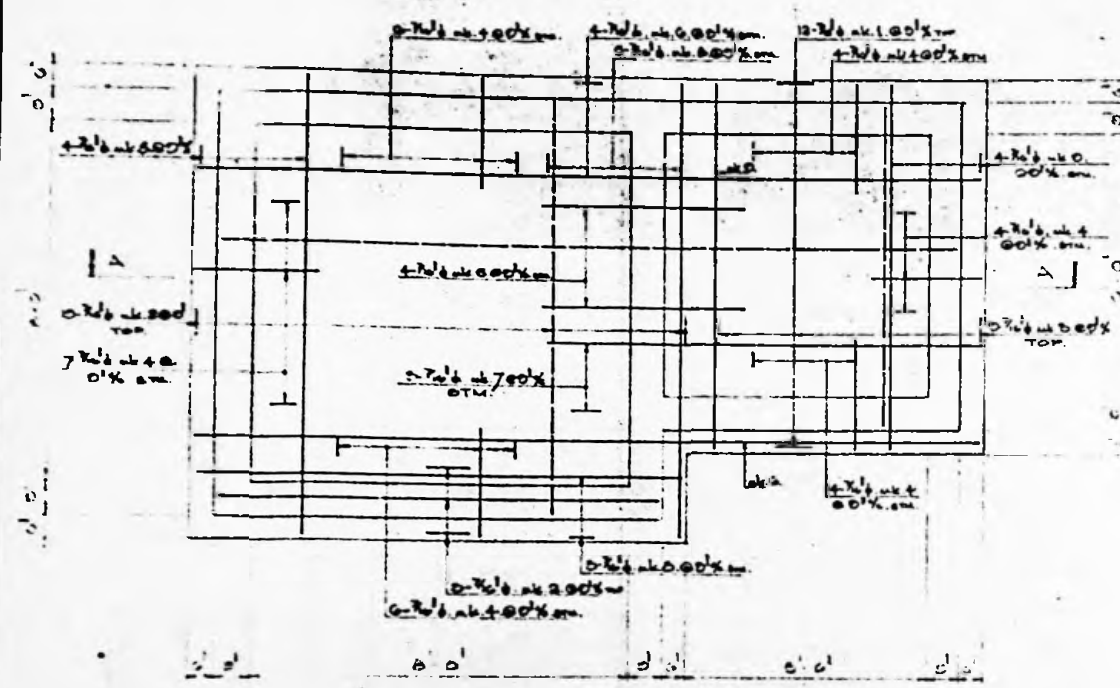
THE
SQUARE GRIP
REINFORCEMENT DESIGNS LTD.
RELIANCE 4944
BONDWAY HOUSE,
BONDWAY, VAUXHALL,
LONDON, S.W.8.




BASE SLAB PLAN

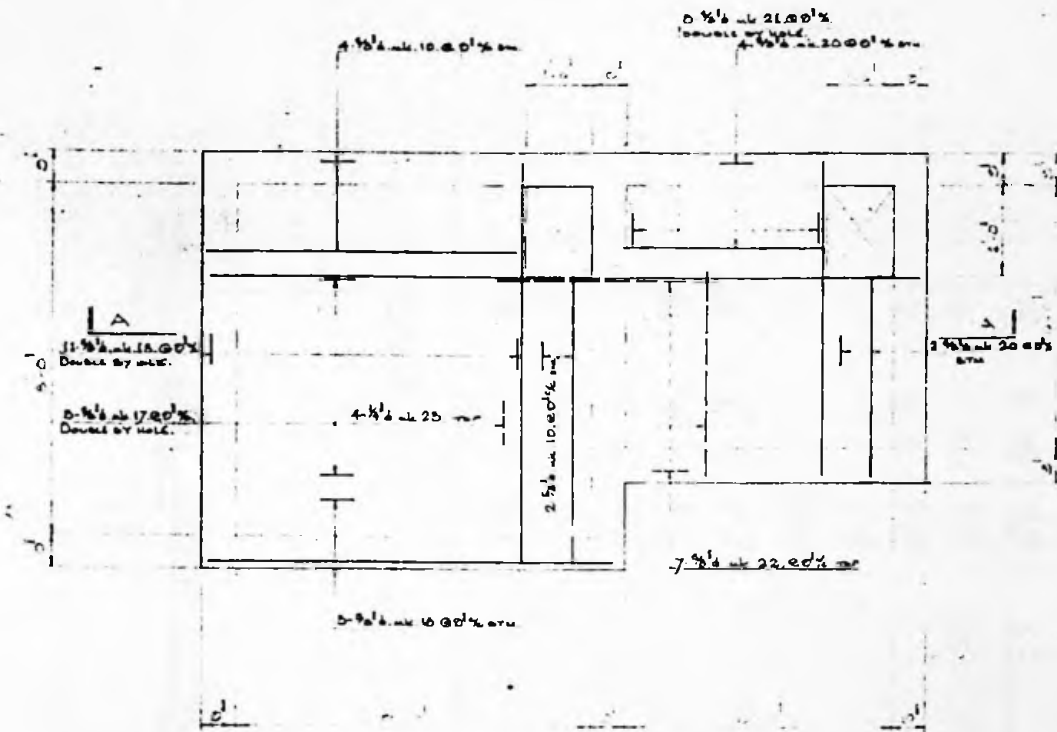

200mm SLAB PLAN

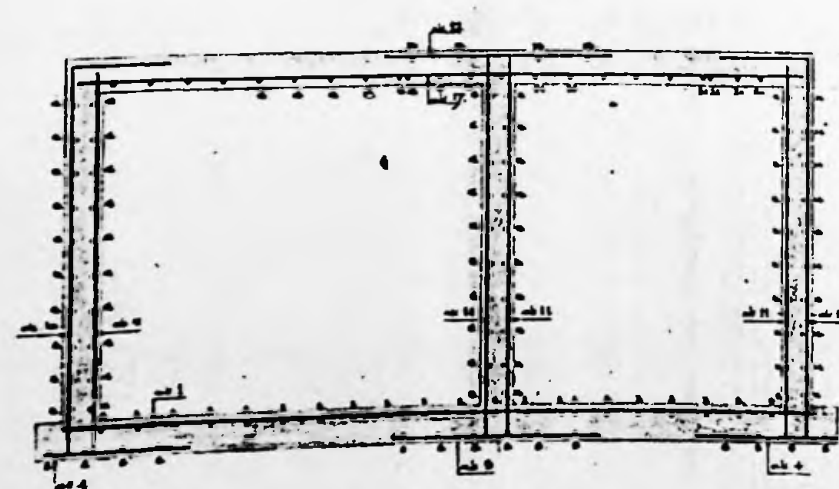

CROSS SECTION

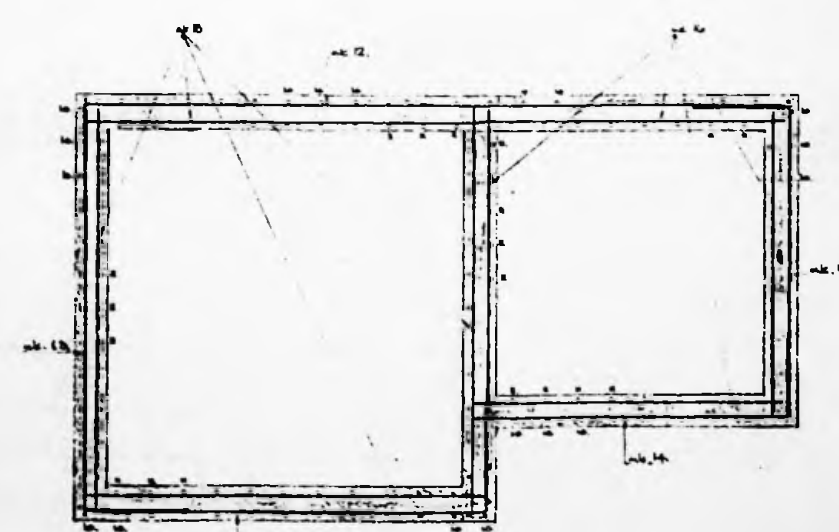

DRG No F1/24.

96/70

DRG No F1/24.

THIS DRAWING IS THE COPYRIGHT DESIGN OF THE SQUARE GRIP CO. AND MUST NOT BE TRACED OR USED FOR ANY OTHER PURPOSE THAN THAT SPECIFIED HEREON

SCALE	REVISIONS
1" = 1'-0"	
DATE	
BY	
CHECKED BY	
DATE	

CAPE DENBROOKE LTD
FALKLAND ISLANDS
FRESH WATER TANK

THIS DESIGN HAS BEEN BASED ON
CONCRETE MIN AGGREGATES AT 85% MIN. REL.
MINIMUM CUBE STRENGTH TO BE 1500 PSI PER SQUARE INCH AT 28 DAYS
CONCRETE COVER TO STEEL TO BE - 2" SLABS BEAMS COLUMNS FOUNDATIONS
FABRIC NEAR BOTTOM OF SLAB SHOWN IN FULL LINES AND LETTERED THUS
FABRIC NEAR TOP OF SLAB SHOWN IN DOTTED LINES AND NUMBERED THUS

THE
SQUARE GRIP
REINFORCEMENT DESIGNS LTD
ALLIANCE STRA
BURNWAT HOUSE
BOALWAT VAUGHALL
LONDON E16 8WS

THE SQUARE GRIP REINFORCEMENT CO. (INCORPORATED) LTD.

Cape Pembroke Light House					
Fresh Water Tanks					
Bar No.	Size	Length	Weight	Remarks	
14	3/8"	20	3'-3"		
15	3/8"	40	3'-0"	Str.	
16	3/8"	4	7'-0"		
17	3/8"	6	15'-9"		
18	3/8"	14	12'-0"		
19	3/8"	6	6'-6"		
20	3/8"	6	4'-6"		
21	3/8"	6	7'-0"		
22	3/8"	7	3'-0"		
23	3/4"	4	4'-6"		

label all bars 1/

THE SQUARE GRIP REINFORCEMENT CO. (INCORPORATED) LTD.


Cape Pembroke Light House					
Fresh Water Tanks					
Bar No.	Size	Length	Weight	Remarks	
1	3/8"	12	16'-3"	St.	
2	3/8"	18	9'-6"		
3	3/8"	9	10'-0"		
4	3/8"	31	2'-6"		
5	3/8"	4	4'-6"		
6	3/8"	5	17'-0"		
7	3/8"	3	9'-6"		
8	3/8"	12	10'-3"		
9	3/8"	5	8'-3"		
10	3/8"	70	12'-4"		
11	3/8"	76	10'-3"		
12	3/8"	10	18'-0"		
13	3/8"	20	11'-9"		

label All bars 1/

Cape Pembroke Light House					
Fresh Water Tanks					
Bar No.	Size	Length	Weight	Remarks	
1	3/8"	12	16'-3"	St.	
2	3/8"	18	9'-6"		
3	3/8"	9	10'-0"		
4	3/8"	31	2'-6"		
5	3/8"	4	4'-6"		
6	3/8"	5	17'-0"		
7	3/8"	3	9'-6"		
8	3/8"	12	10'-3"		
9	3/8"	5	8'-3"		
10	3/8"	70	12'-4"		
11	3/8"	76	10'-3"		
12	3/8"	10	18'-0"		
13	3/8"	20	11'-9"		

D/C No 96/71

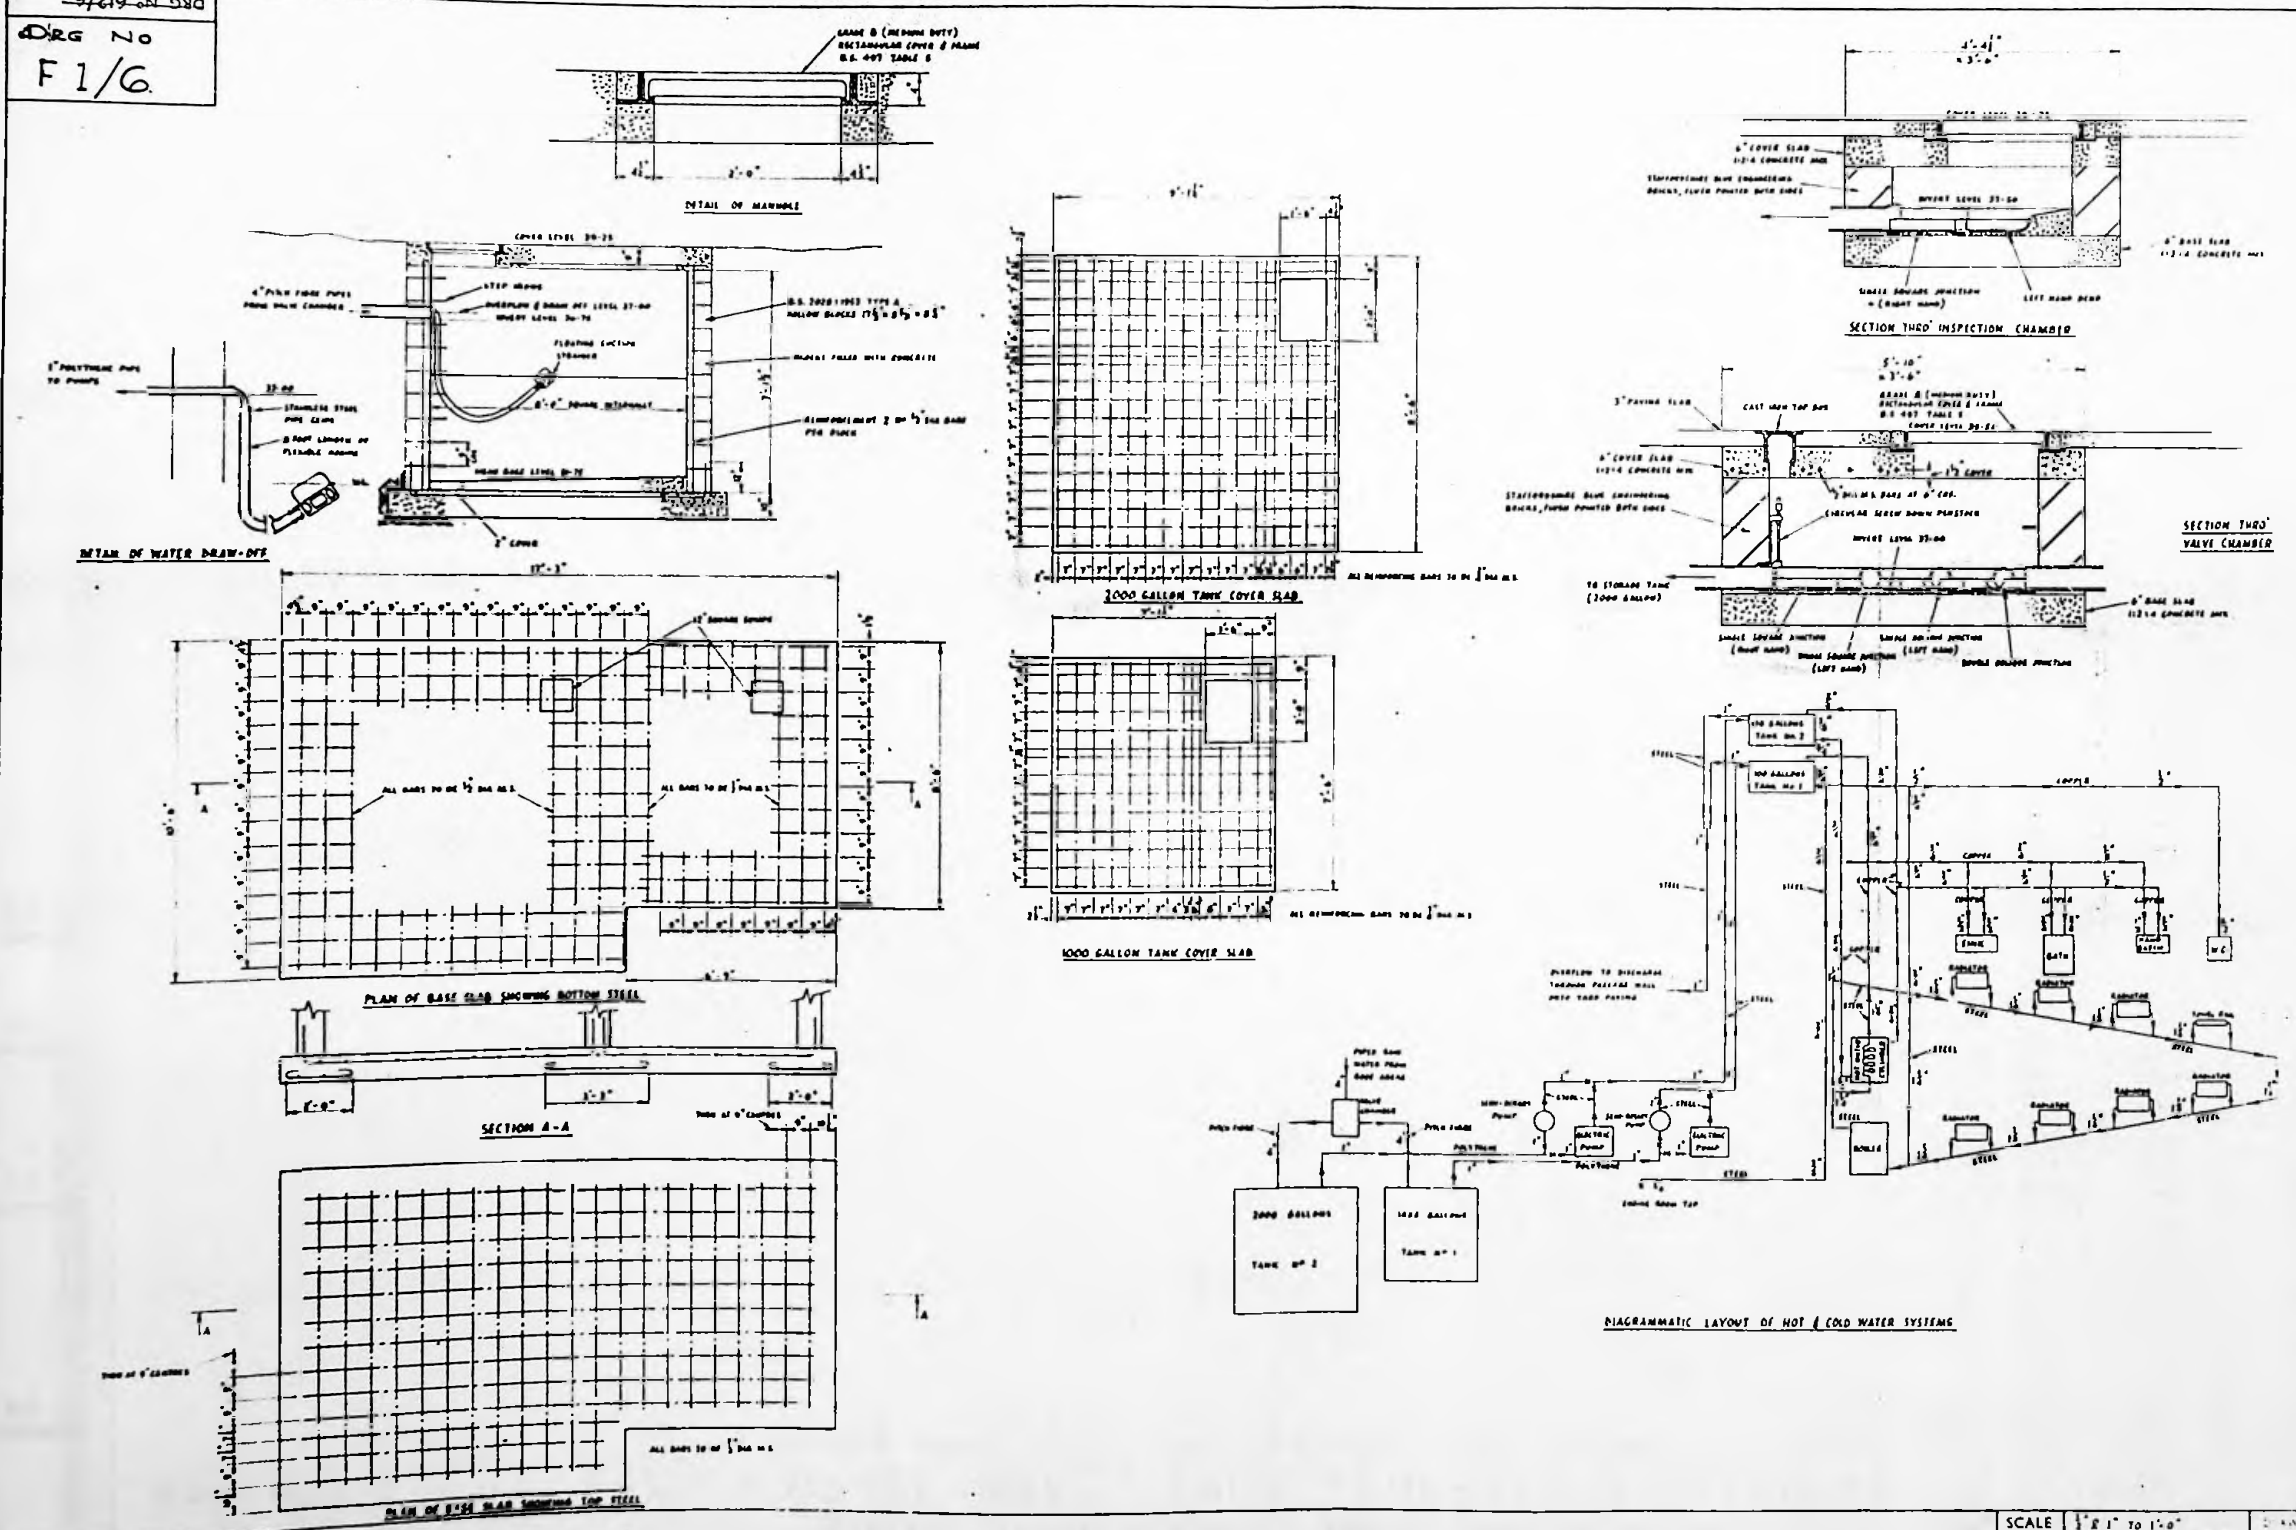9/219-24 DND
 DRG NO
 F1/G



TRINITY HOUSE
 ENGINEER-IN-CHIEF'S DEPT
 TOWER HILL LONDON E.C.1

FALKLAND ISLANDS: CAPE PEMBROKE LIGHTHOUSE
 DETAILS OF FRESH WATER TANKS & CHAMBERS & PLUMBING DIAGRAM

SCALE 1/8" = 1'-0"
 AMENDMENTS
 REV. 1 TRACED N.E.M. 24-6-67
 96/72
 DRG. NO. F1/G

0V

A1

A2

A3

A4

A4

A3

A2

A1

0V

A1

A2

A3

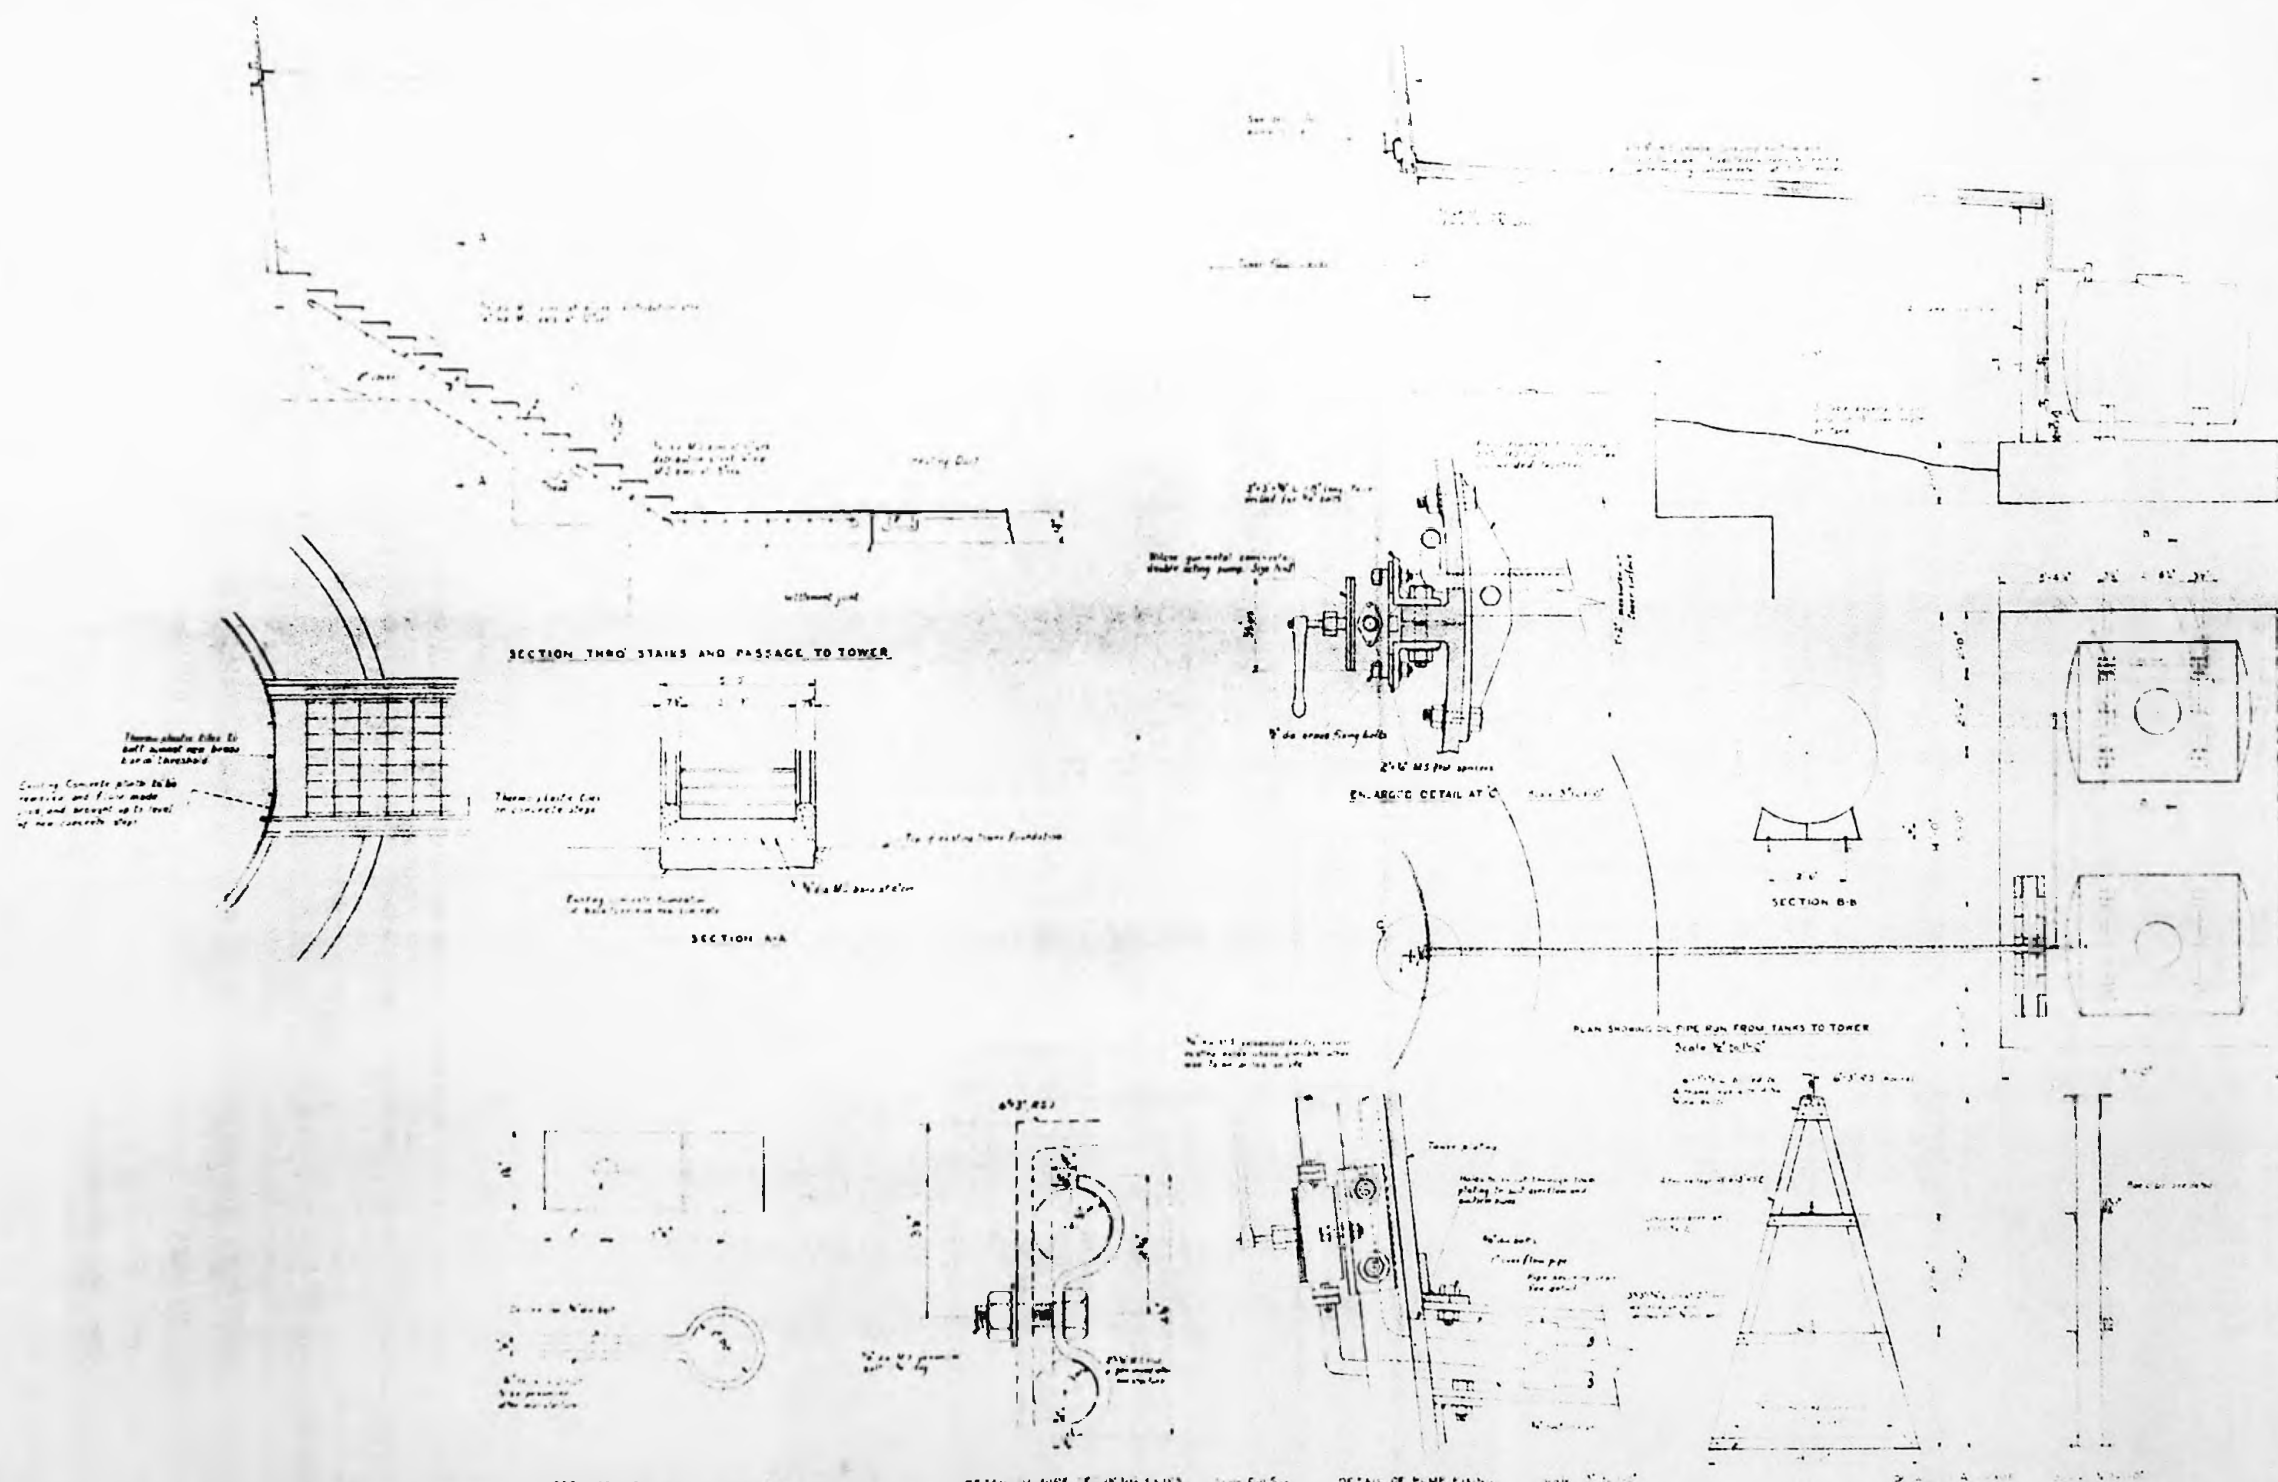
A4

A4

A3

A2

A1



TRINITY HOUSE
ENGINEERS DEPT.

FALKLAND ISLANDS CAPE PEMBROKE LIGHTHOUSE
DETAILS OF STAIRWAY TO TOWER, & STORAGE TANKS FOR PVB OIL

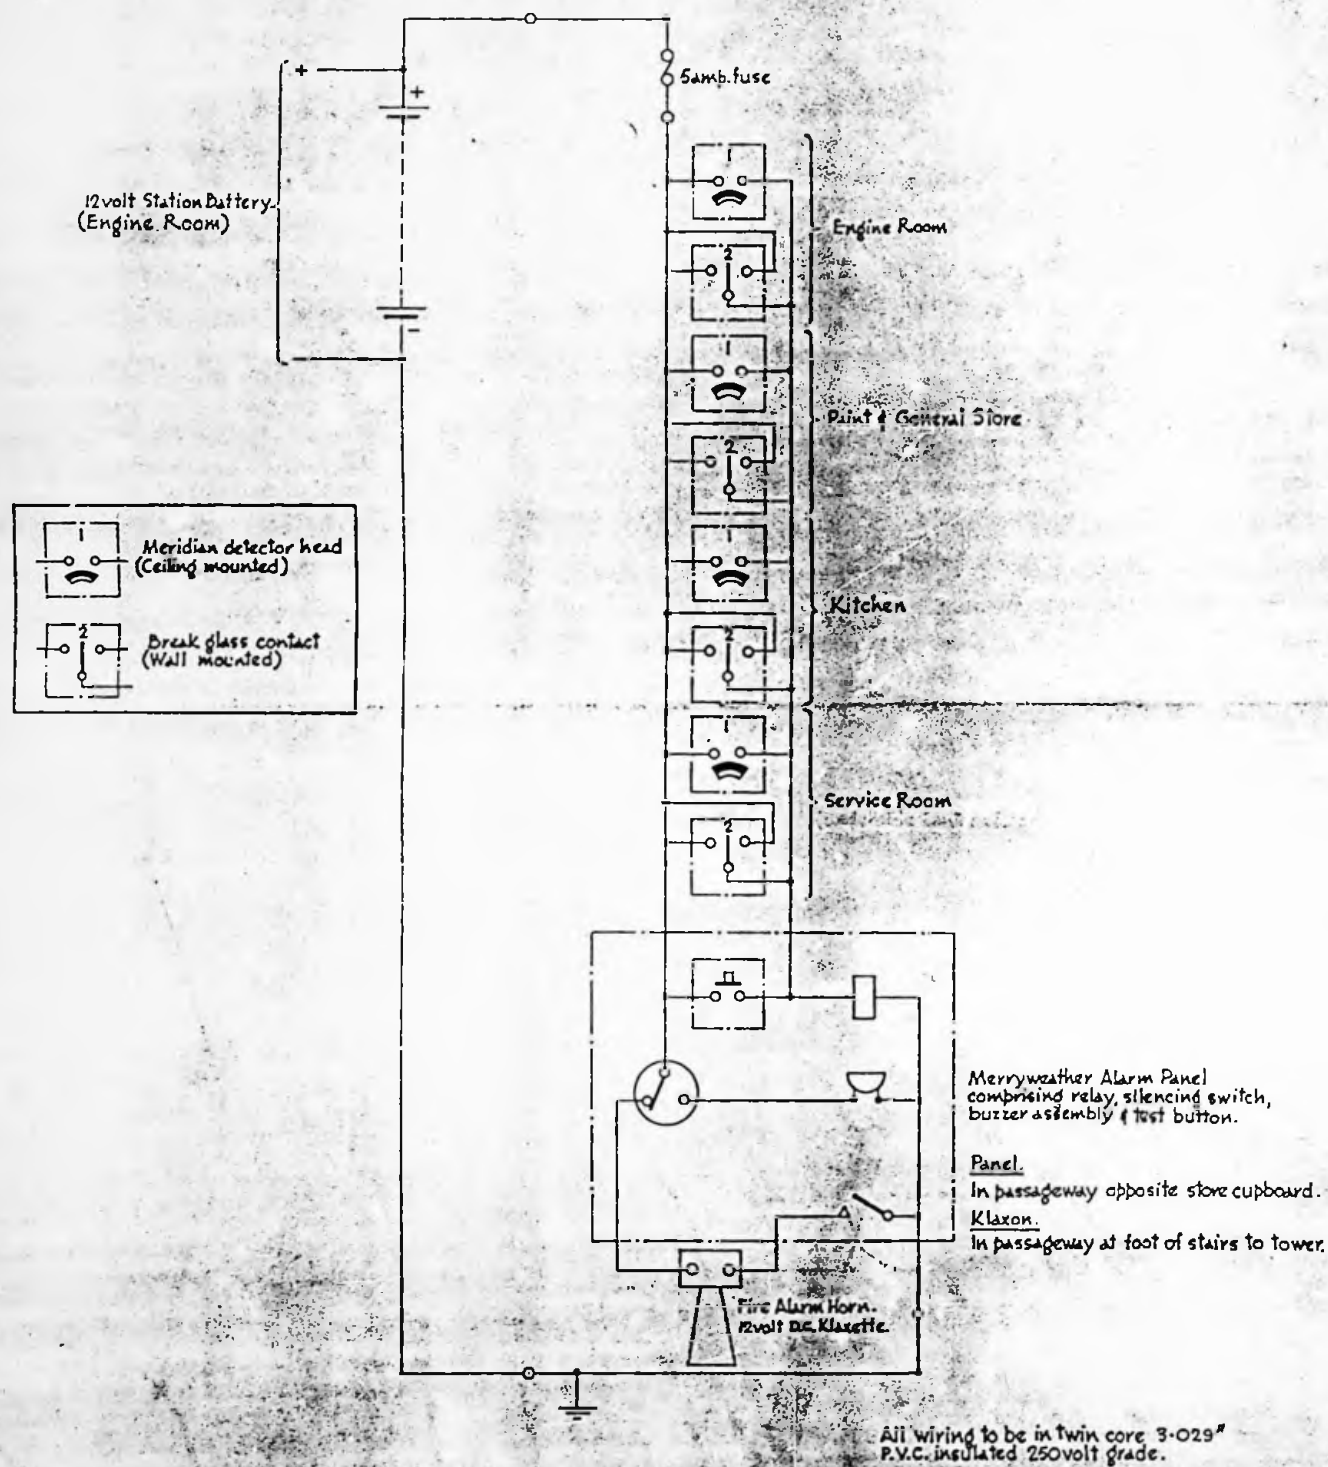
96/73

SCALE - 1/4" = 1'-0"
12/8

0V

DRWG No
F1/7.

FALKLAND ISLANDS. CAPE PEMBROKE LIGHTHOUSE. DETAILS OF FIRE DETECTION EQUIPMENT.



DRG No. F.I.

96/74

DRWG No
F1/7.

MINISTRY OF TRANSPORT
JANUARY 1964

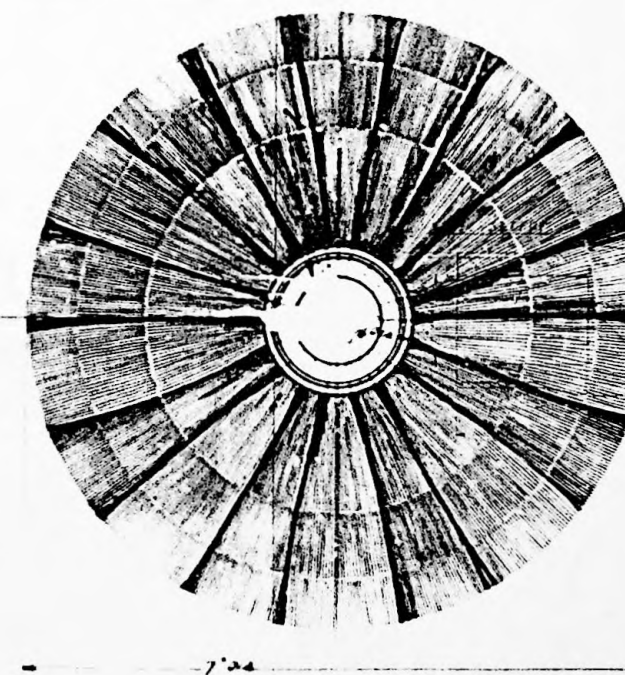
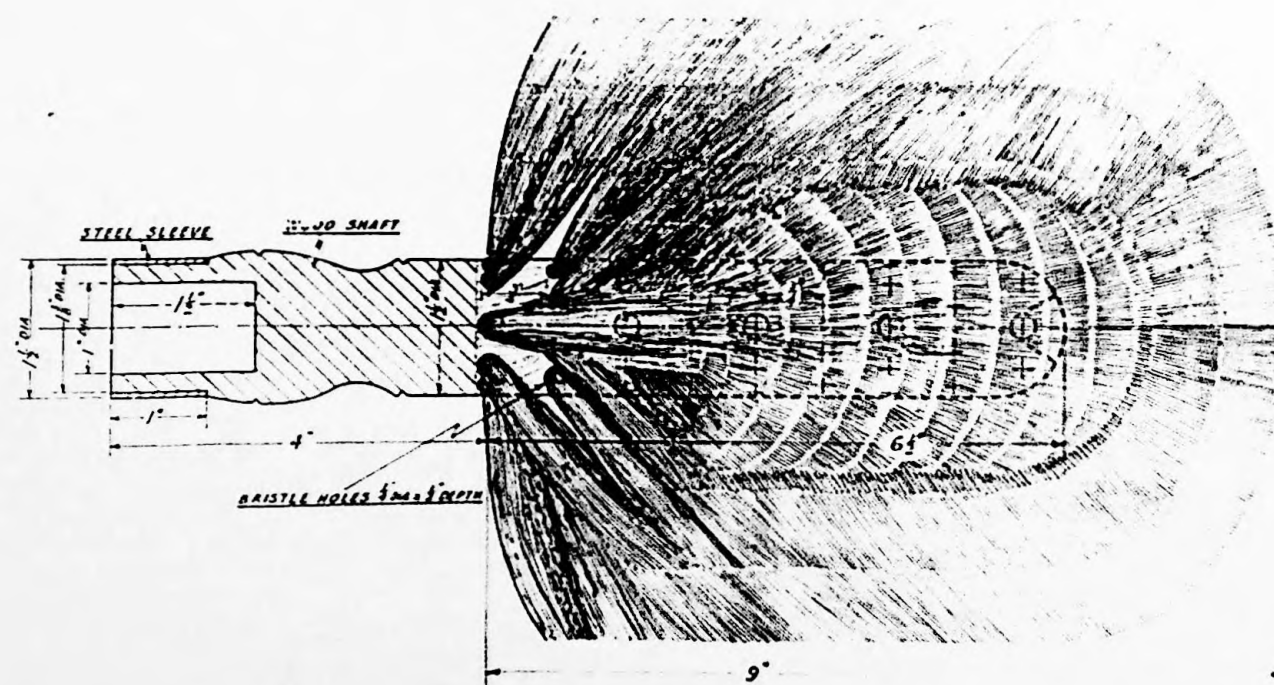
P-269

CAPE PEMBROKE LIGHTHOUSE

WOLF HEAD BRUSH

SCALE FULL SIZE


9 BRISTLE HOLES SPACED SYMMETRICALLY
AROUND THE CIRCUMFERENCE



TRINITY HOUSE
ENGINEERS DEPARTMENT
DRAWN BY DATE
CHECKED BY DATE

96/75

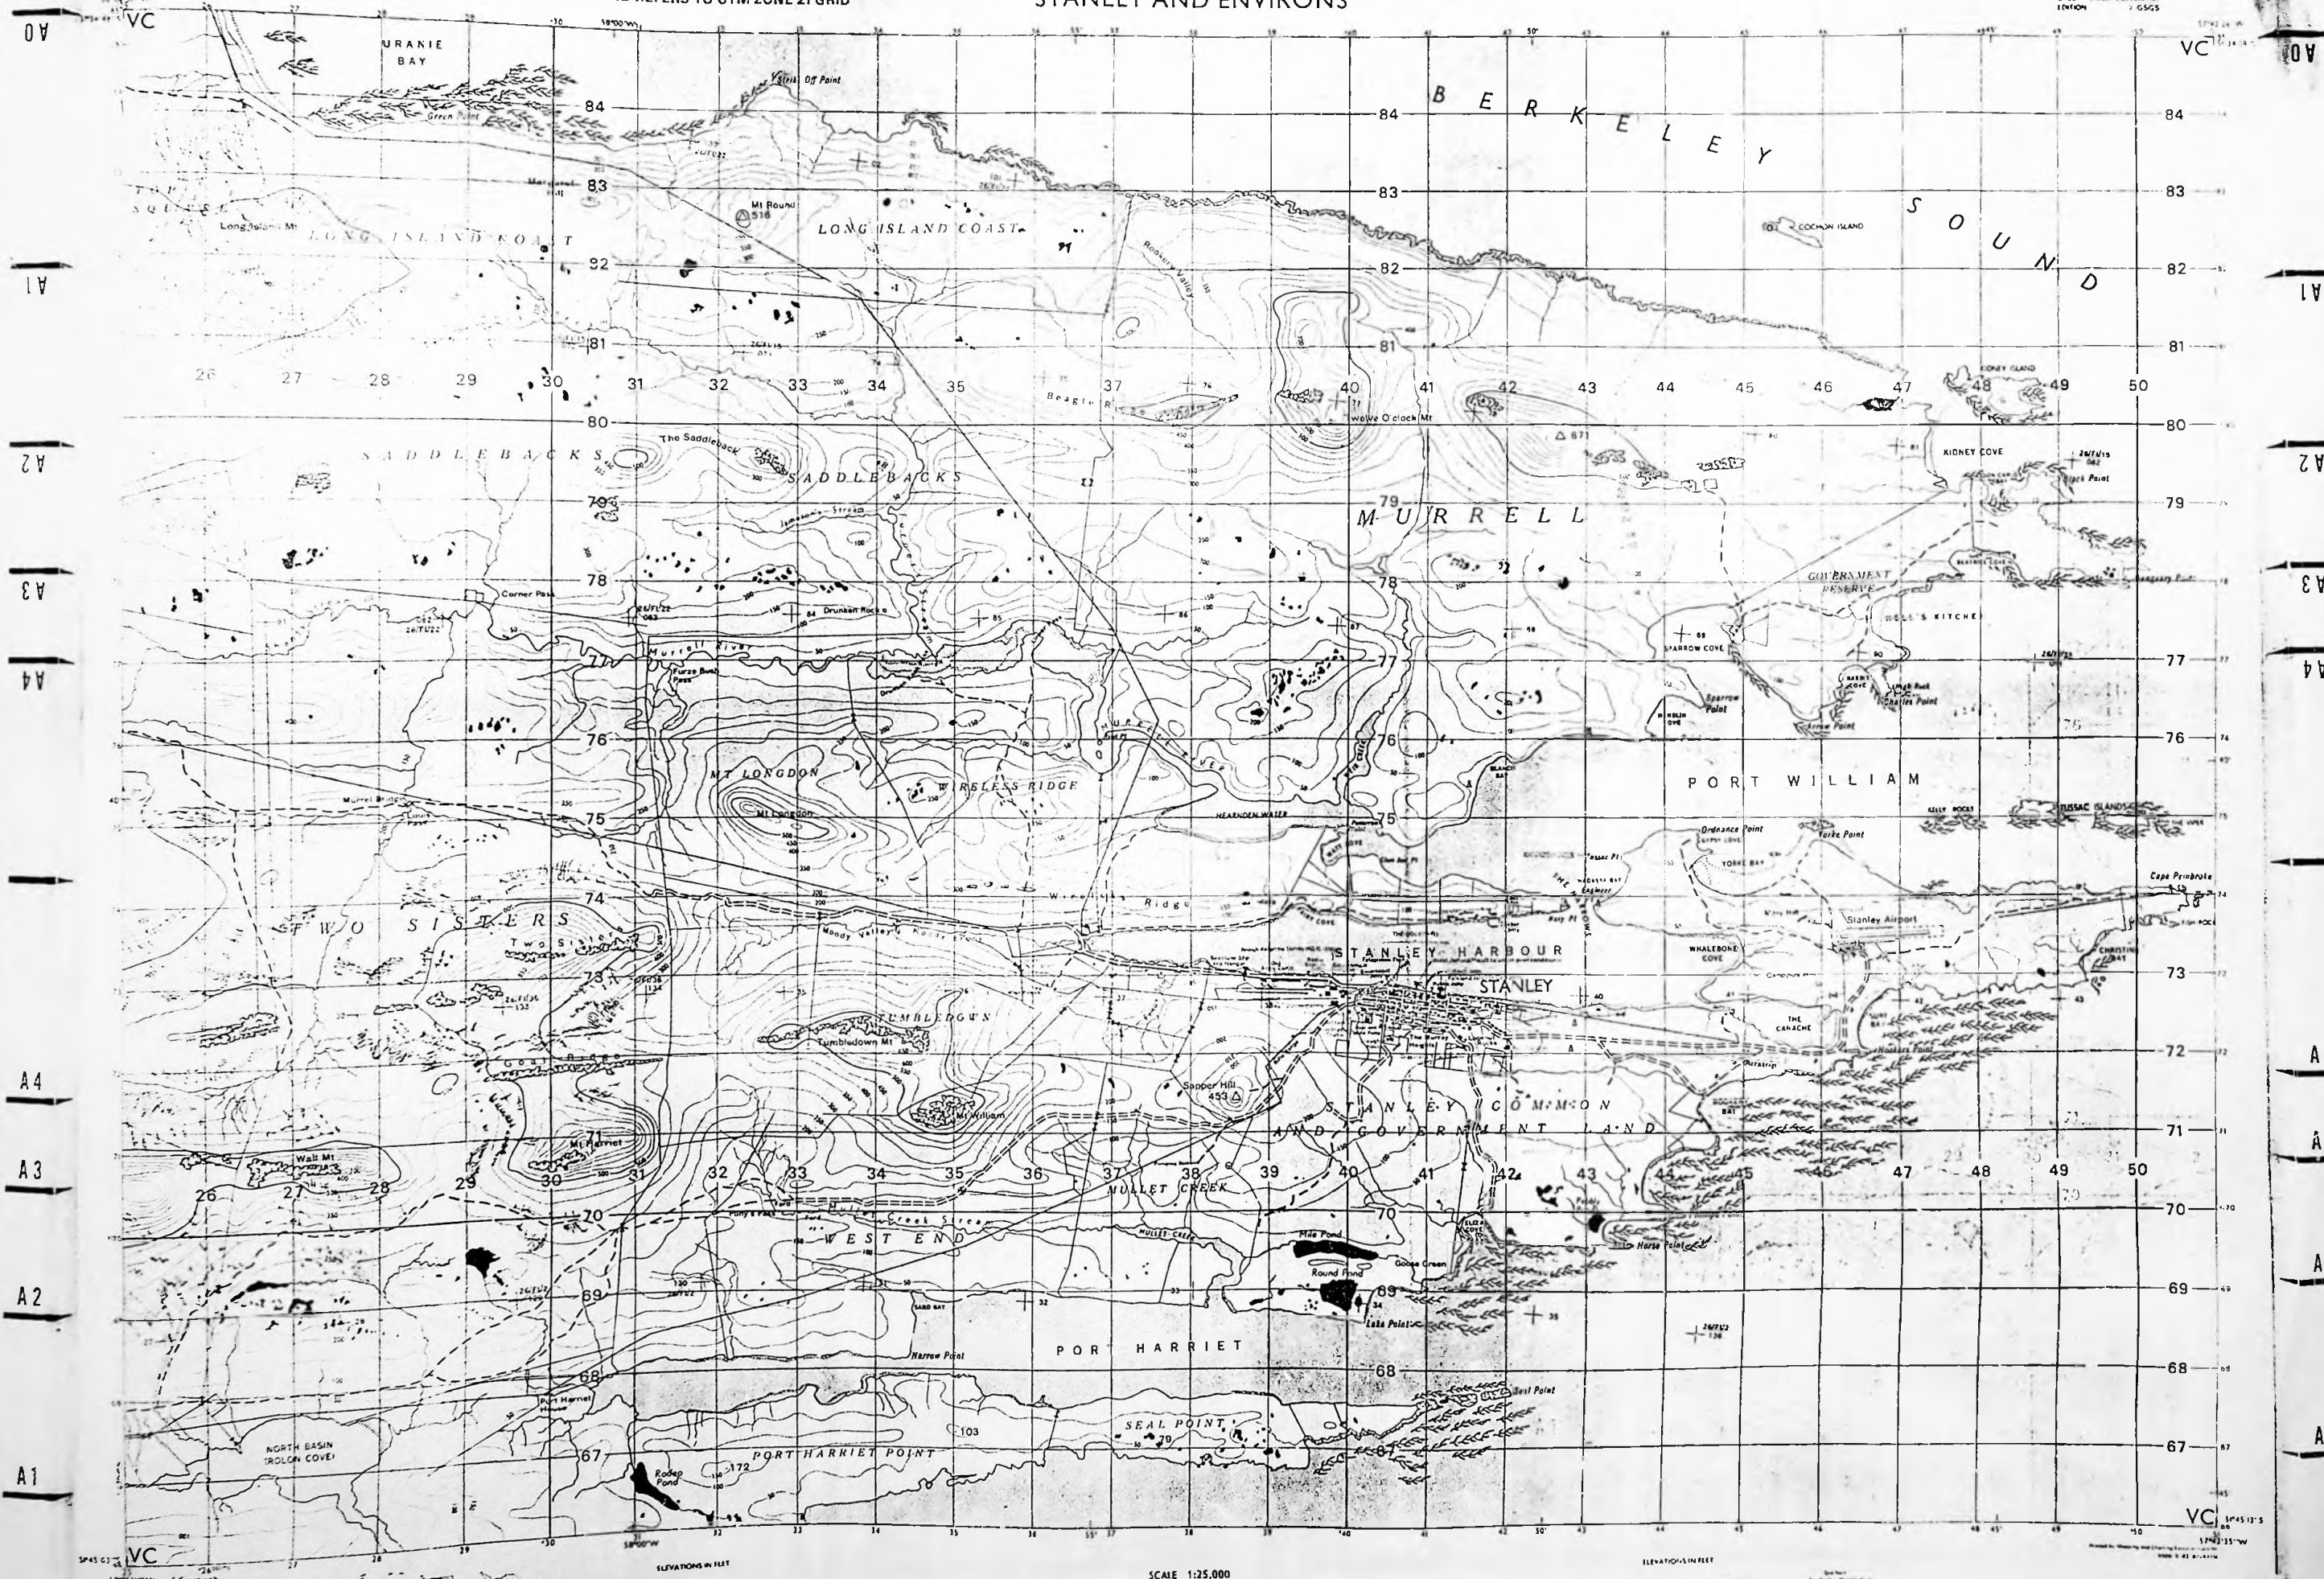P-269



S T A N L E Y H A R B O U R

W	E	S	T	W	A	R	D
---	---	---	---	---	---	---	---

CENTRAL
WARD

E A S T W A R D

T	H	E	M	U	R	R	A	Y	H	E	G	H	T	S
---	---	---	---	---	---	---	---	---	---	---	---	---	---	---

Scale 1:2500 or 25344 Inches to 1 Mile

GSGS 5451 Edition 1-GSGS